


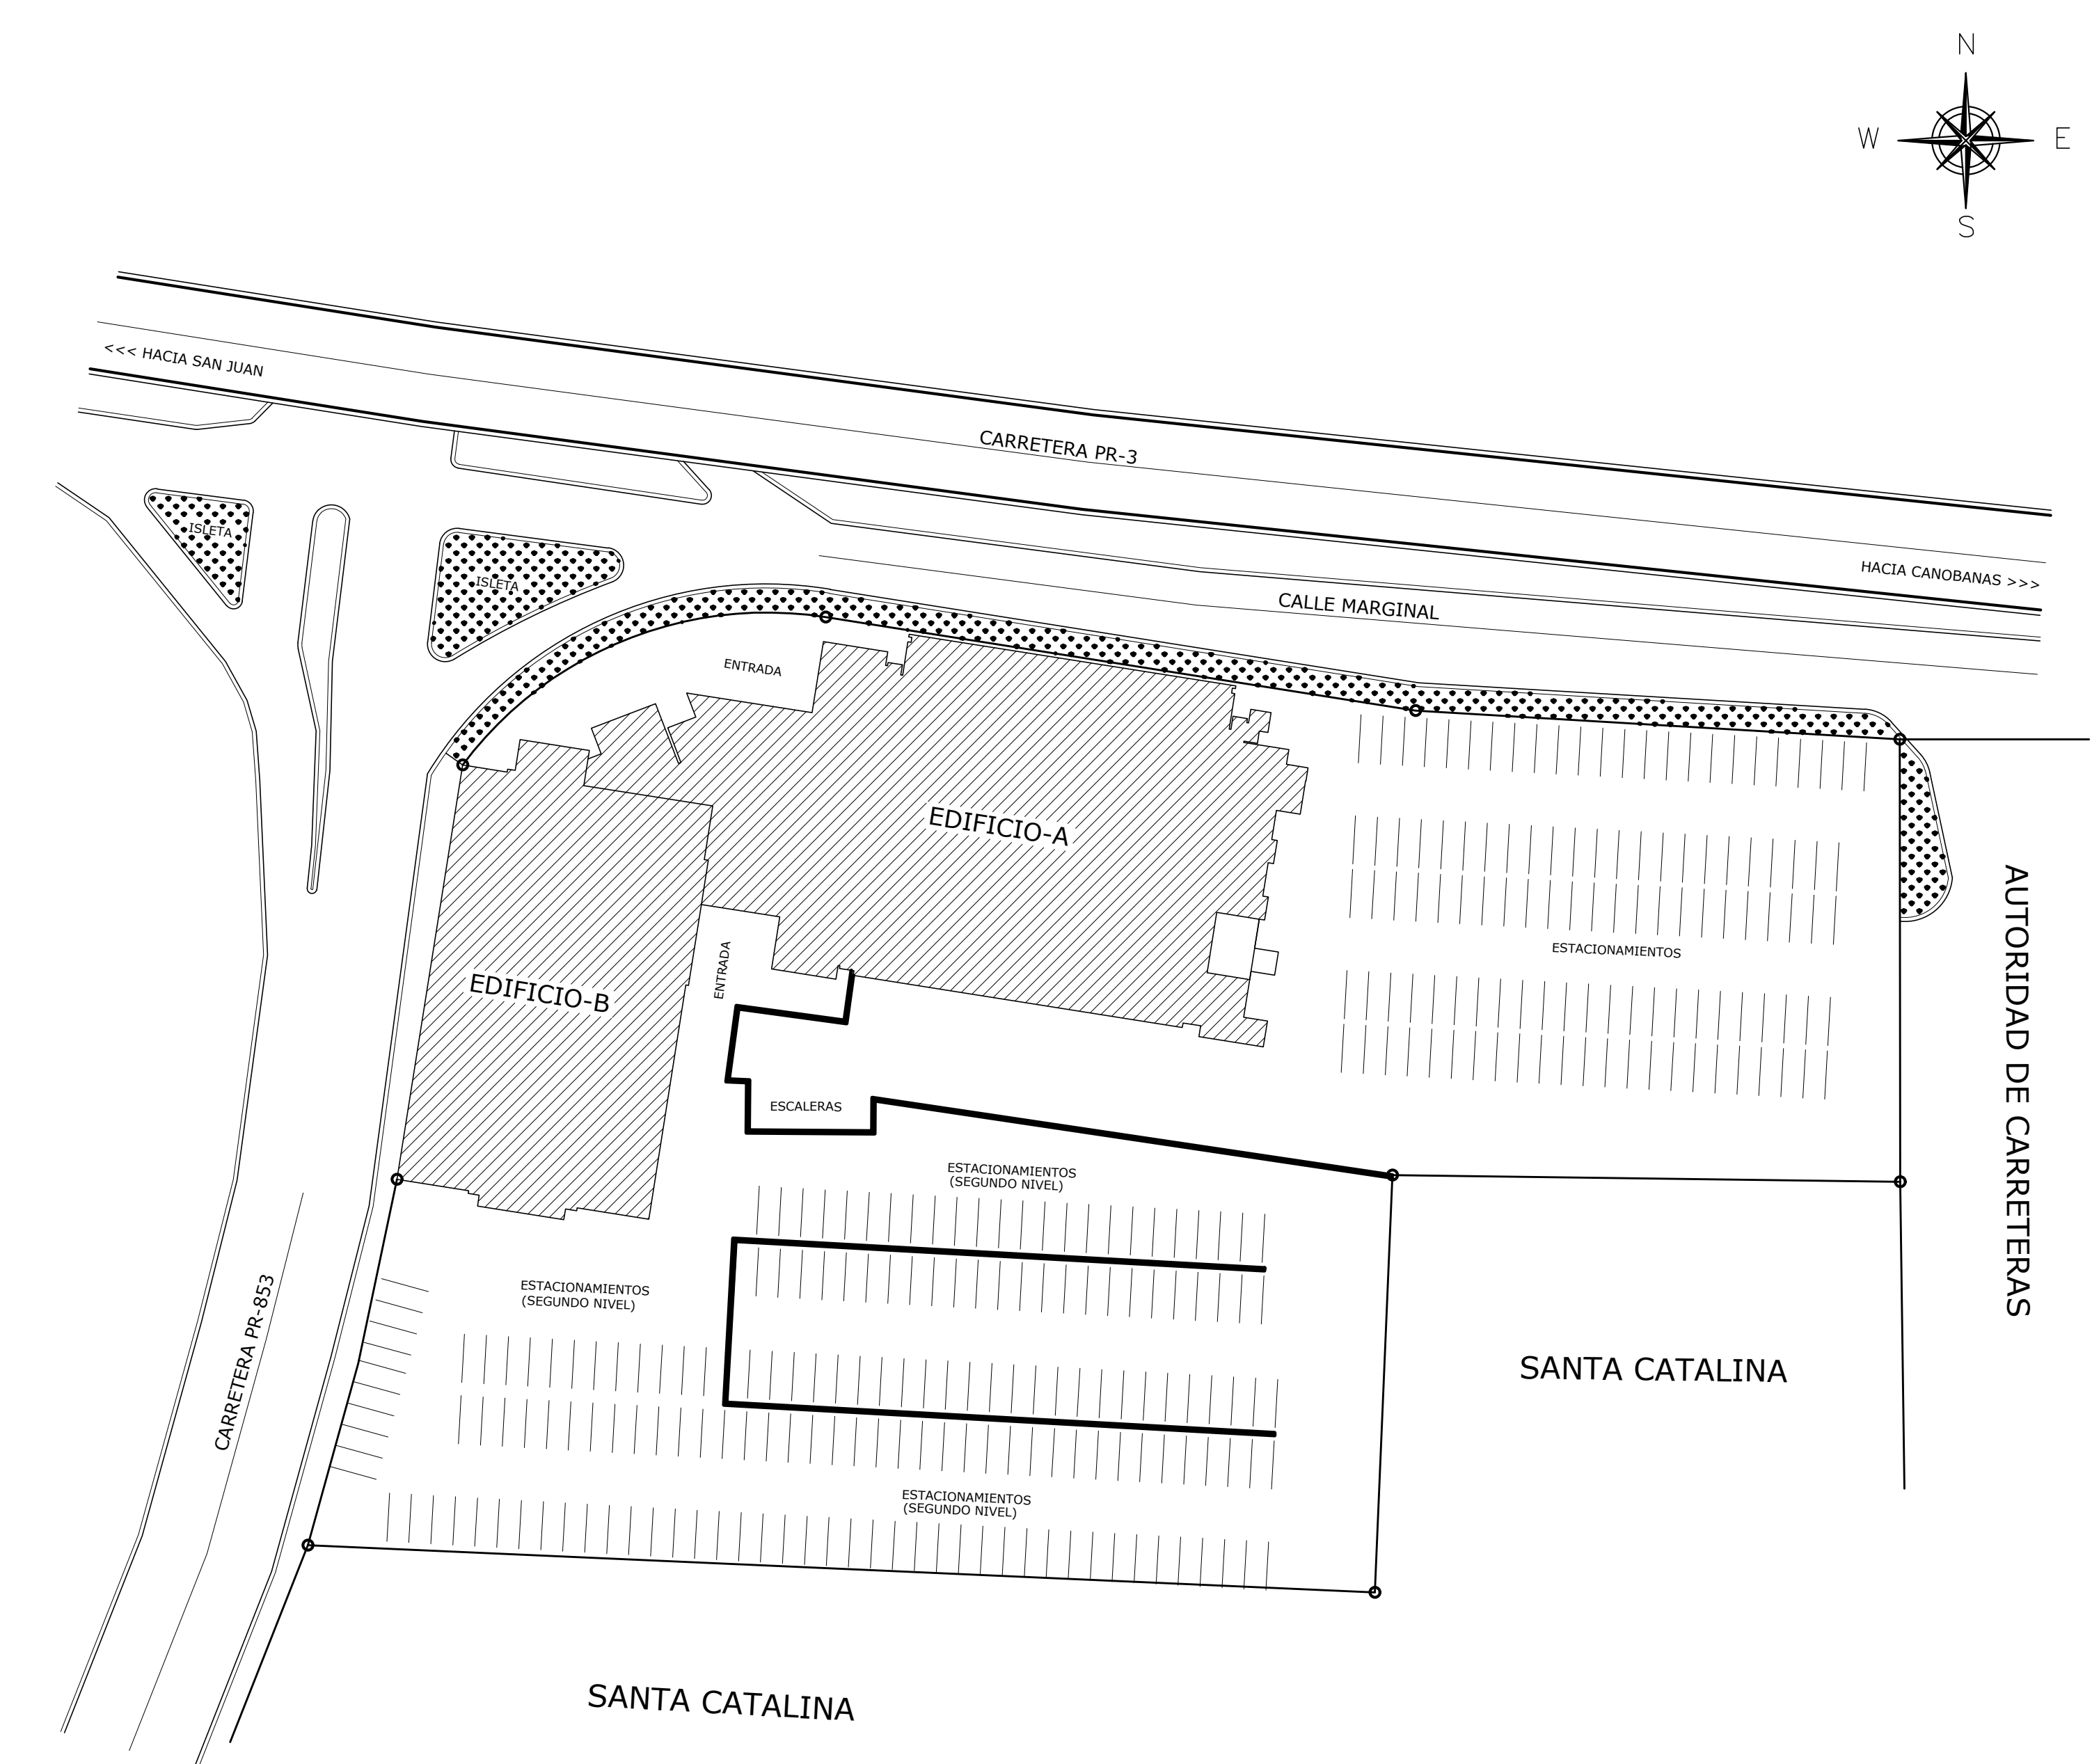

LOCATION PLAN NTS


CENTRO JUDICIAL CAROLINA

PLANO PARA LA REMODELACION DE 12 BAÑOS

PROPIEDAD: PODER JUDICIAL DE PUERTO RICO

UBICADO EN EL BO. TRUJILLO BAJO, CARR. PR-3 KM. 12.1

CAROLINA, PUERTO RICO.

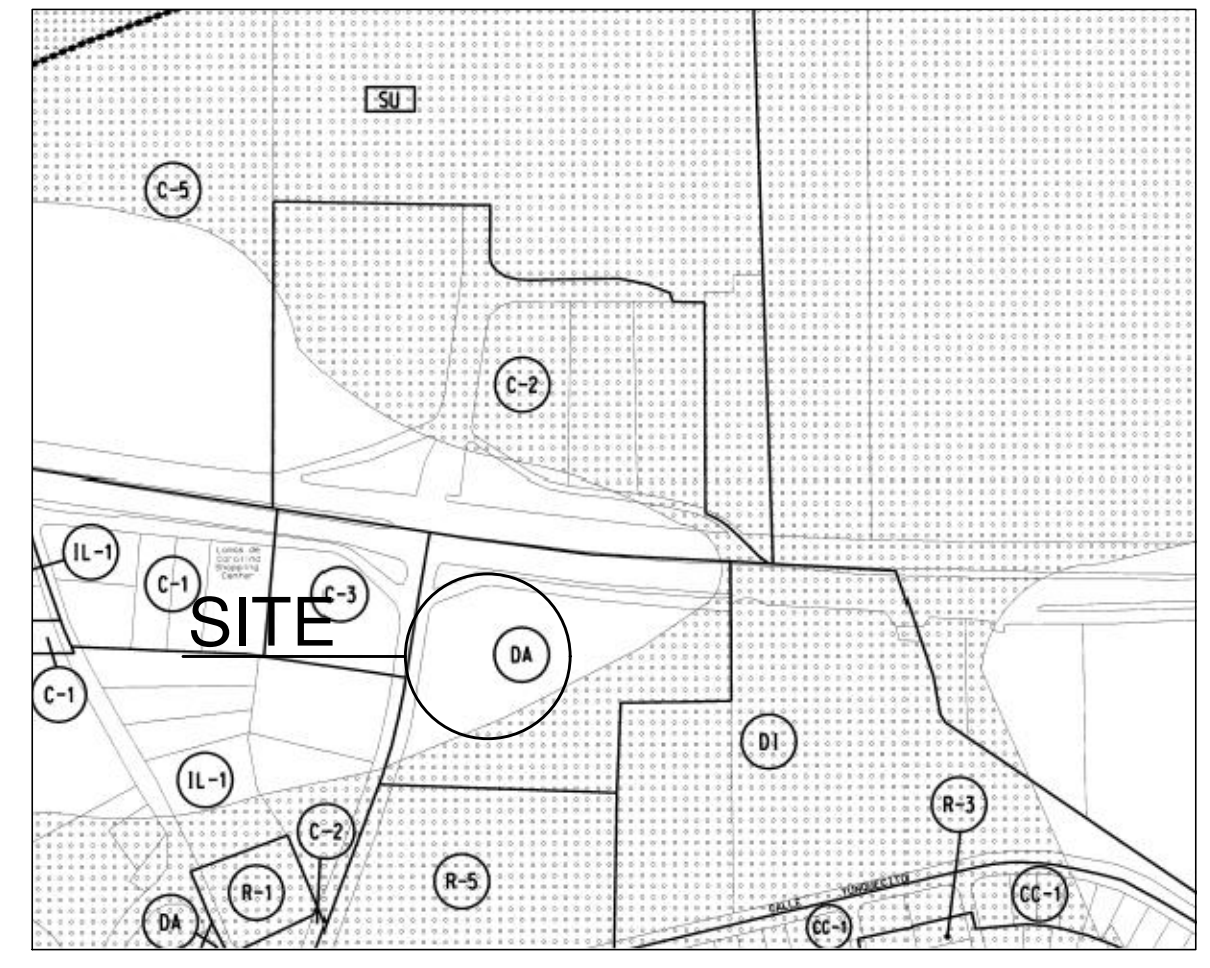


ZONING MAP

PLANO DE CALIFICACION DE SUELO
MUNICIPIO AUTONOMO DE CAROLINA
DA: DOTACIONAL ASISTENCIAL
HOJA 97, 28 DE FEBRERO DE 2007


SHEET INDEX:

- | | TITLE SHEET |
|--------|--|
| AX-101 | RESTROOMS EXISTING FLOOR PLANS |
| AD-101 | RESTROOMS DEMOLITION FLOOR PLANS |
| AI-101 | FIRST LEVEL PROPOSED RESTROOMS FLOOR PLANS |
| AI-102 | SECOND LEVEL PROPOSED RESTROOMS FLOOR PLANS |
| AI-103 | THIRD LEVEL PROPOSED RESTROOMS FLOOR PLANS |
| AI-104 | FOURTH LEVEL PROPOSED RESTROOMS FLOOR PLANS |
| AI-105 | PROPOSED RESTROOMS REFLECTED CEILING PLANS |
| AI-106 | PROPOSED RESTROOMS FINISHES FLOOR PLANS |
| AI-401 | PROPOSED RESTROOMS ENLARGED FLOOR PLANS & ELEVATIONS |
| AI-402 | PROPOSED RESTROOMS ENLARGED FLOOR PLANS & ELEVATIONS |
| AI-403 | PROPOSED RESTROOMS ENLARGED FLOOR PLANS & ELEVATIONS |
| AI-601 | DOOR SCHEDULE & DETAILS |
| AI-602 | PLUMBING FIXTURES SCHEDULE |
| E-101 | LIGHTING PLAN |

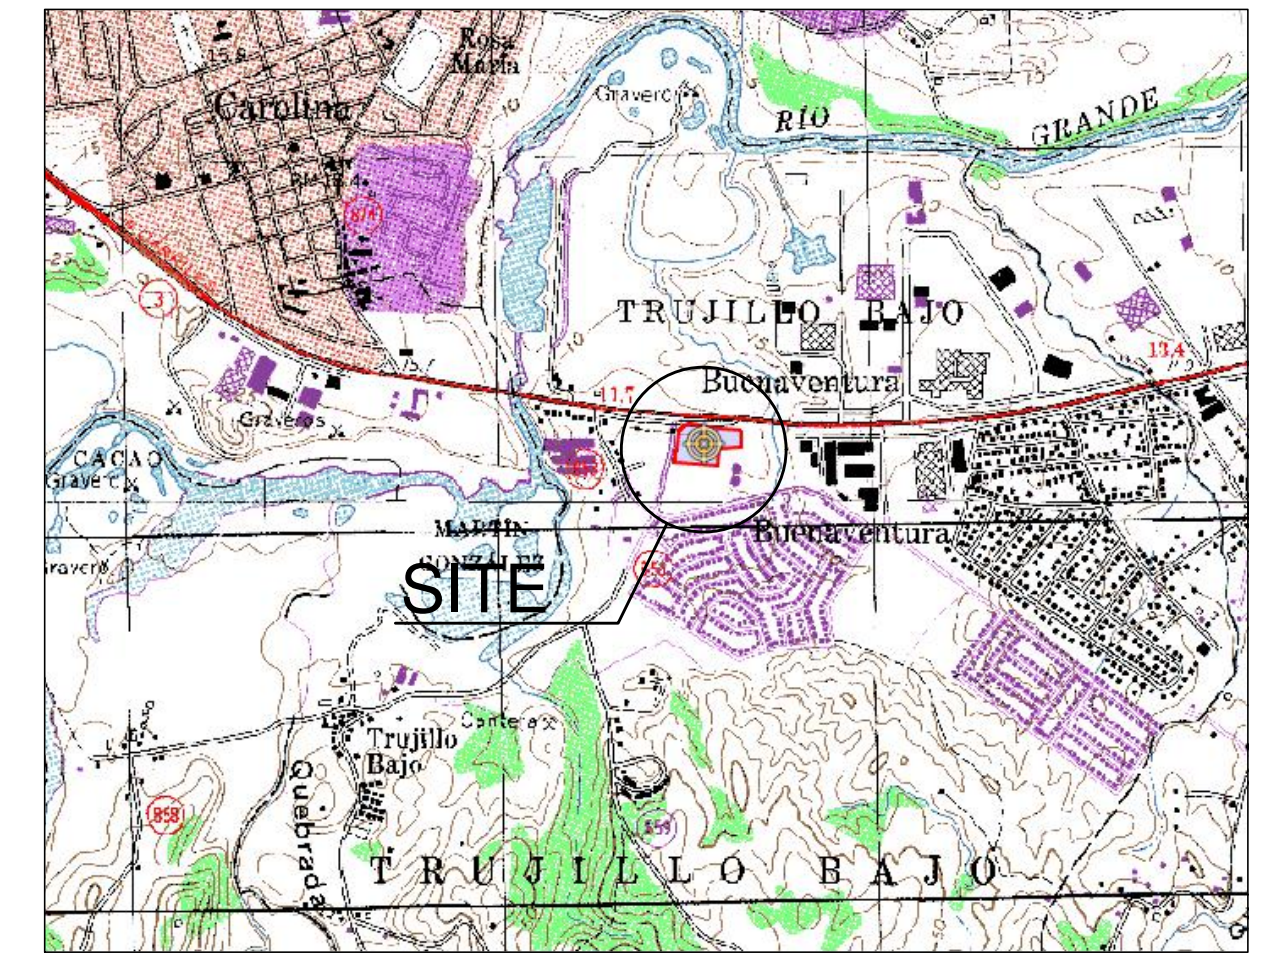

LOCATION MAP

SCALE: 1:20,000
Coordinates Nad83:
X = 251415.1897
Y = 259948.3793
Lat: 18.37434825, Lon: -65.94680846

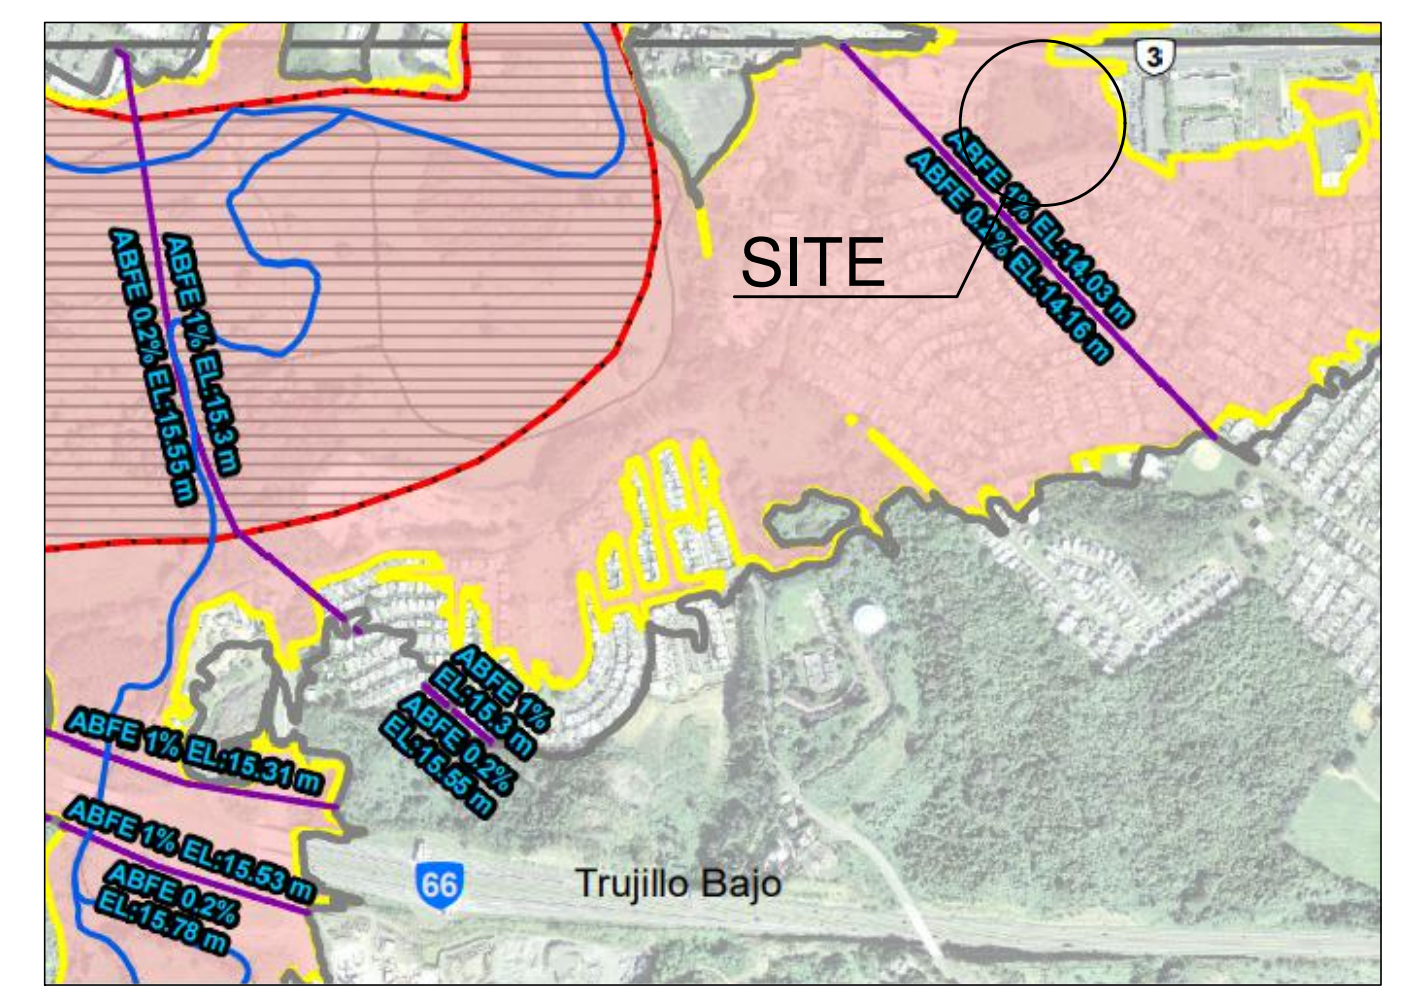

FLOOD MAP

PANEL: 1665 DE 2160
"MAP NUMBER": FM72000C0755J
MAP REVISED: 13 DE ABRIL DE 2018
AE

Yo, ing. Horacio E. Diaz Corvalan, con número de licencia 13414, certifico que soy el profesional que diseñó estos planos y las especificaciones complementarias. También certifico que entiendo que dichos planos y especificaciones cumplen con las disposiciones aplicables de los Reglamentos y Códigos de Agencias, Juntas Reglamentadoras o Corporaciones Públicas con jurisdicción. Reconozco que cualquier declaración falsa o falsificación de los hechos que se haya producido sin conocimiento o por negligencia, ya sea por mí, mis agentes o empleados, o por otras personas con mi conocimiento, me hacen responsable de cualquier acción judicial y disciplinaria ante cualquier autoridad competente.


PROJECT NO.: 2022 39




HORACIO DIAZ & ASSOCIATES PSC
CONSULTING ENGINEERS
6 URB. COSTA VERDE
HUMACAO, PUERTO RICO 00791-6036
TEL: (787) 568-1620
E-MAIL: horacio@hdcpr.com




REVISIONS		DATE:	SCALE:
O1	BID SET STAMP ADDED &	4/24/2023	AS SHOWN
	REVISED DATE	DRAWN BY:	SHEET NO.:
		H. DIAZ	1 OF 15

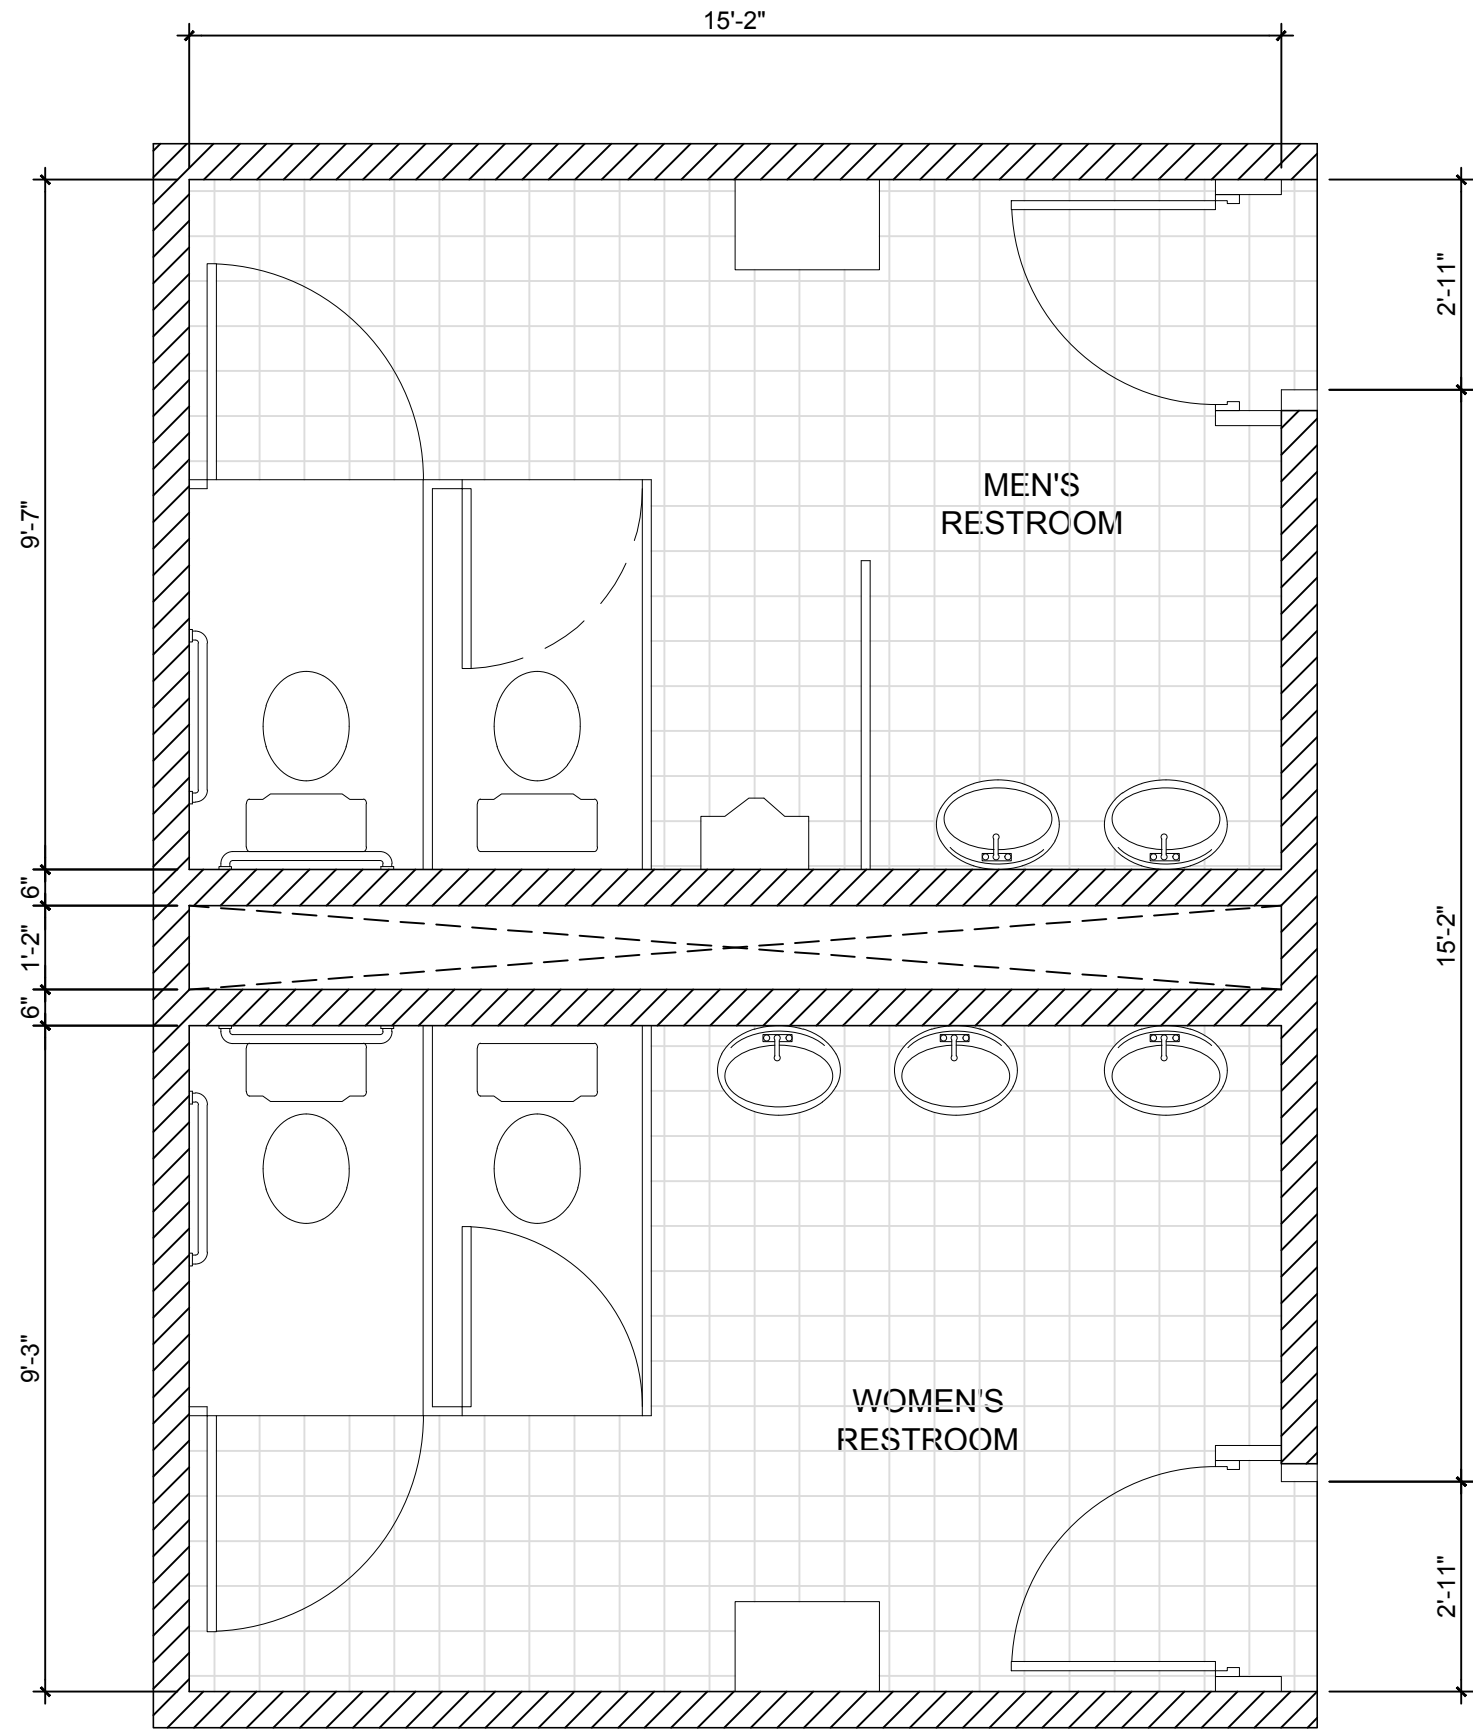

RESTROOM 1 - AS-BUILT FLOOR PLAN
1ST, 2ND, 3RD & 4TH FLOOR
SCALE: 3/8"=1'-0"

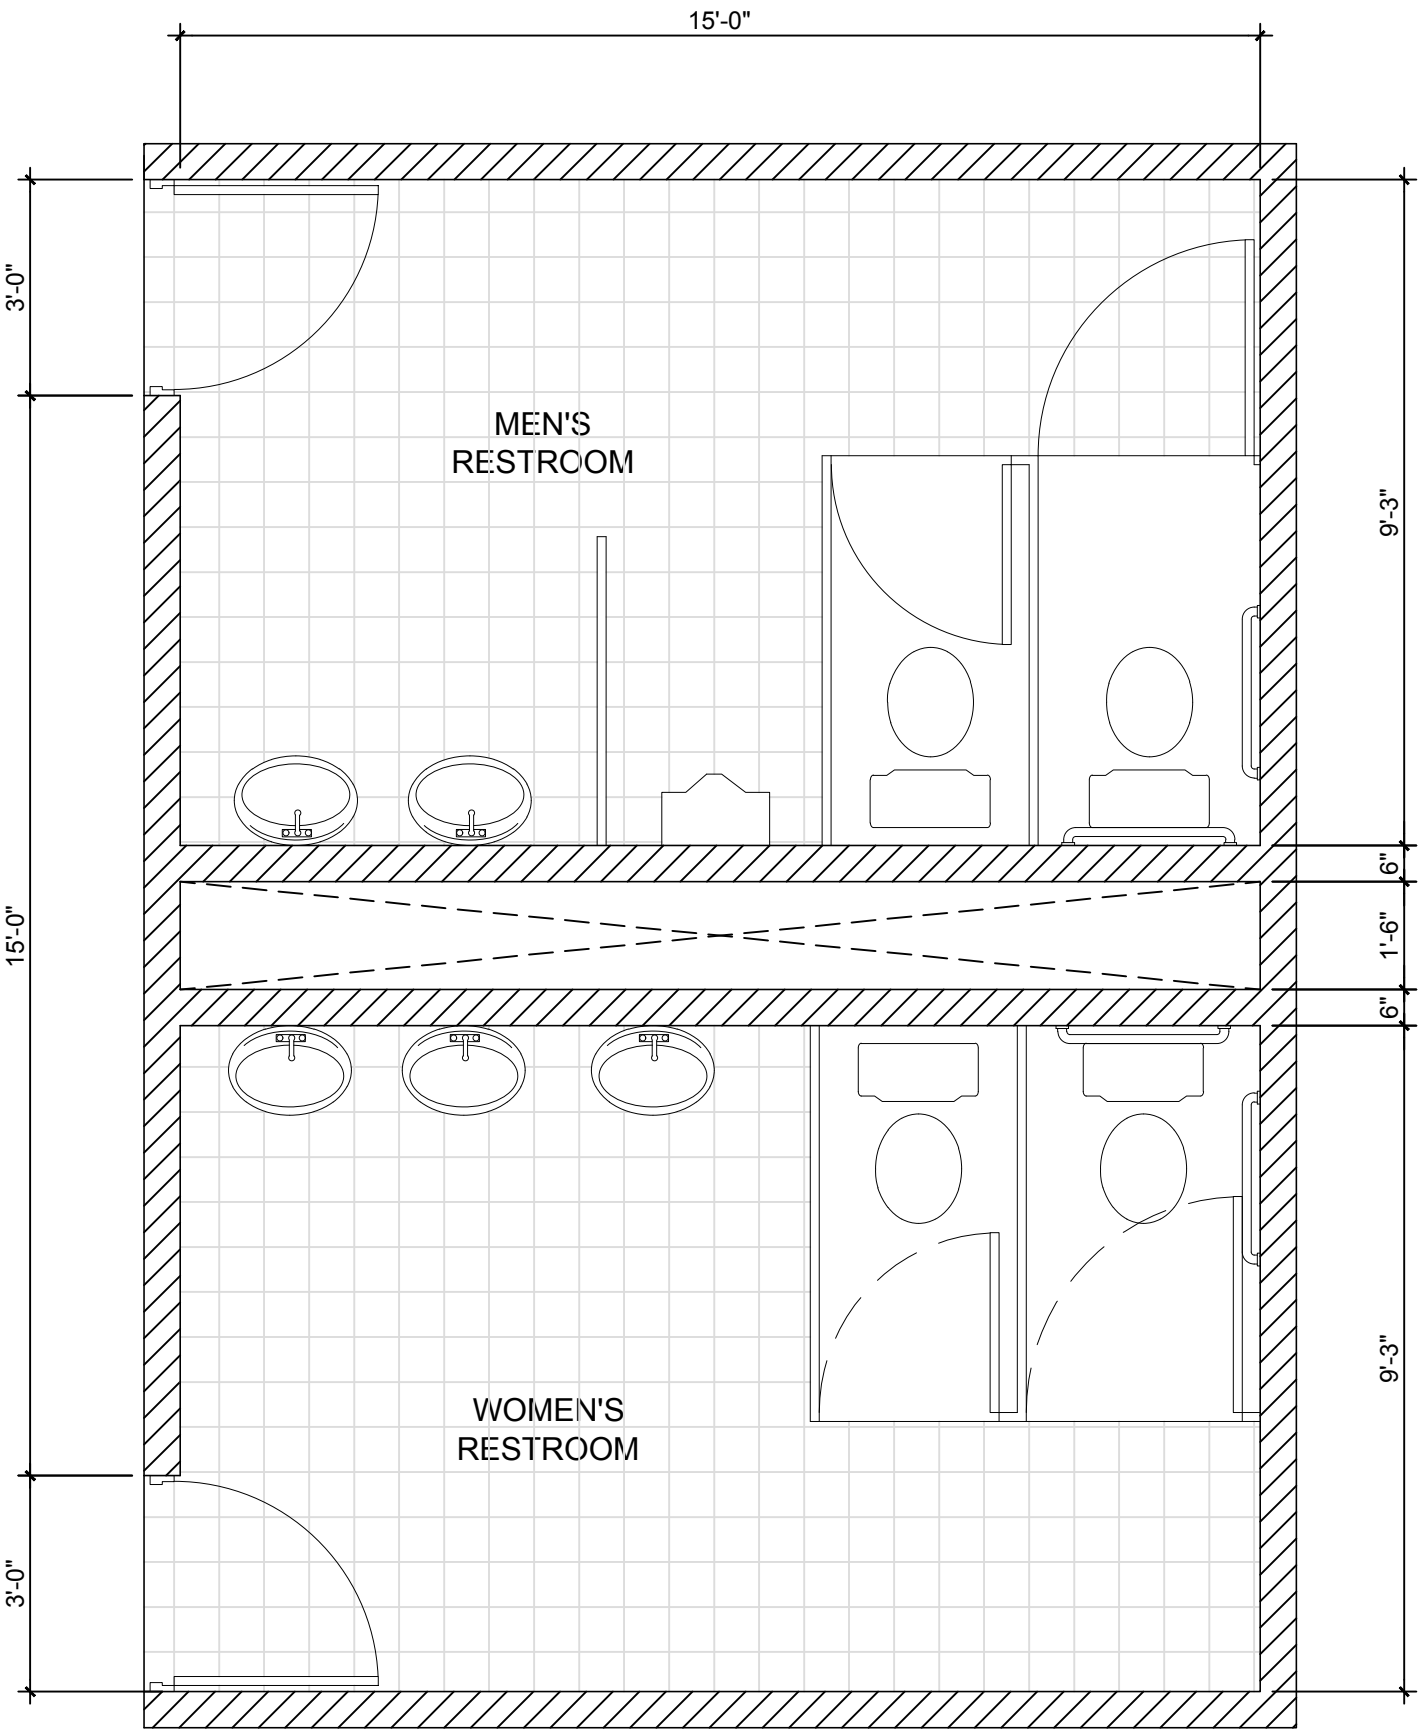


RESTROOM 2 - AS-BUILT FLOOR PLAN
1ST, 2ND, 3RD & 4TH FLOOR
SCALE: 3/8"=1'-0"

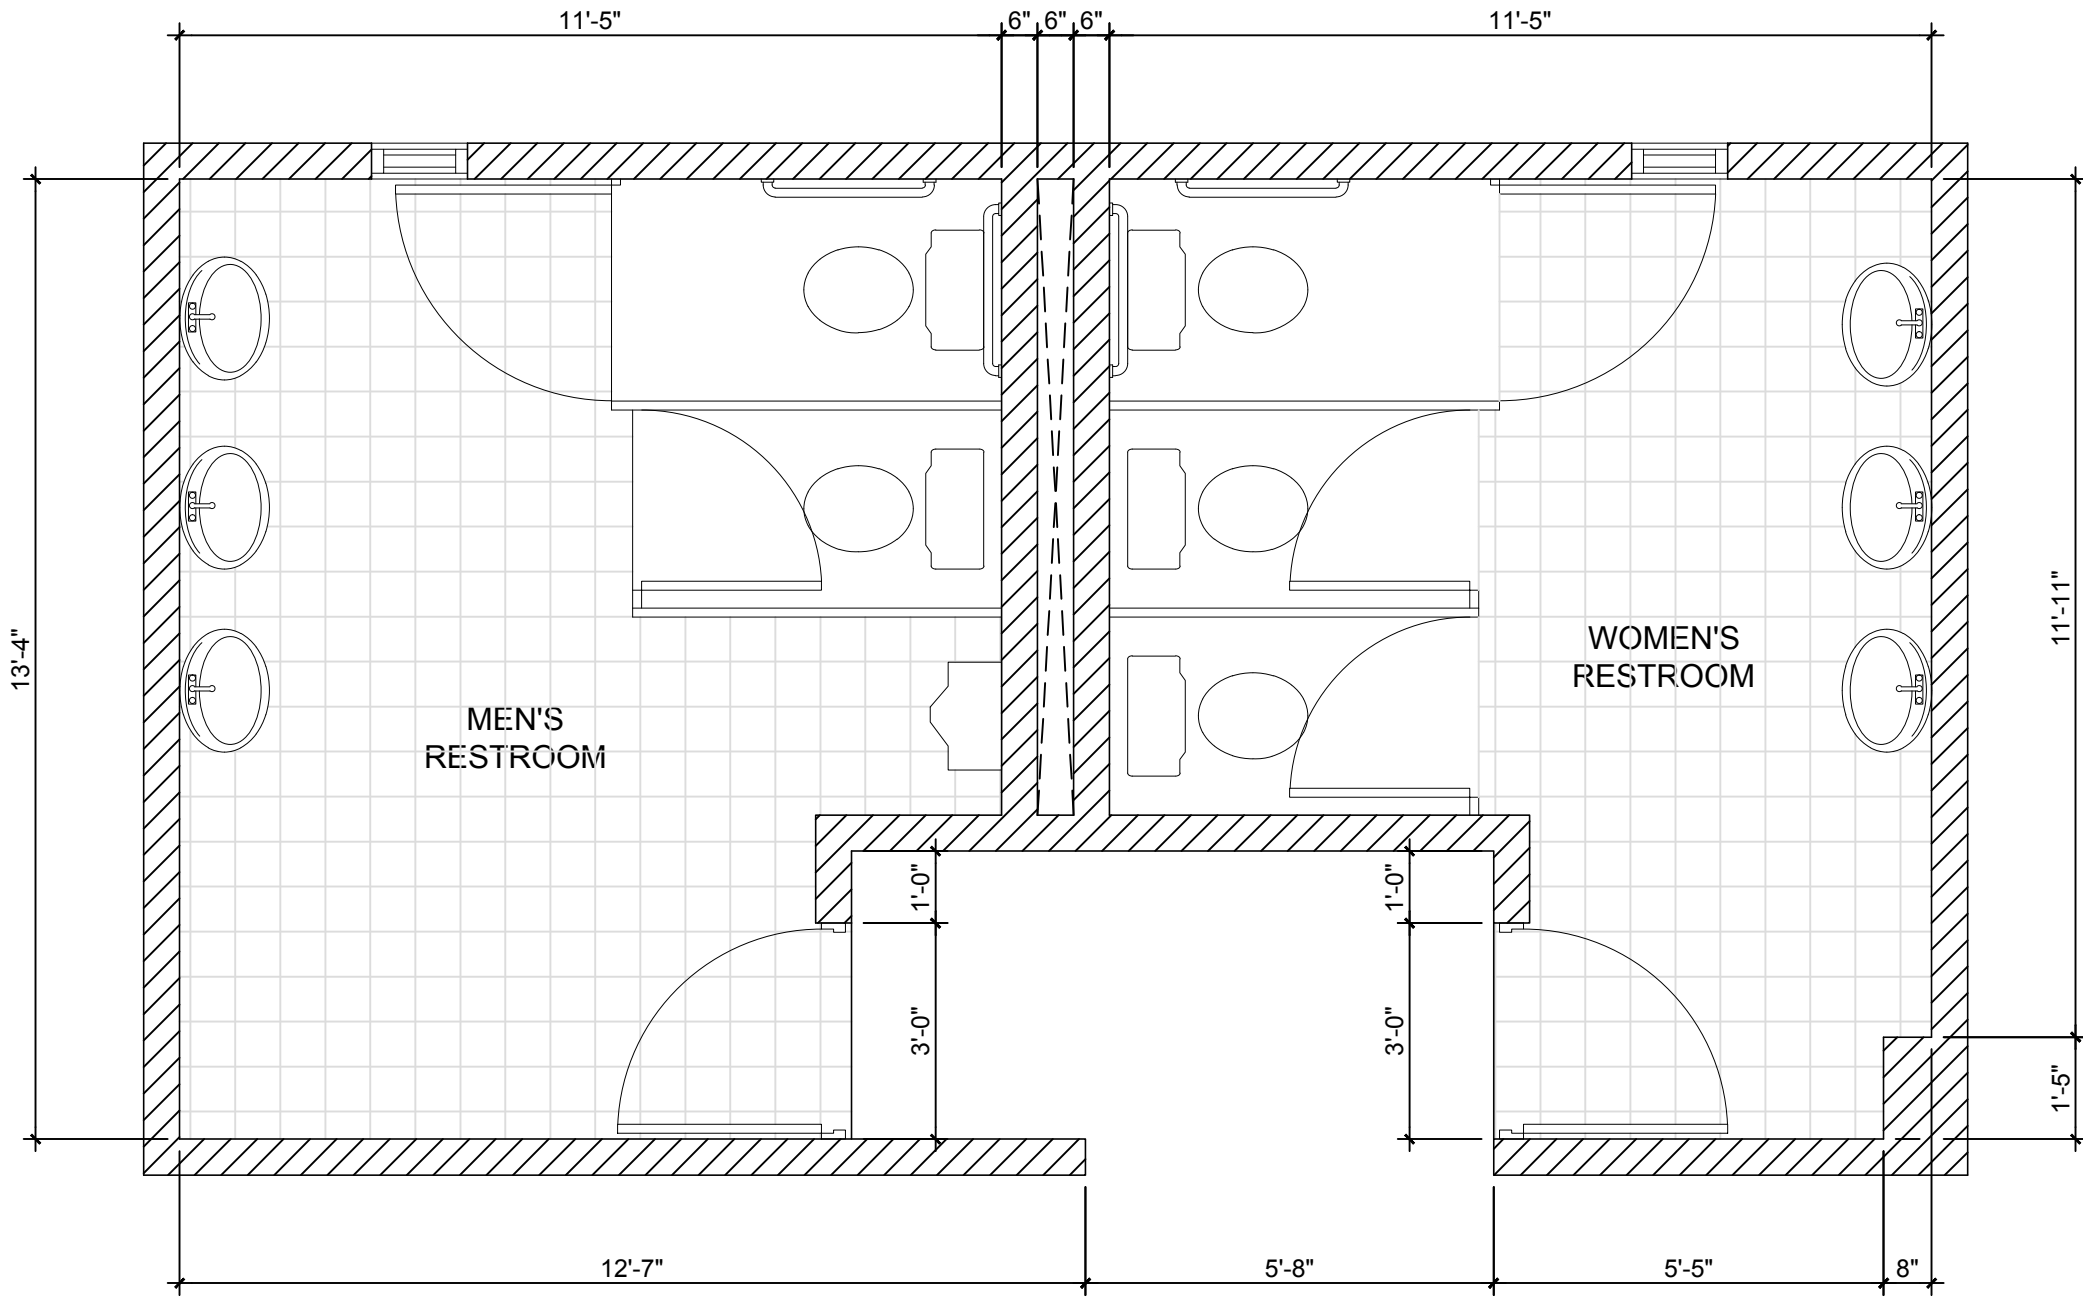

RESTROOM 3 - AS-BUILT FLOOR PLAN
1ST, 2ND, 3RD & 4TH FLOOR
SCALE: 3/8"=1'-0"

AS-BUILT KEYNOTES:

1. CONTRACTOR SHALL TAKE FIELD MEASUREMENTS OF ANY EXISTING CONDITIONS AND SHALL OBSERVE ANY CONDITIONS AT THE SITE AFFECTING IT.
2. THE CONTRACTOR SHALL PROMPTLY REPORT TO THE ARCHITECT/ENGINEER ANY ERRORS, INCONSISTENCIES OR OMISSIONS DISCOVERED OR MADE KNOWN TO THE CONTRACTOR.

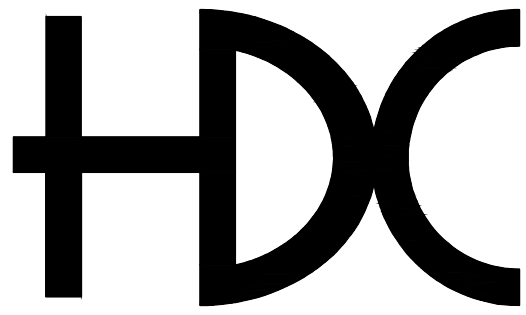

HORACIO DIAZ & ASSOCIATES PSC
CONSULTING ENGINEERS

6 URB. COSTA VERDE
HUMACAO, PUERTO RICO 00791-6036
TEL: (787) 568-1620
E-MAIL: horacio@hdcpr.com



STAMP | SELLO

RESTROOM
DEMOLITION
FLOOR PLANS

TITLE SHEET | TITULO DE LA HOJA



BID SET
NOT FOR CONSTRUCTION
APR 24, 2023

BO. TRUJILLO
BAJO, CARR.
PR-3 KM. 12.1
CAROLINA, PR

CENTRO
JUDICIAL DE
CAROLINA
PODER
JUDICIAL DE
PUERTO RICO

PROJECT NAME | NOMBRE DEL PROYECTO

THIS DRAWING AND ITS CONTENTS BELONGS TO
HORACIO DIAZ & ASSOCIATES.
THEY SHALL BE USED AS A REFERENCE DOCUMENT AND
WORKING INSTRUMENT ONLY BY AUTHORIZED PERSONNEL.
ANY TOTAL OR PARTIAL REPRODUCTION OR USE OF
THIS DOCUMENT IS STRICTLY PROHIBITED WITHOUT THE
APPROPRIATED WRITTEN CONSENT OF THIS FIRM AND
SHALL BE RETURNED TO THEIR OFFICE IF REQUIRED.

REVISIONS | REVISIONES

NO.	DESCRIPTION	DATE

DRAWN BY | DIBUJADO POR: H. DIAZ
CHECK BY | COTEJADO POR: H. DIAZ
DESIGN BY | DISEÑADO POR: H. DIAZ
APPROVED BY | APROBADO POR: H. DIAZ
DATE | FECHA: APRIL 24, 2023
SCALE | ESCALA: AS SHOWN

PROJECT NO. | NÚM. PROYECTO


2022 39

SHEET NO. | NÚM. DE HOJA

2 OF 15


DRAWING NO. | NÚM. DE DIBUJO

AX-101

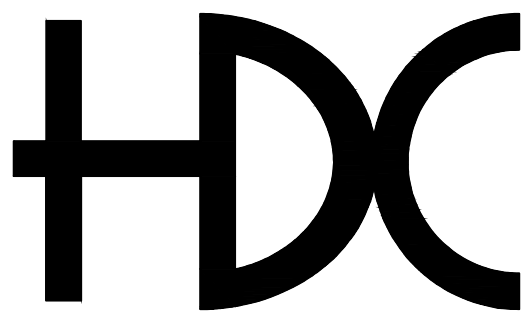

HORACIO DIAZ & ASSOCIATES PSC
CONSULTING ENGINEERS

6 URB. COSTA VERDE
HUMACAO, PUERTO RICO 00791-6036
TEL: (787) 568-1620
E-MAIL: horacio@hdcpr.com

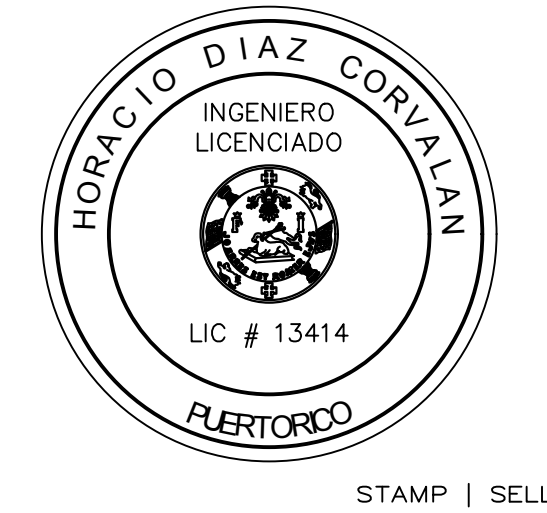

STAMP | SELLO

RESTROOM
DEMOLITION
FLOOR PLANS

TITLE SHEET | TITULO DE LA HOJA

HDC BID SET
NOT FOR CONSTRUCTION
APR 24, 2023

BO. TRUJILLO
BAJO, CARR.
PR-3 KM. 12.1
CAROLINA, PR

CENTRO
JUDICIAL DE
CAROLINA
PODER
JUDICIAL DE
PUERTO RICO

PROJECT NAME | NOMBRE DEL PROYECTO

THIS DRAWING AND ITS CONTENTS BELONGS TO
HORACIO DIAZ & ASSOCIATES.
THEY SHALL BE USED AS A REFERENCE DOCUMENT AND
WORKING INSTRUMENT ONLY BY AUTHORIZED PERSONNEL.
ANY TOTAL OR PARTIAL REPRODUCTION OR USE OF
THIS DOCUMENT IS STRICTLY PROHIBITED WITHOUT THE
APPROPRIATED WRITTEN CONSENT OF THIS FIRM AND
SHALL BE RETURNED TO THEIR OFFICE IF REQUIRED.

REVISIONS | REVISIONES

NO.	DESCRIPTION	DATE
01	REVISED LEGEND & PLAN	APR 24, 2023

DRAWN BY | DIBUADO POR H. DIAZ
CHECK BY | COTEJADO POR H. DIAZ
DESIGN BY | DISEÑADO POR H. DIAZ
APPROVED BY | APROBADO POR H. DIAZ

DATE | FECHA APRIL 24, 2023
SCALE | ESCALA AS SHOWN

PROJECT NO. | NÚM. PROYECTO


2022 39

SHEET NO. | NÚM. DE HOJA

3 OF 15


DRAWING NO. | NÚM. DE DIBUJO

AD-101

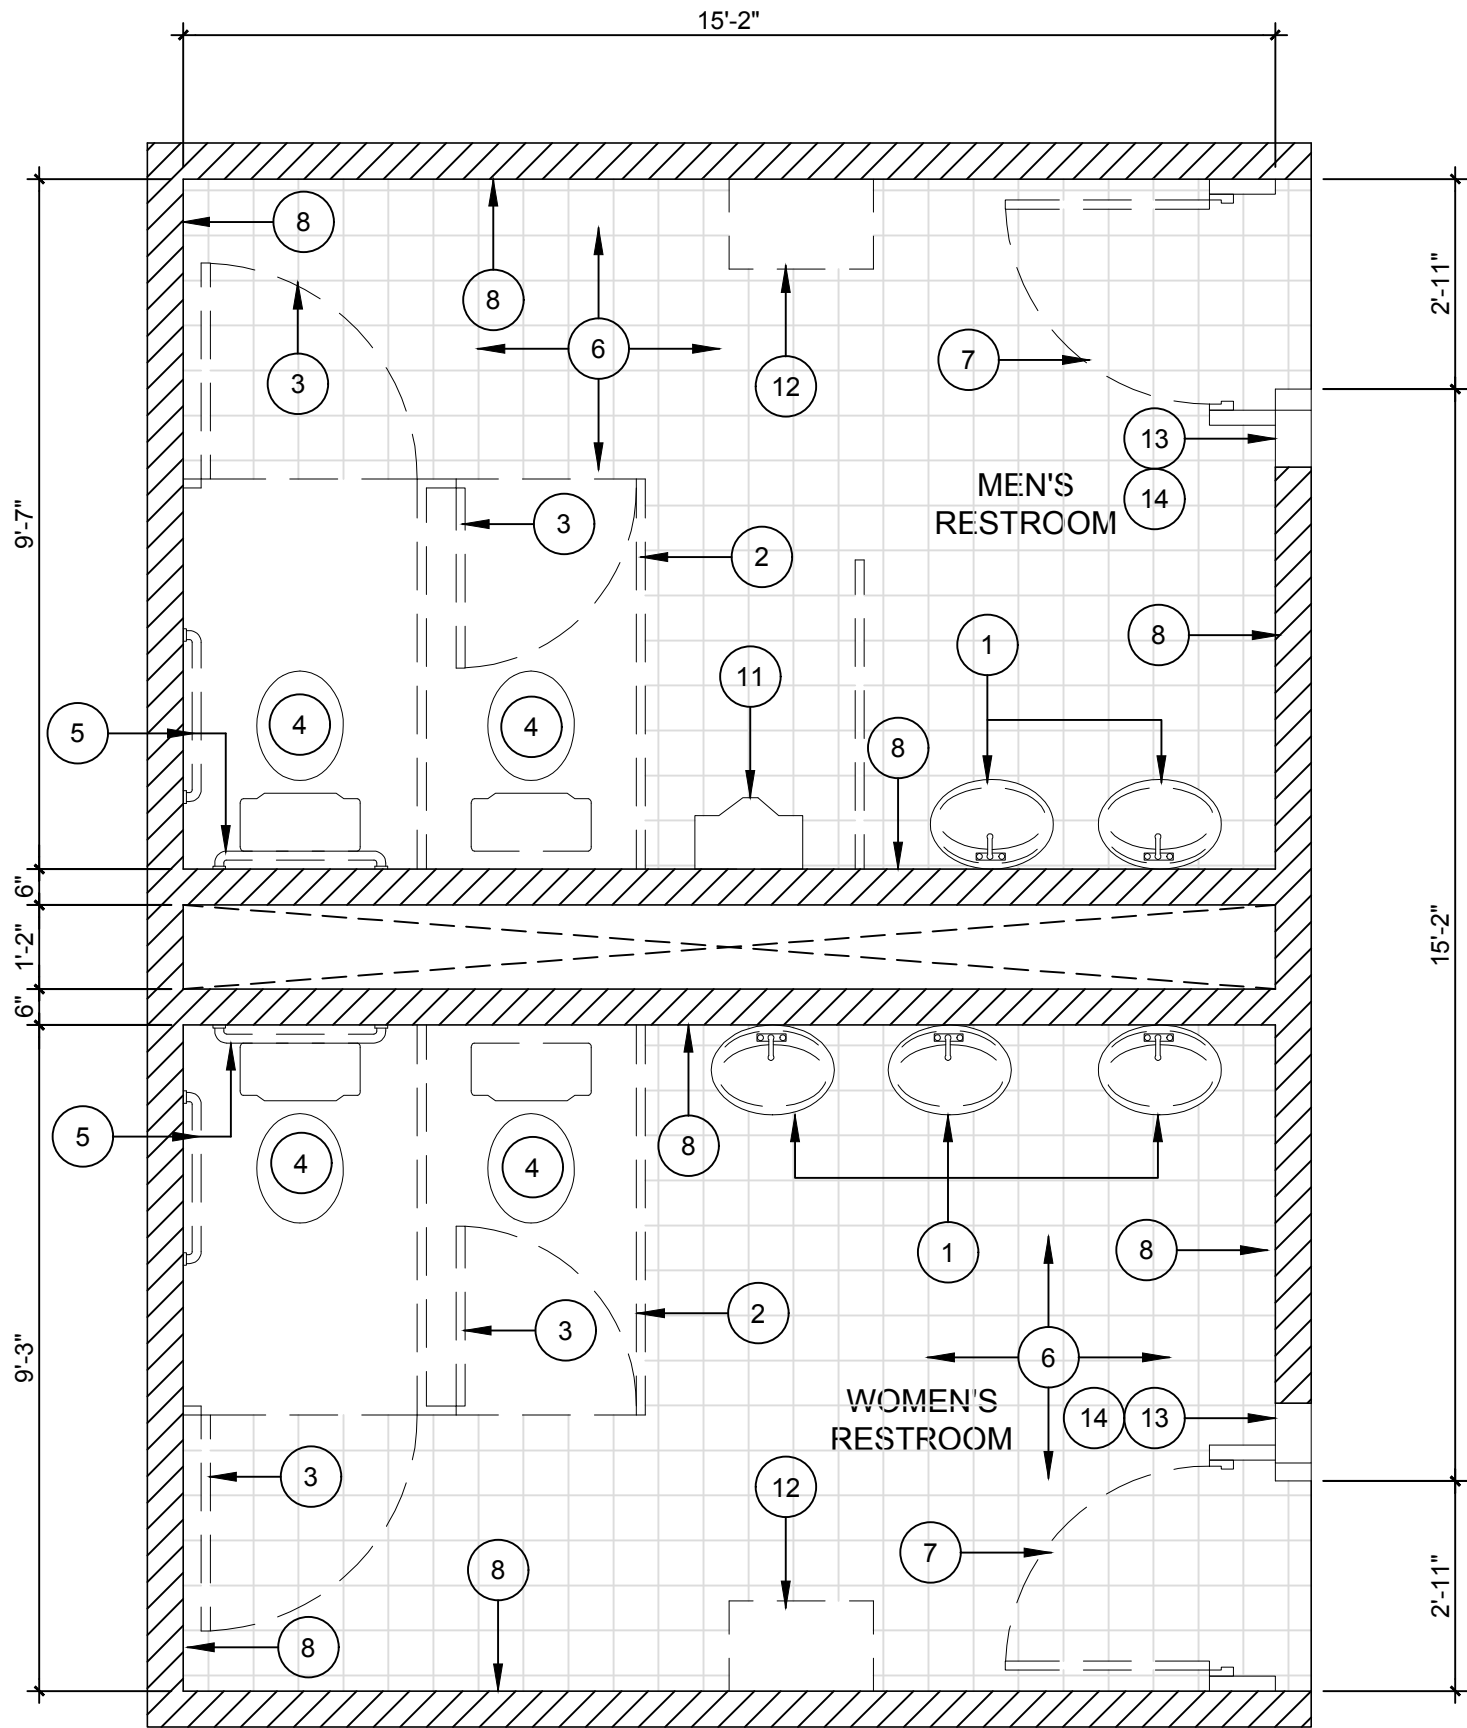


RESTROOM 1 - DEMOLITION FLOOR PLAN
1ST, 2ND, 3RD & 4TH FLOOR

SCALE: 3/8"=1'-0"

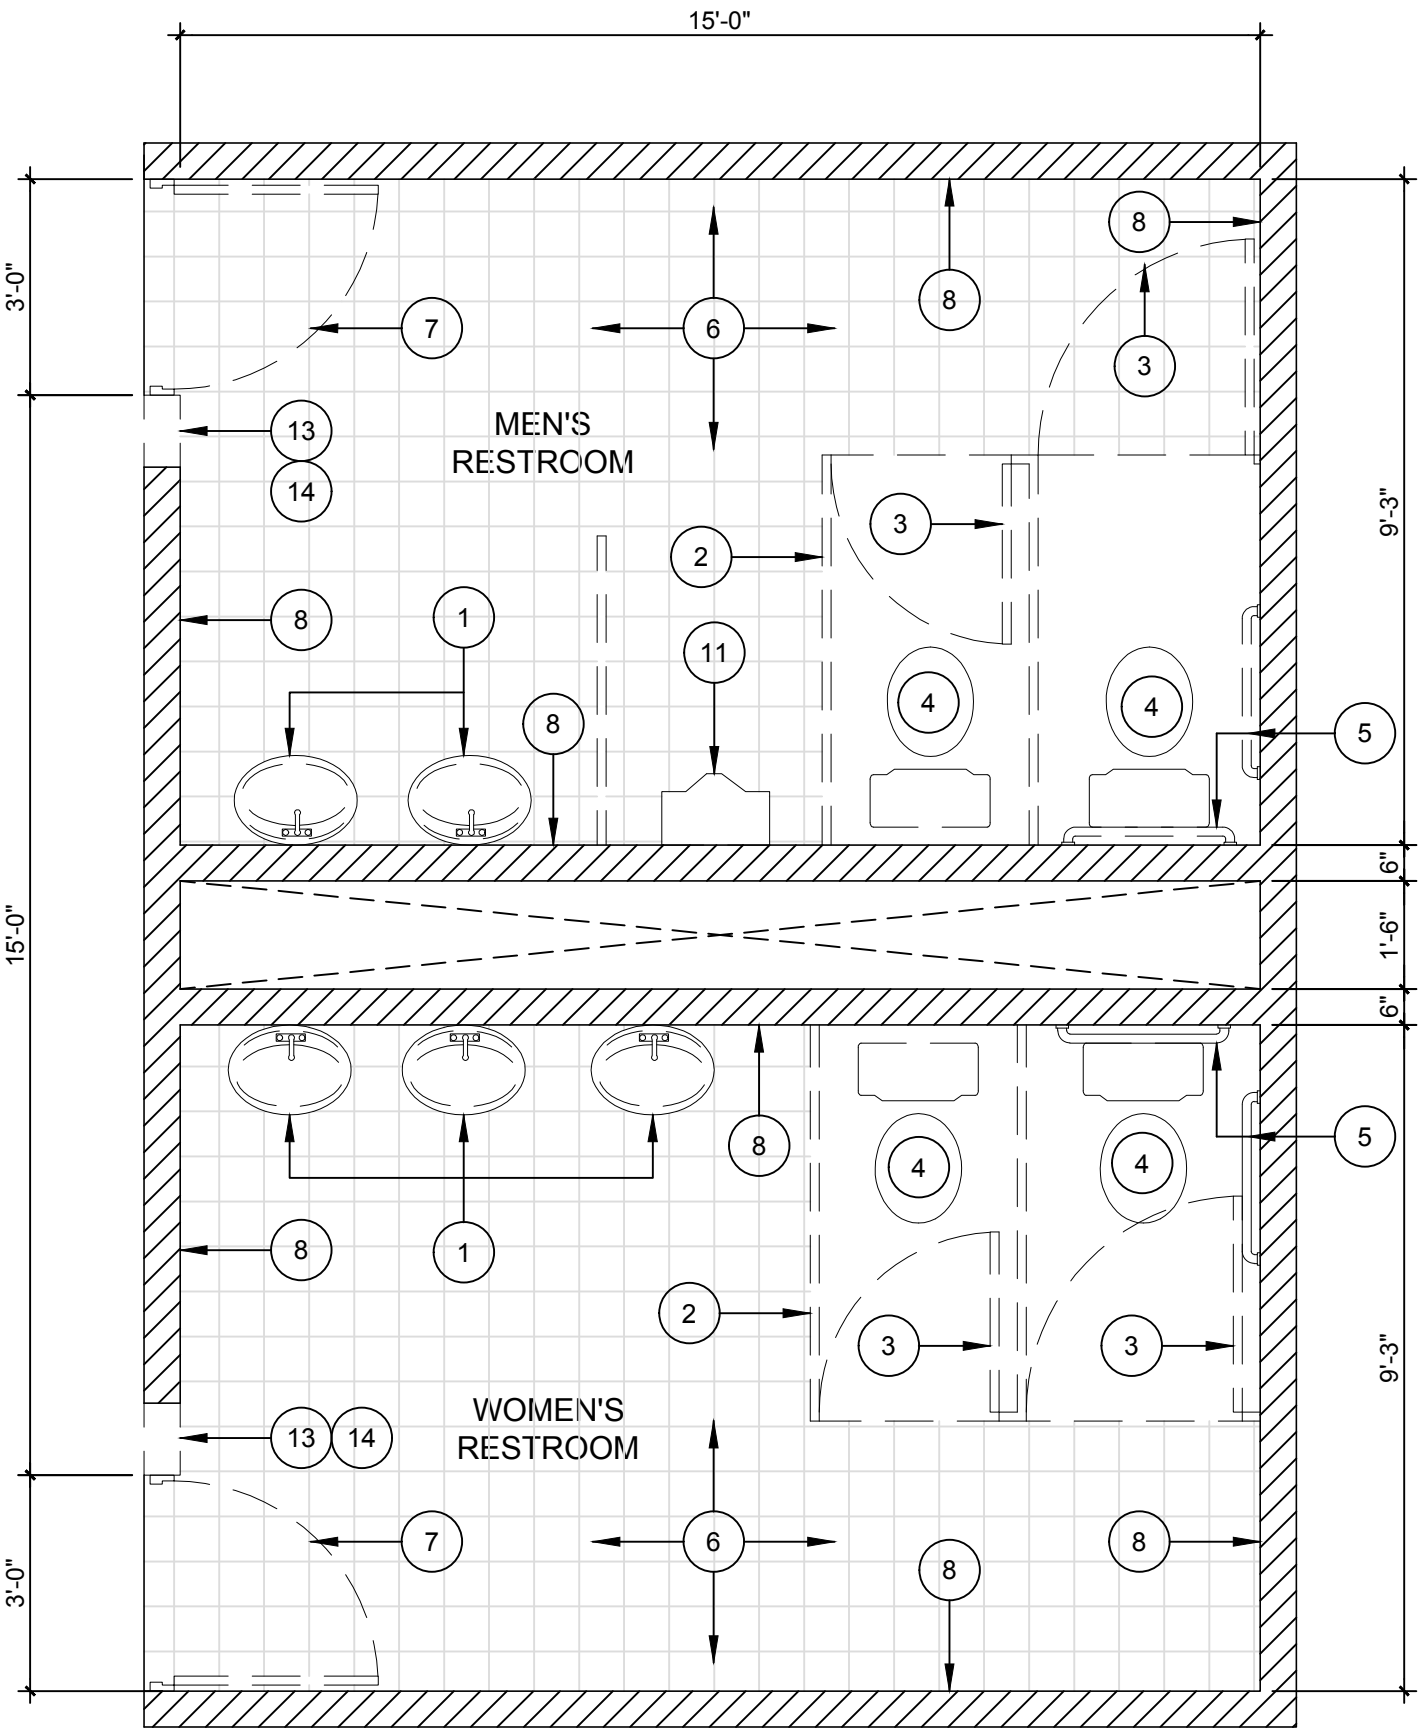

RESTROOM 2 - DEMOLITION FLOOR PLAN
1ST, 2ND, 3RD & 4TH FLOOR

SCALE: 3/8"=1'-0"

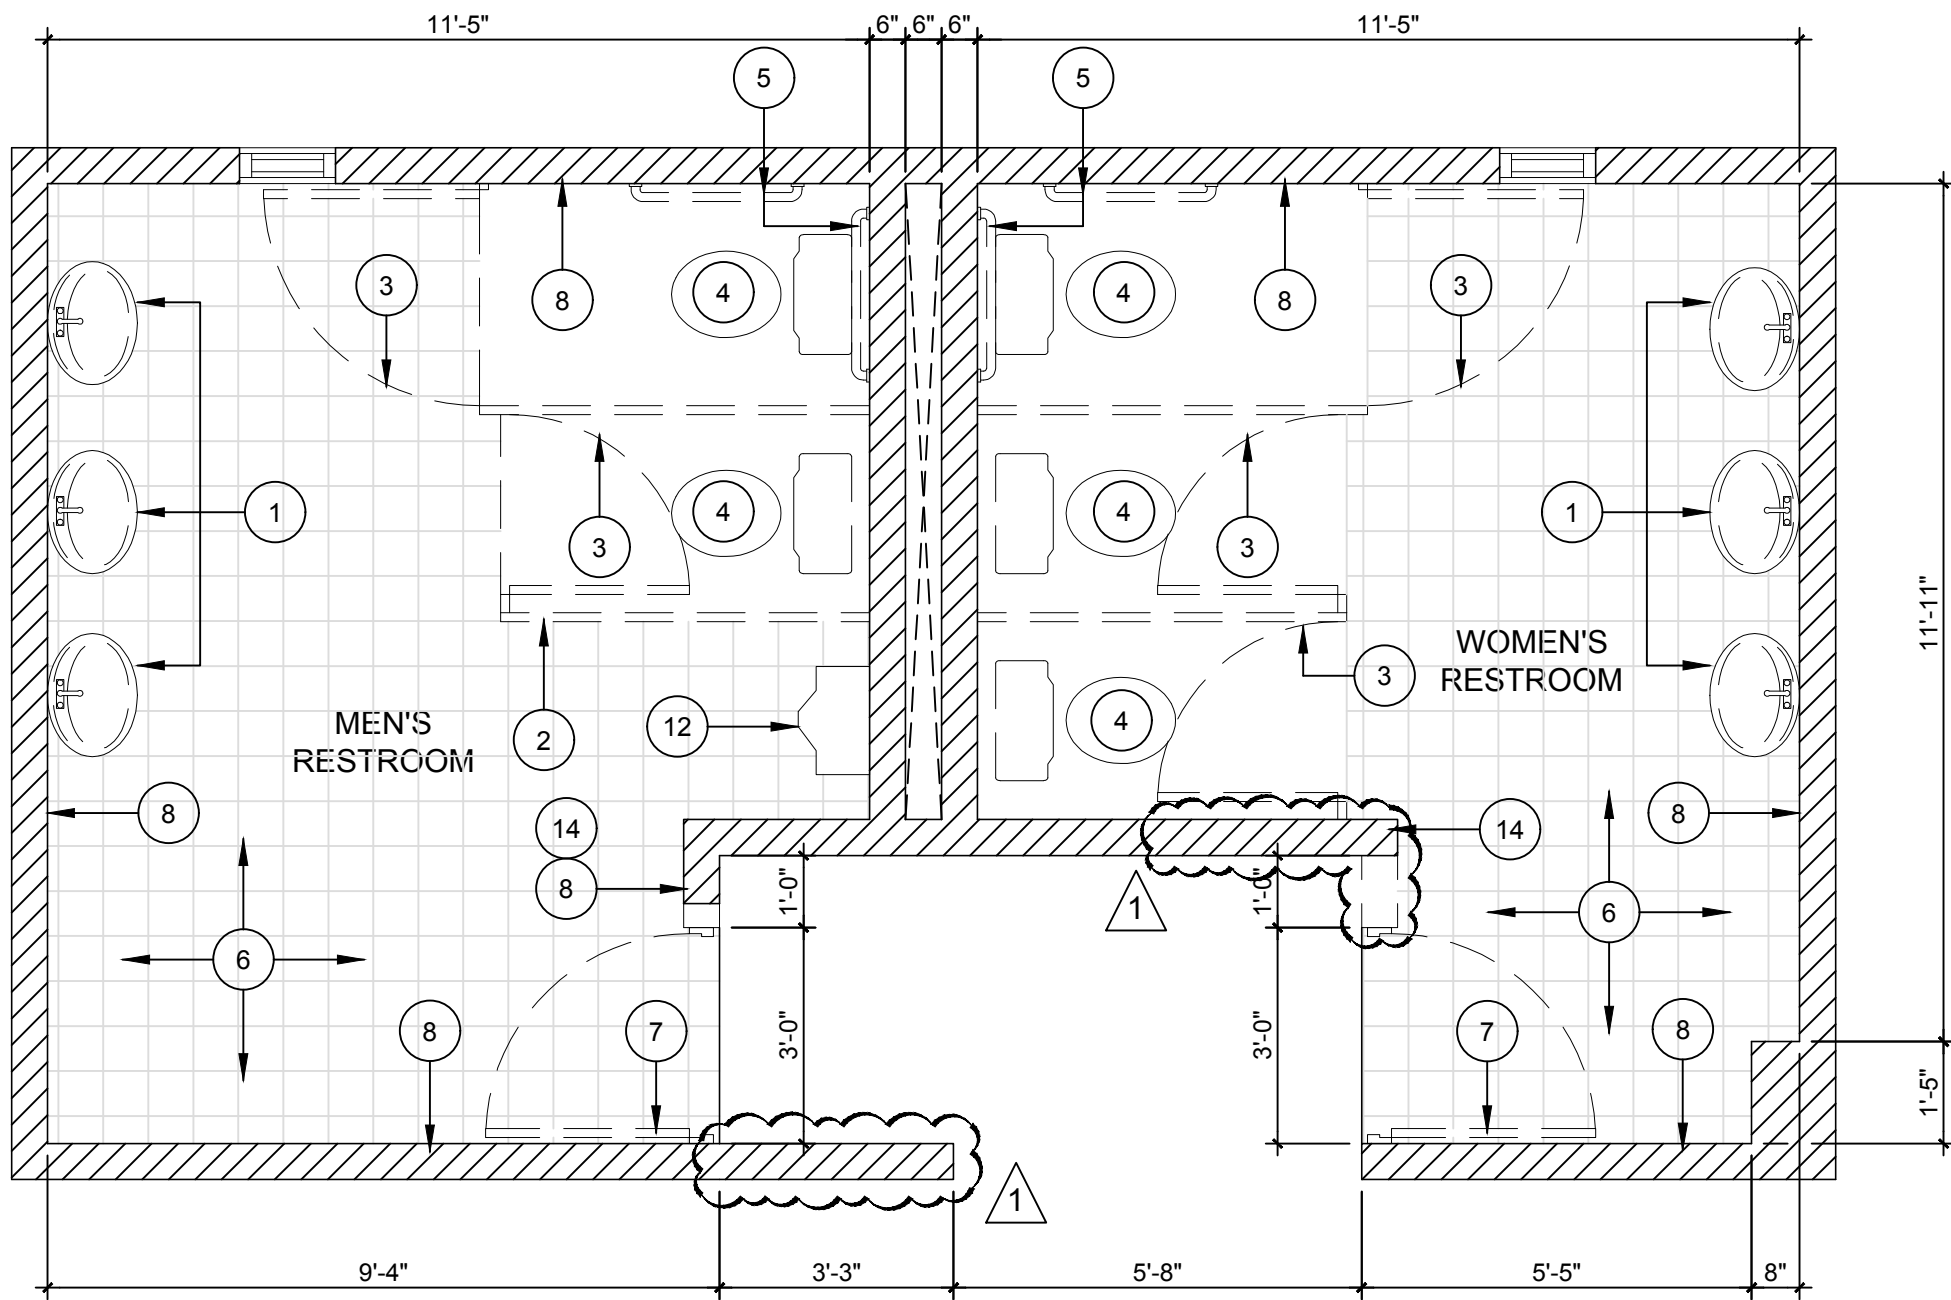


RESTROOM 3 - DEMOLITION FLOOR PLAN
BASEMENT, 1ST, 2ND & 3RD FLOOR


SCALE: 3/8"=1'-0"

DEMOLITION KEYNOTES:


1. WALL SINKS TO BE DEMOLISHED, CONTRACTOR SHALL RELOCATE ROUGH-IN AS NECESSARY, REFER TO AI-400 SERIES FOR LOCATION OF NEW SINKS.
2. TOILET PARTITION TO BE DEMOLISHED.
3. TOILET PARTITION DOOR TO BE DEMOLISHED.
4. WALL HUNG TOILET TO BE DEMOLISHED, CONTRACTOR SHALL RELOCATE ROUGH-IN AS NECESSARY, REFER TO AI-400 SERIES FOR LOCATION OF NEW WALL HUNG TOILET.
5. GRAB BAR TO BE DEMOLISHED, REFER TO AI-400 SERIES FOR LOCATION OF NEW GRAB BARS.
6. ALL FLOOR TILE TO BE DEMOLISHED, PROVIDE CONCRETE TOPPING AS NECESSARY OR APPROVED SELF LEVELING TO INSURE PROPER INSTALLATION OF NEW FLOOR TILE.
7. RESTROOM ENTRY DOOR AND FRAME TO BE DEMOLISHED.
8. ALL WALL TILE TO BE DEMOLISHED, REFER TO AI-105 FOR NEW WALL FINISH.
9. CEILING TILE AND LAMPS TO BE DEMOLISHED, REFER TO AI-105 FOR NEW ACOUSTIC TILE AND PROPOSED LAMP LOCATIONS.
10. REMOVE ALL EXISTING BATHROOM ACCESSORIES, INCLUDING MIRRORS, PAPER TOWEL DISPENSERS & TOILET TISSUE DISPENSERS/HOLDERS.
11. EXISTING URINAL TO BE DEMOLISHED, REFER TO AI-400 SERIES FOR LOCATION OF NEW URINALS.
12. BABY CHANGING STATION TO BE DEMOLISHED, REFER TO AI-400 SERIES FOR LOCATION OF NEW BABY CHANGING STATION.
13. EXISTING WALL TO BE DEMOLISHED, REFER TO AI-101-104 FOR NEW LAYOUT.
14. EXISTING 20A-125V SINGLE WALL SWITCH TO BE REPLACED BY NEW ONE. SEE ELECTRICAL DRAWING E-101. ALSO, REPLACE EXISTING CONDUIT & FEEDER WITH NEW ONE CONSISTING OF 3C#12 THHN IN 3/4" Ø EMT CONDUIT.

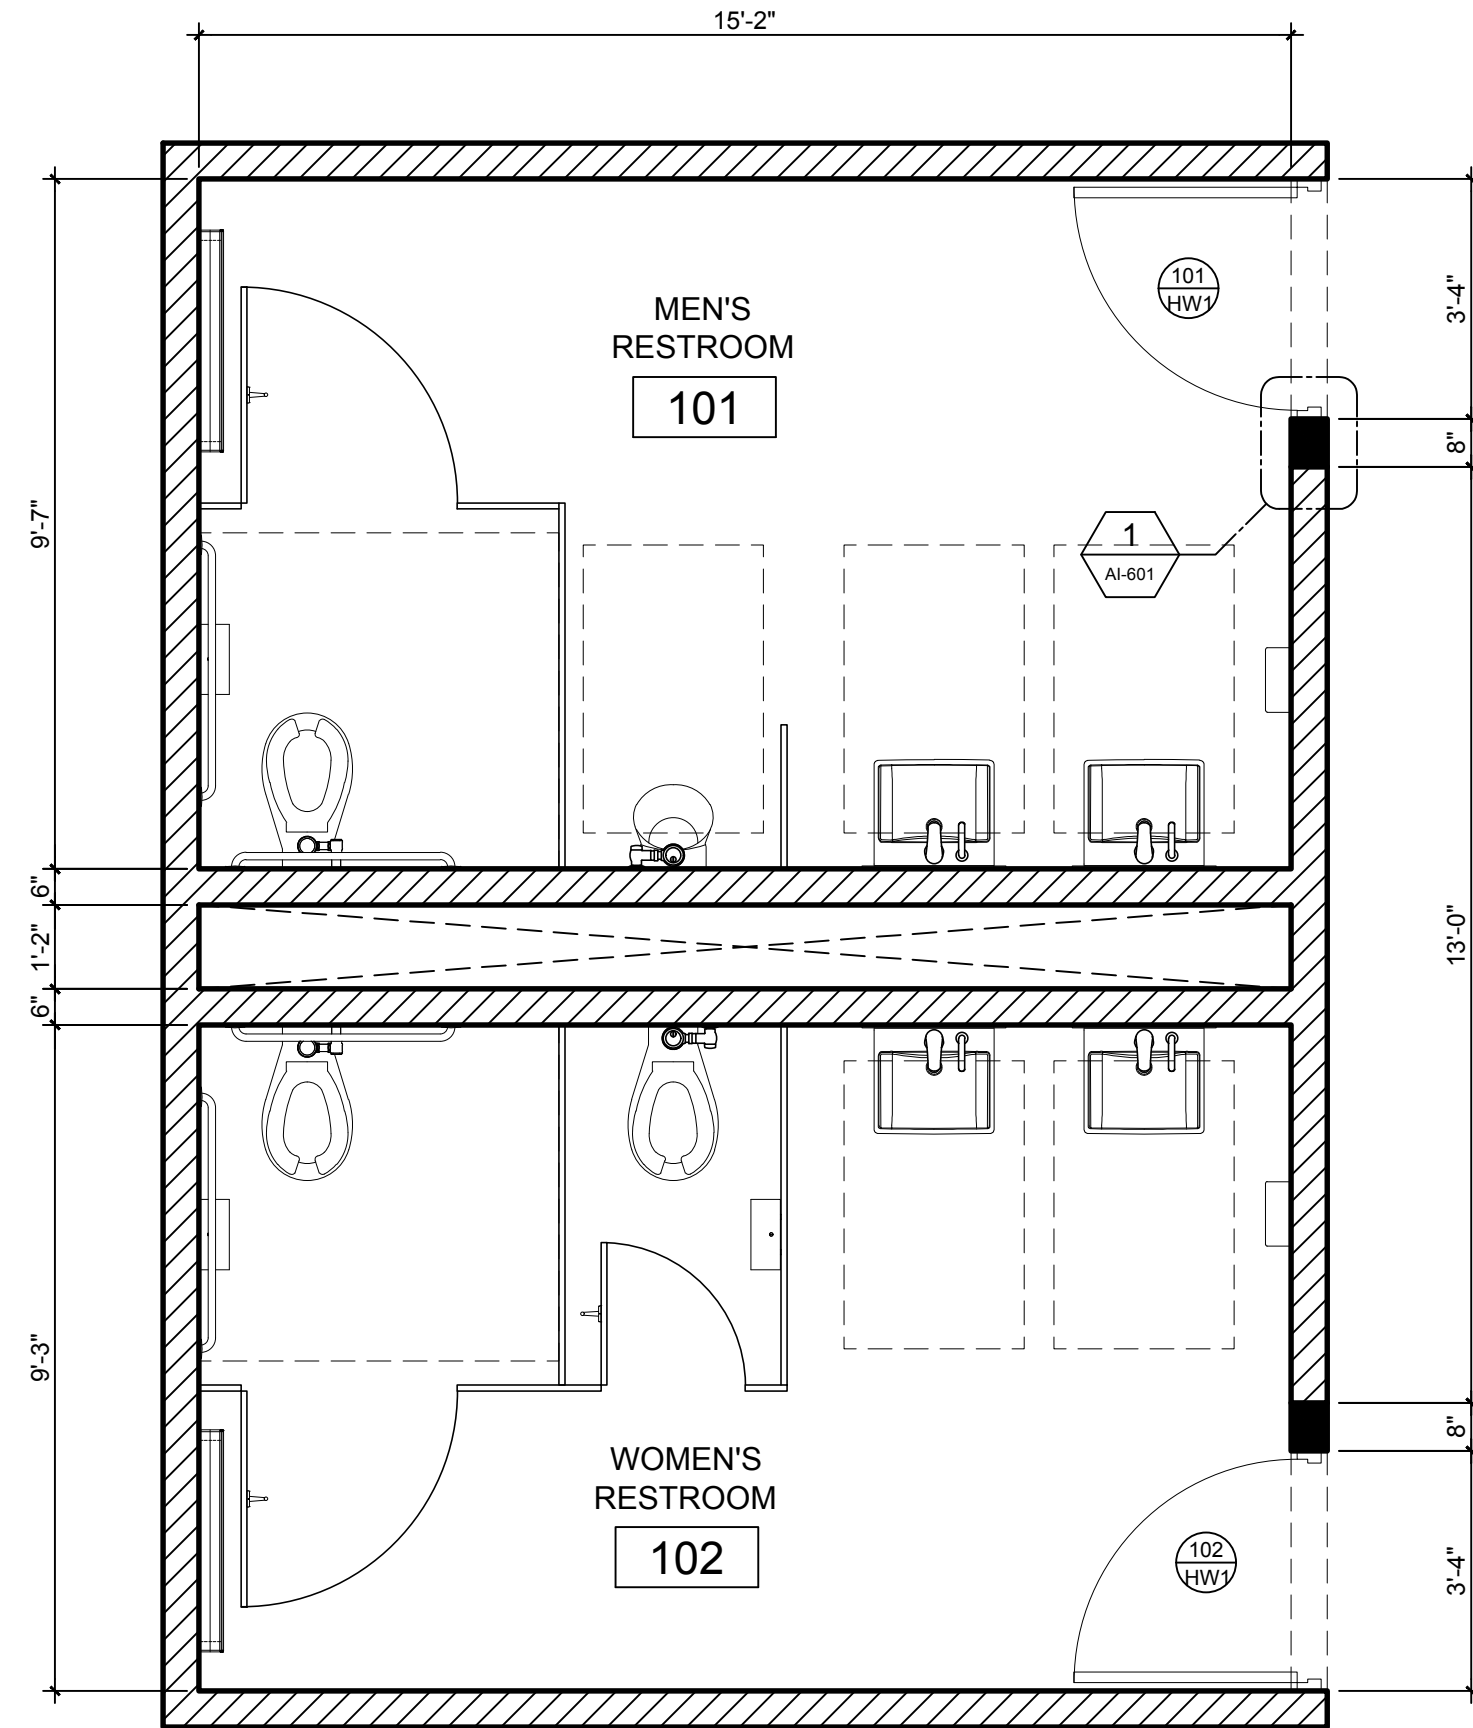


RESTROOM 1 - 1ST FLOOR
SCALE: 3/8"=1'-0"

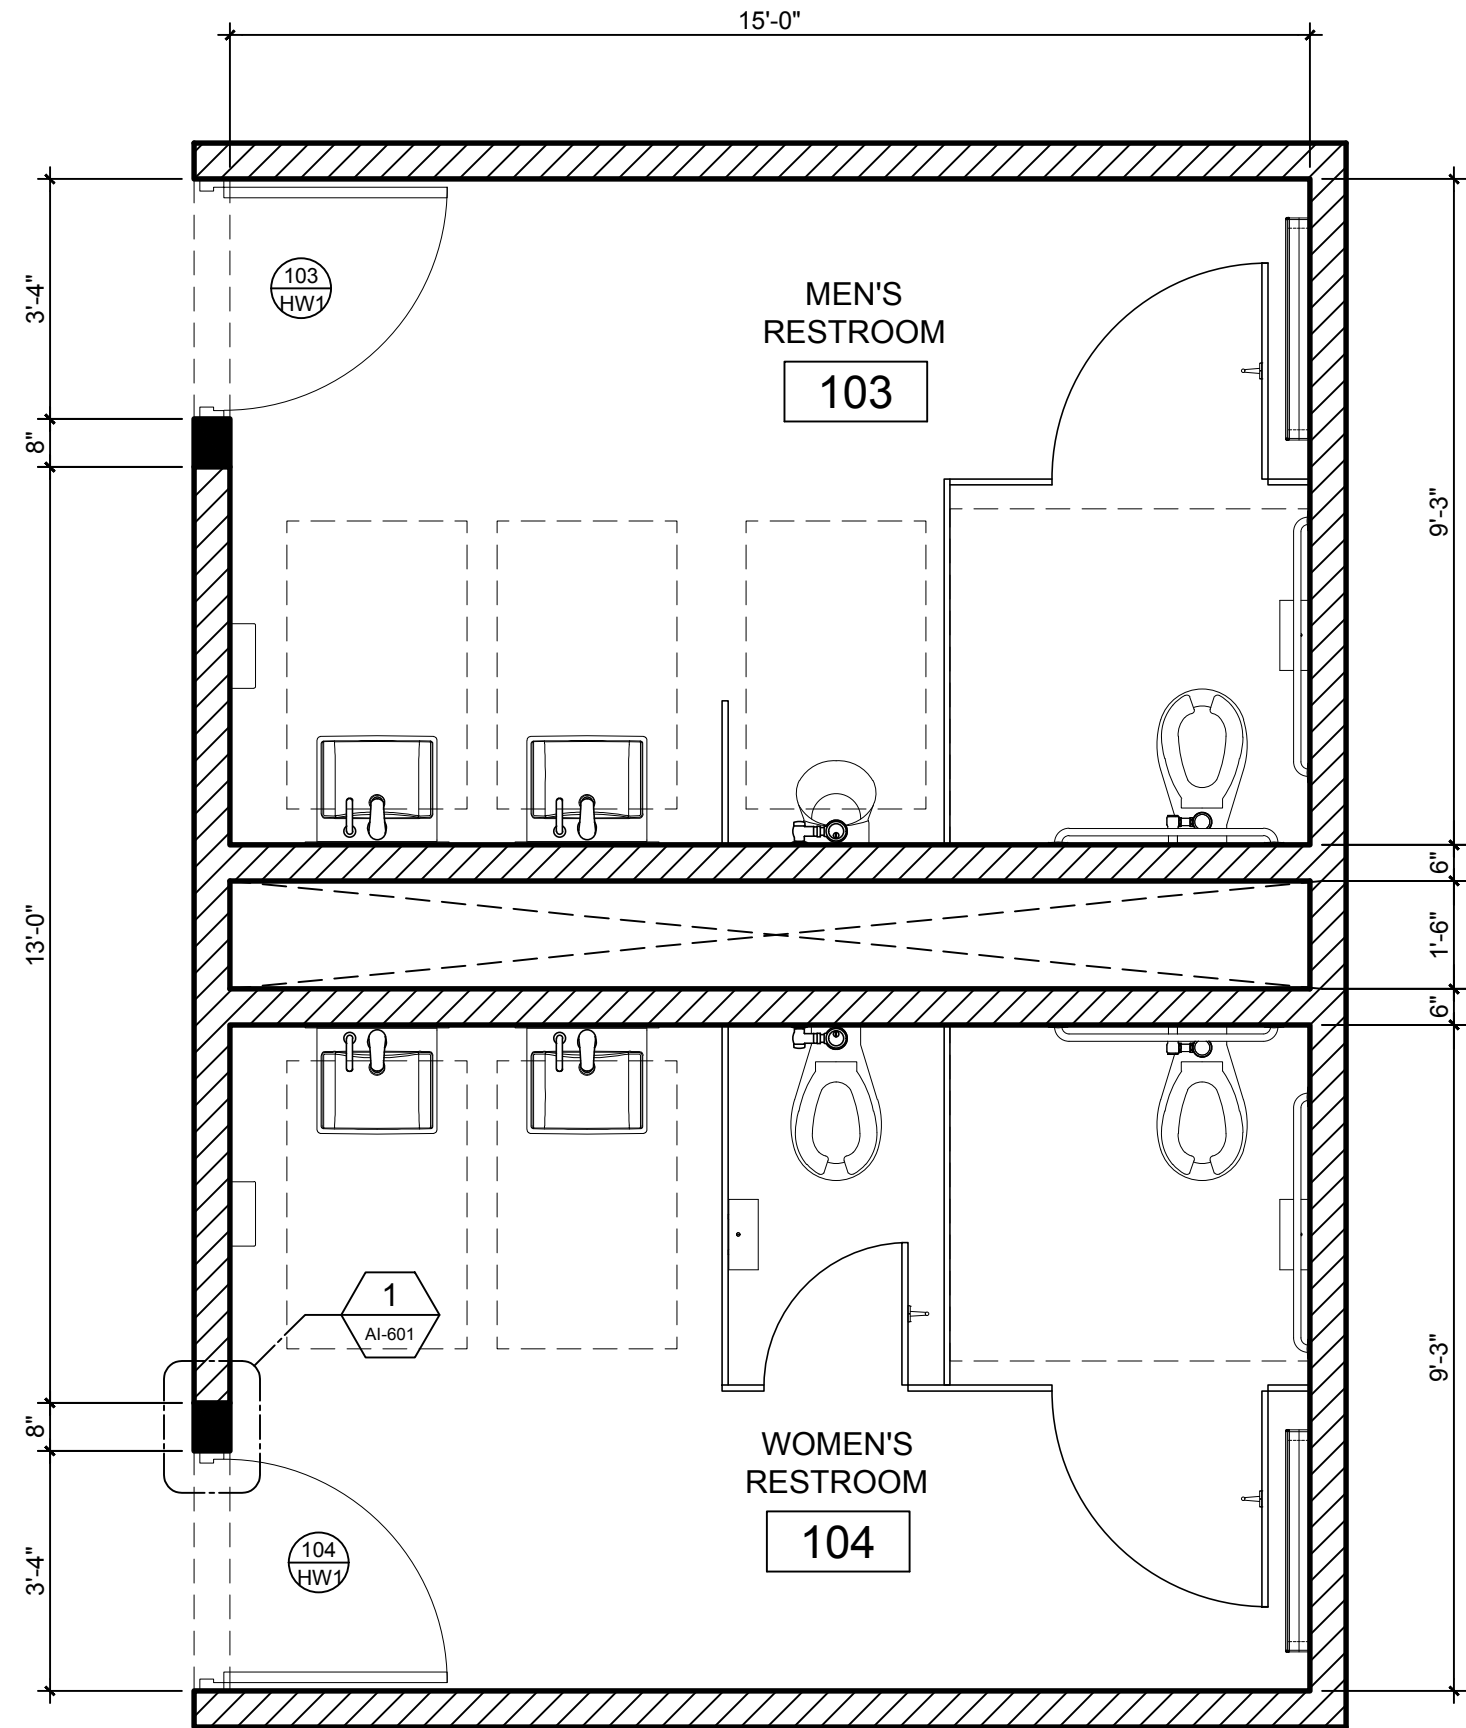


RESTROOM 2 - 1ST FLOOR
SCALE: 3/8"=1'-0"

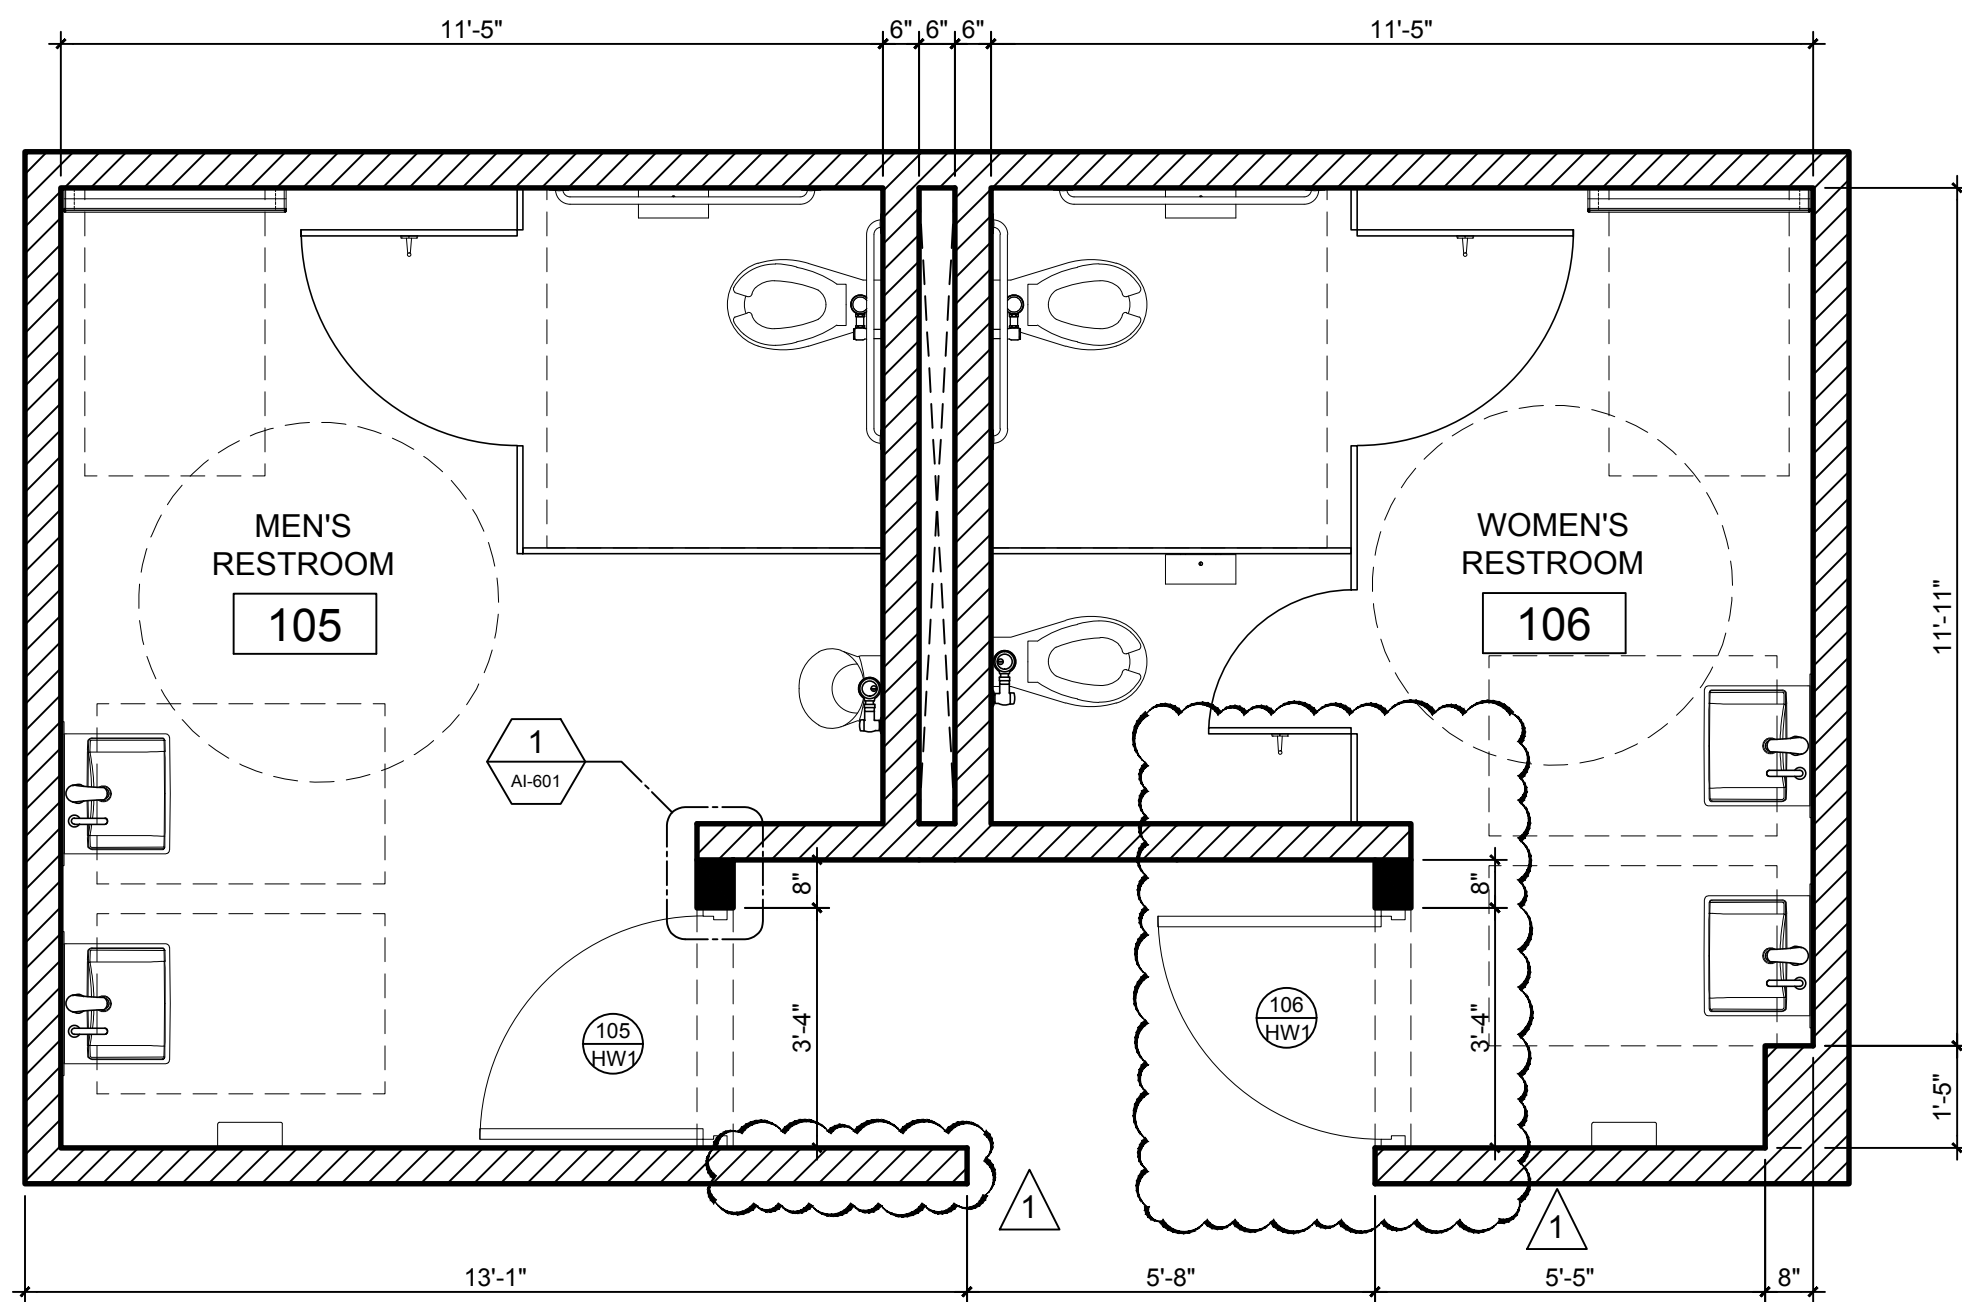

RESTROOM 3 - BASEMENT
SCALE: 3/8"=1'-0"

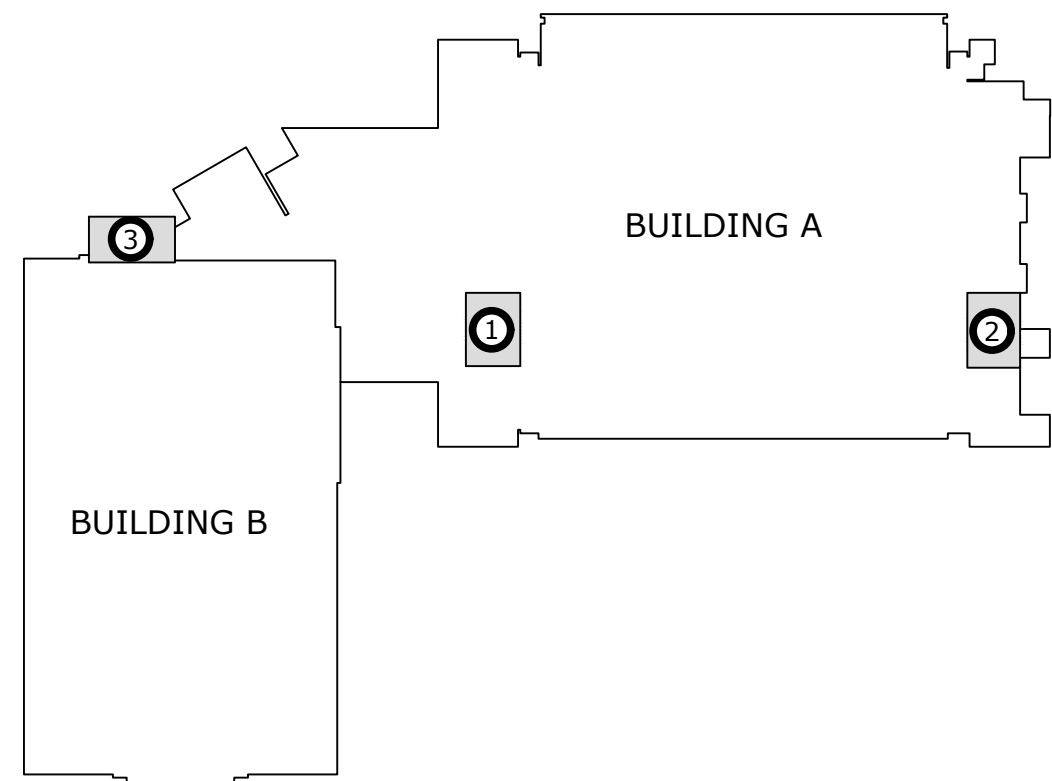

KEYPLAN
NOT TO SCALE

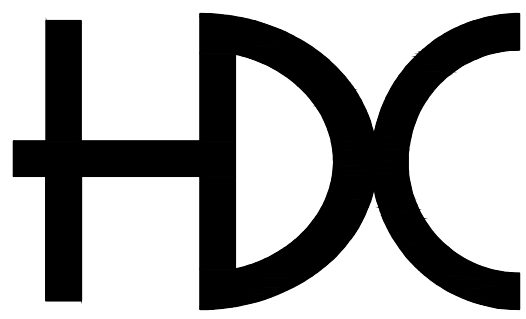

HORACIO DIAZ & ASSOCIATES PSC
CONSULTING ENGINEERS

6 URB. COSTA VERDE
HUMACAO, PUERTO RICO 00791-6036
TEL: (787) 568-1620
E-MAIL: horacio@hdcpr.com



STAMP | SELLO

FIRST LEVEL
PROPOSED
RESTROOM
FLOOR PLANS

TITLE SHEET | TITULO DE LA HOJA

HDC BID SET
NOT FOR CONSTRUCTION
APR 24, 2023

BO. TRUJILLO
BAJO, CARR.
PR-3 KM. 12.1
CAROLINA, PR

CENTRO
JUDICIAL DE
CAROLINA
PODER
JUDICIAL DE
PUERTO RICO

PROJECT NAME | NOMBRE DEL PROYECTO


THIS DRAWING AND ITS CONTENTS BELONGS TO
HORACIO DIAZ & ASSOCIATES.
THEY SHALL BE USED AS A REFERENCE DOCUMENT AND
WORKING INSTRUMENT ONLY BY AUTHORIZED PERSONNEL.
ANY TOTAL OR PARTIAL REPRODUCTION OR USE OF
THIS DOCUMENT IS STRICTLY PROHIBITED WITHOUT THE
APPROPRIATED WRITTEN CONSENT OF THIS FIRM AND
SHALL BE RETURNED TO THEIR OFFICE IF REQUIRED.

REVISIONS REVISIONES		
NO.	DESCRIPTION	DATE
01	REVISED FLOOR PLAN	APR 24, 2023


DRAWN BY | DIBUJADO POR: H. DIAZ
CHECK BY | COTEJADO POR: H. DIAZ
DESIGN BY | DISEÑADO POR: H. DIAZ
APPROVED BY | APROBADO POR: H. DIAZ
DATE | FECHA: APRIL 24, 2023
SCALE | ESCALA: AS SHOWN

PROJECT NO. | NÚM. PROYECTO: 2022 39
SHEET NO. | NÚM. DE HOJA: 4 OF 15
DRAWING NO. | NÚM. DE DIBUJO:


AI-101

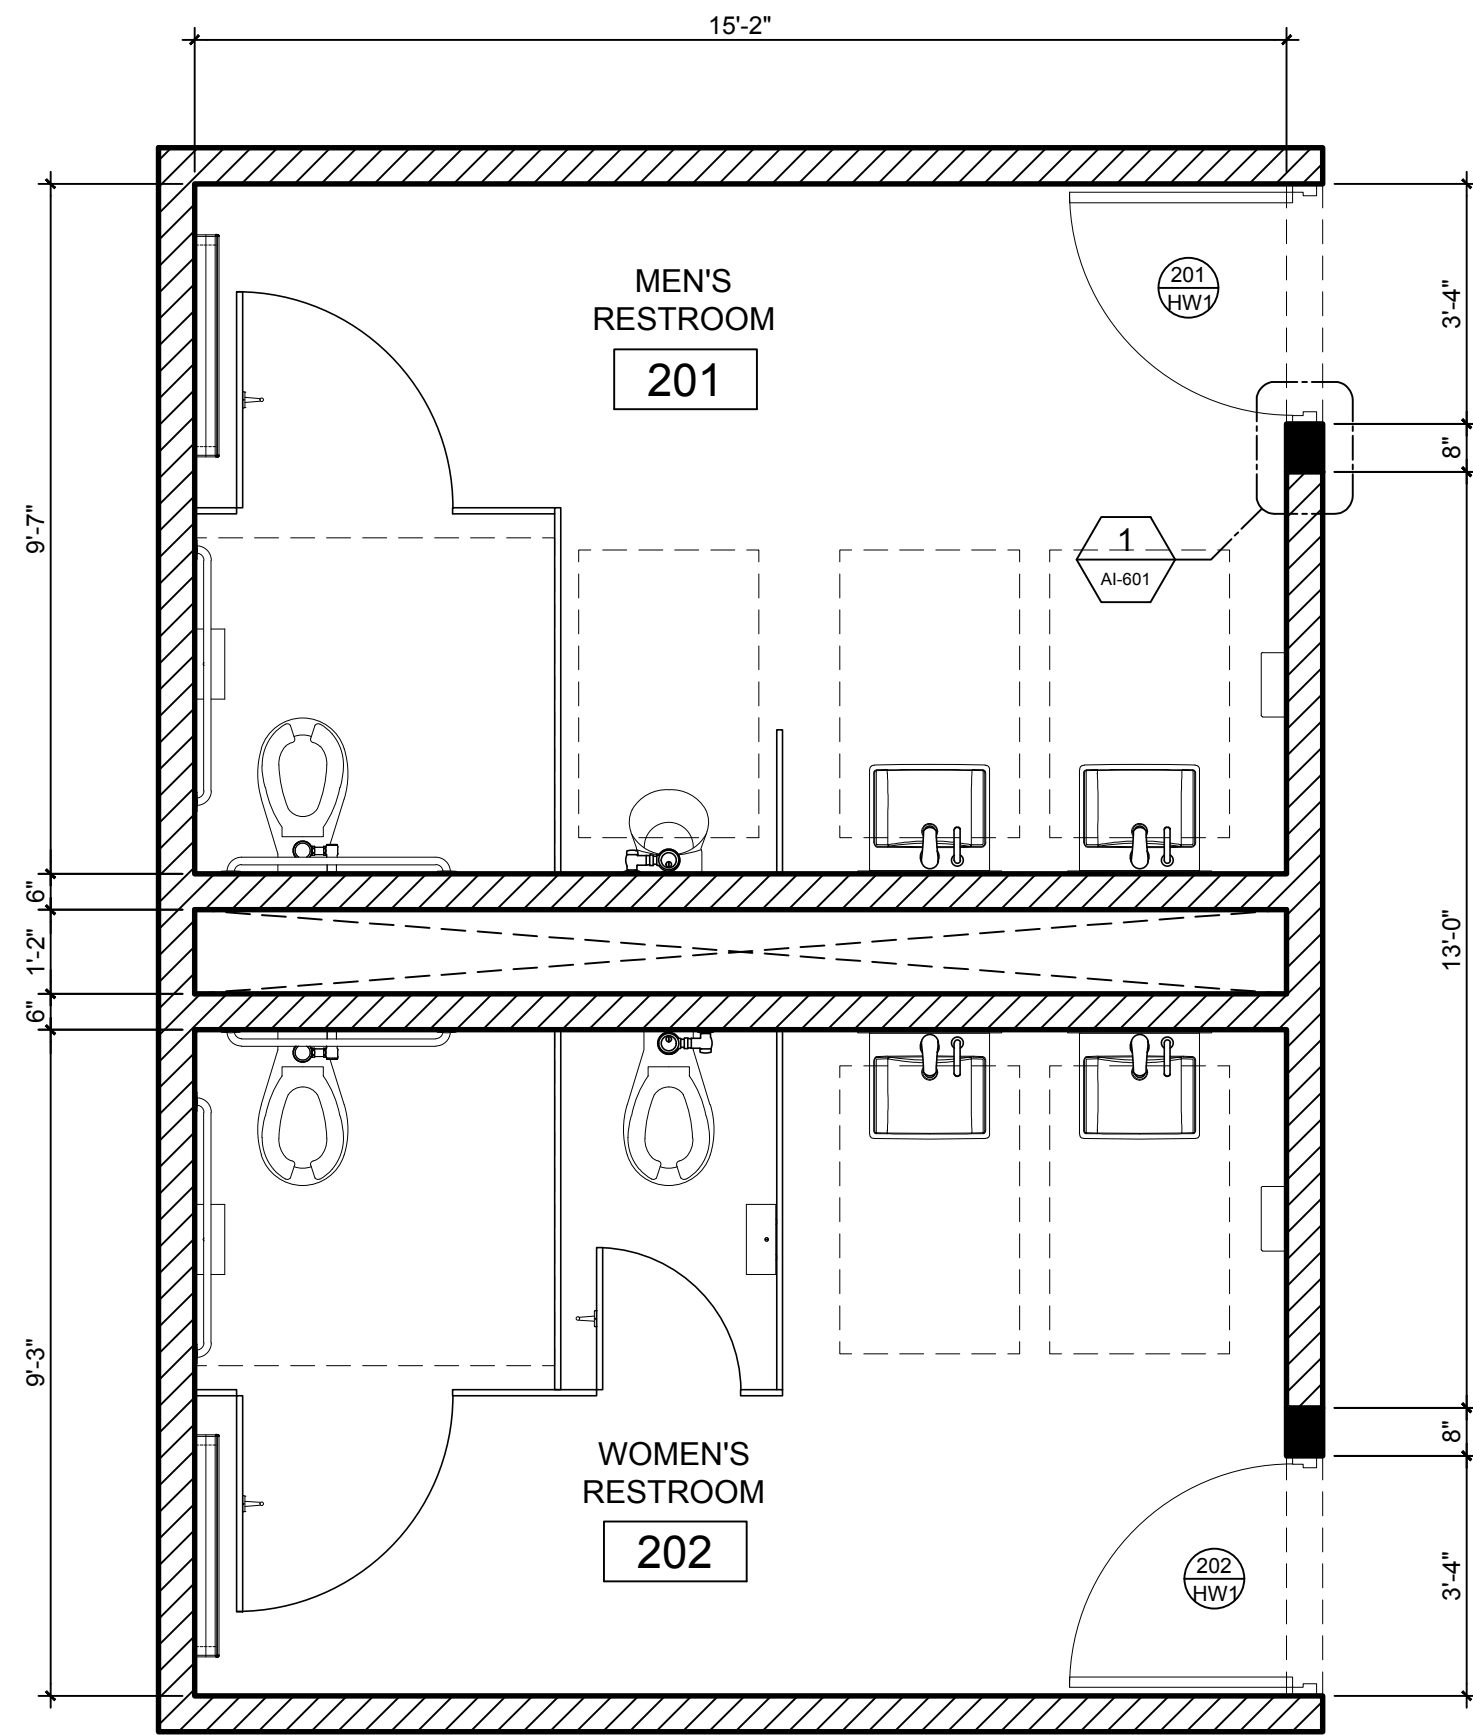


RESTROOM 1 - 2ND FLOOR
SCALE: 3/8"=1'-0"

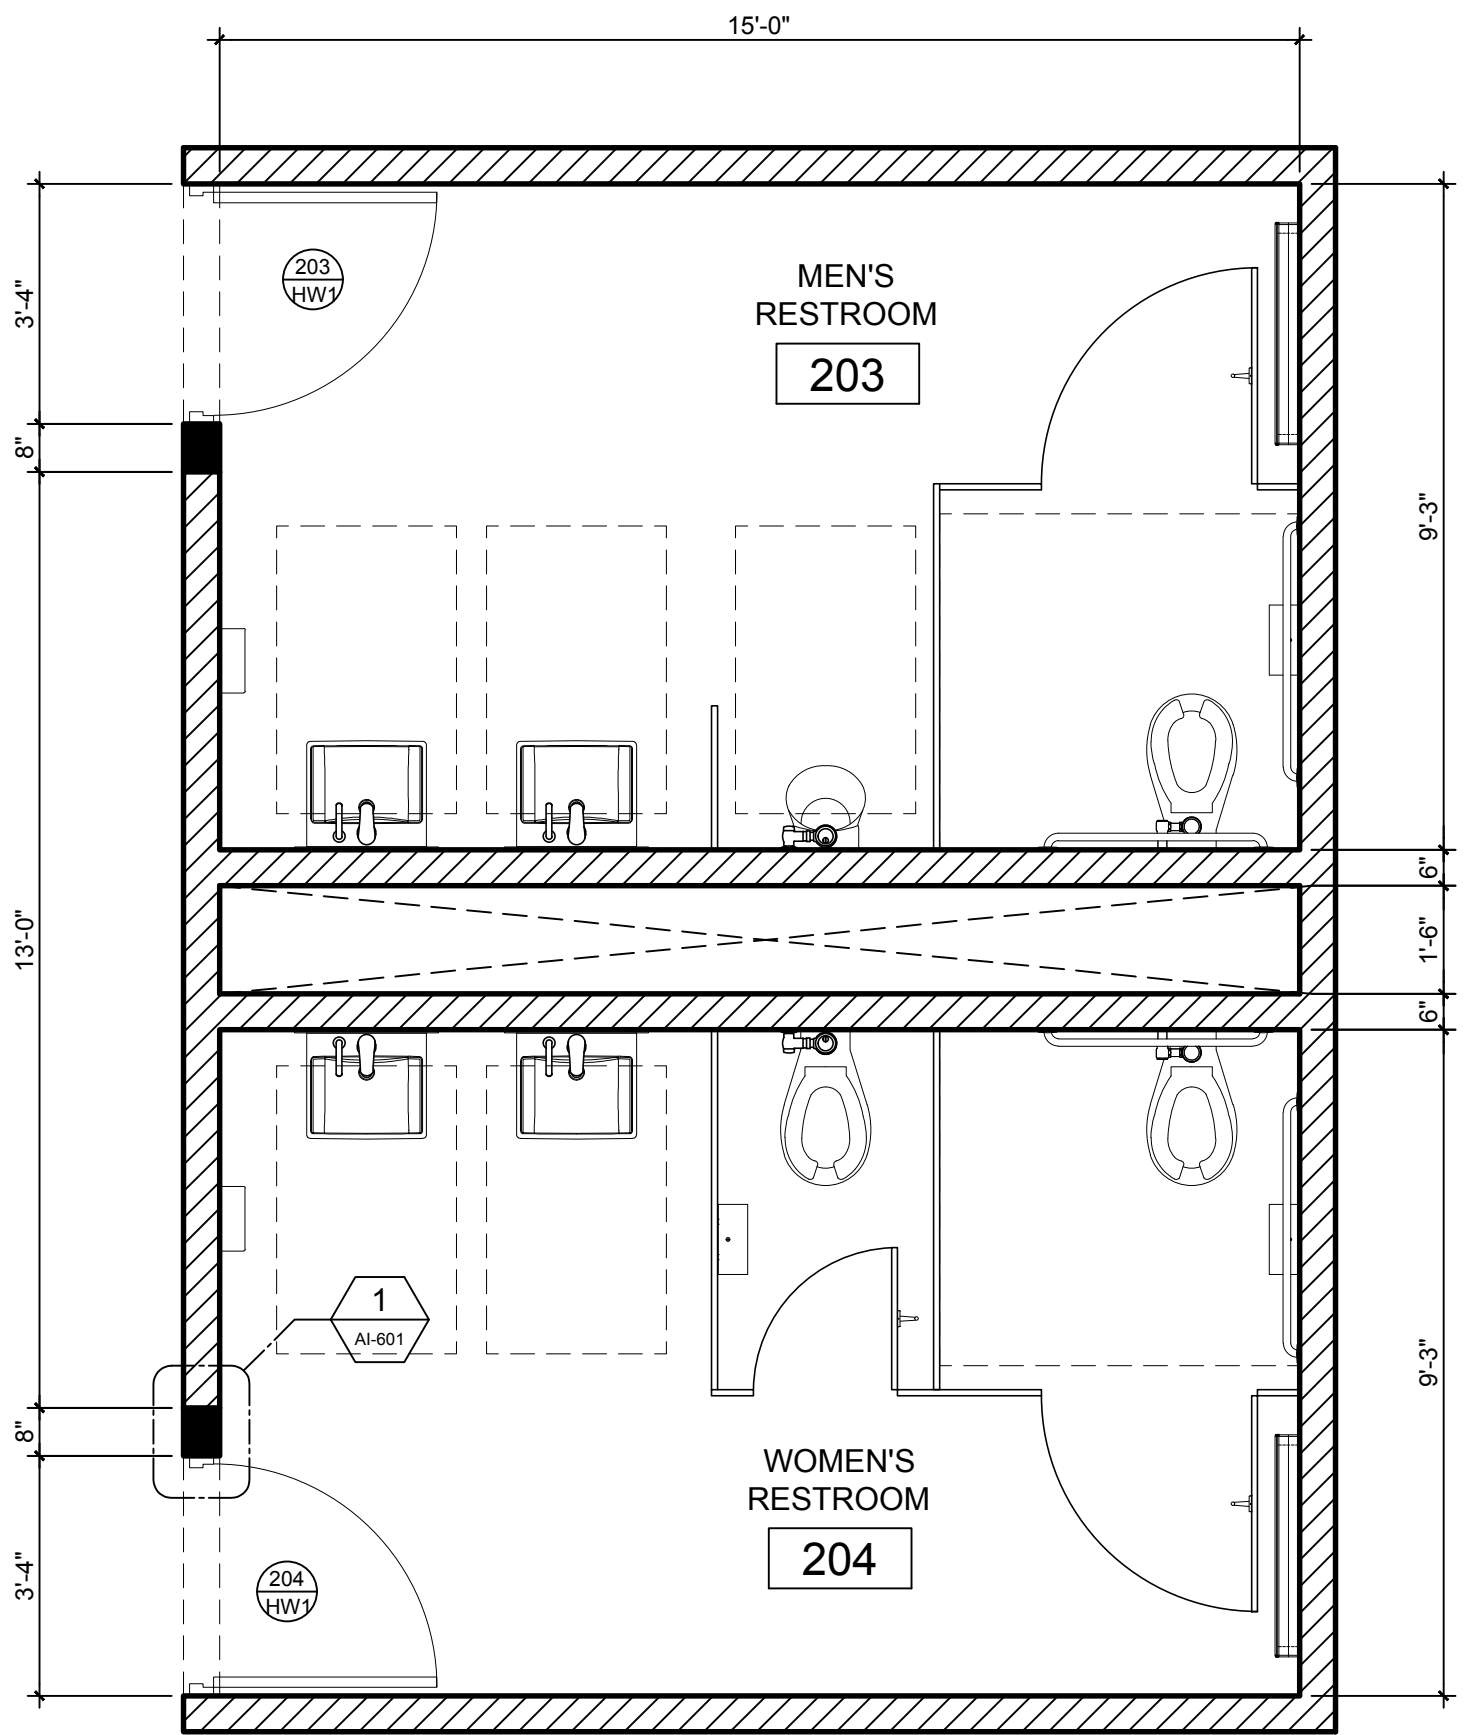


RESTROOM 2 - 2ND FLOOR
SCALE: 3/8"=1'-0"

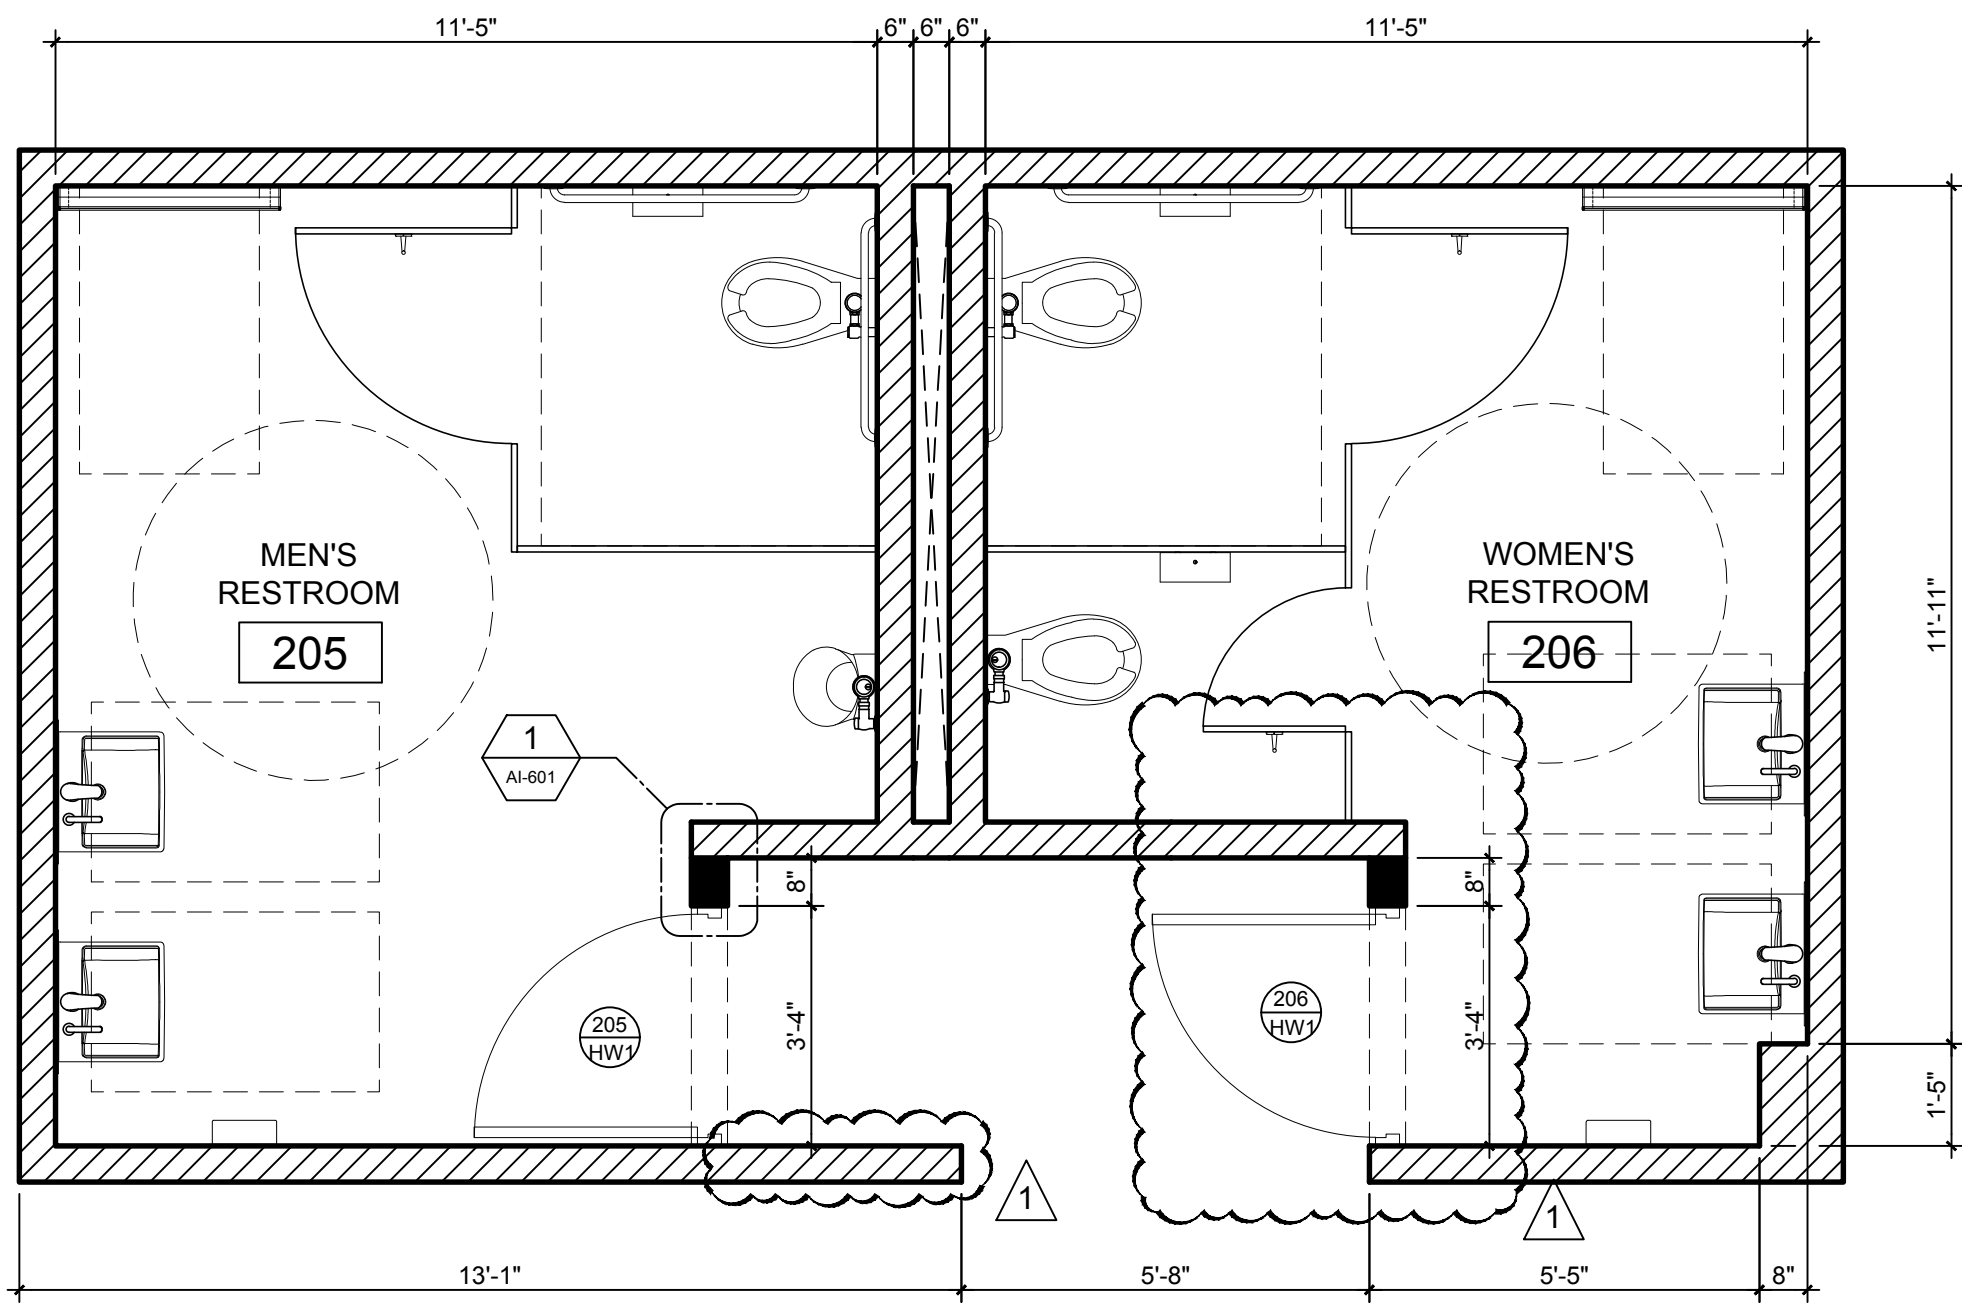

RESTROOM 3 - 1ST FLOOR
SCALE: 3/8"=1'-0"

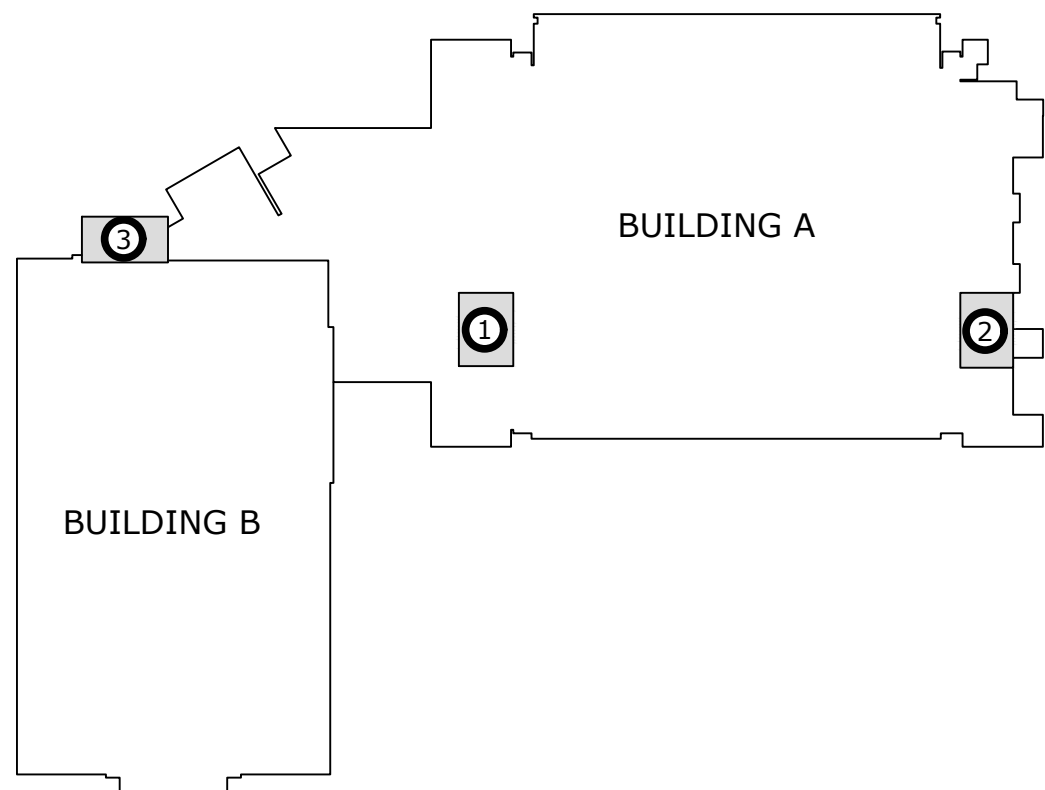

KEYPLAN
NOT TO SCALE

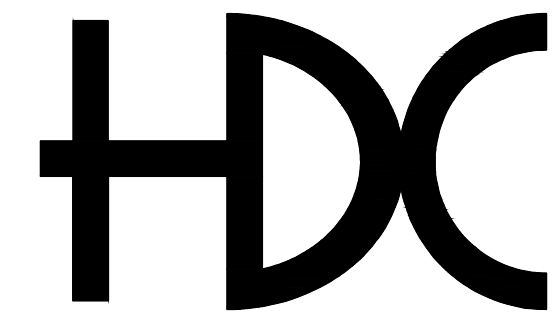

HORACIO DIAZ & ASSOCIATES PSC
CONSULTING ENGINEERS

6 URB. COSTA VERDE
HUMACAO, PUERTO RICO 00791-6036
TEL: (787) 568-1620
E-MAIL: horacio@hdcpr.com



STAMP | SELLO

SECOND LEVEL
PROPOSED
RESTROOM
FLOOR PLANS

TITLE SHEET | TITULO DE LA HOJA

HDC BID SET
NOT FOR CONSTRUCTION
APR 24, 2023

BO. TRUJILLO
BAJO, CARR.
PR-3 KM. 12.1
CAROLINA, PR

CENTRO
JUDICIAL DE
CAROLINA
PODER
JUDICIAL DE
PUERTO RICO

PROJECT NAME | NOMBRE DEL PROYECTO

THIS DRAWING AND ITS CONTENTS BELONGS TO
HORACIO DIAZ & ASSOCIATES.
THEY SHALL BE USED AS A REFERENCE DOCUMENT AND
WORKING INSTRUMENT ONLY BY AUTHORIZED PERSONNEL.
ANY TOTAL OR PARTIAL REPRODUCTION OR USE OF
THIS DOCUMENT IS STRICTLY PROHIBITED WITHOUT THE
APPROPRIATED WRITTEN CONSENT OF THIS FIRM AND
SHALL BE RETURNED TO THEIR OFFICE IF REQUIRED.

REVISIONS | REVISIONES

NO.	DESCRIPTION	DATE
01	REVISED FLOOR PLAN	APR 24, 2023

DRAWN BY | DIBUJADO POR: H. DIAZ
CHECK BY | COTEJADO POR: H. DIAZ
DESIGN BY | DISEÑADO POR: H. DIAZ
APPROVED BY | APROBADO POR: H. DIAZ
DATE | FECHA: APRIL 24, 2023
SCALE | ESCALA: AS SHOWN

PROJECT NO. | NÚM. PROYECTO


2022 39

SHEET NO. | NÚM. DE HOJA


5 OF 15

DRAWING NO. | NÚM. DE DIBUJO


AI-102

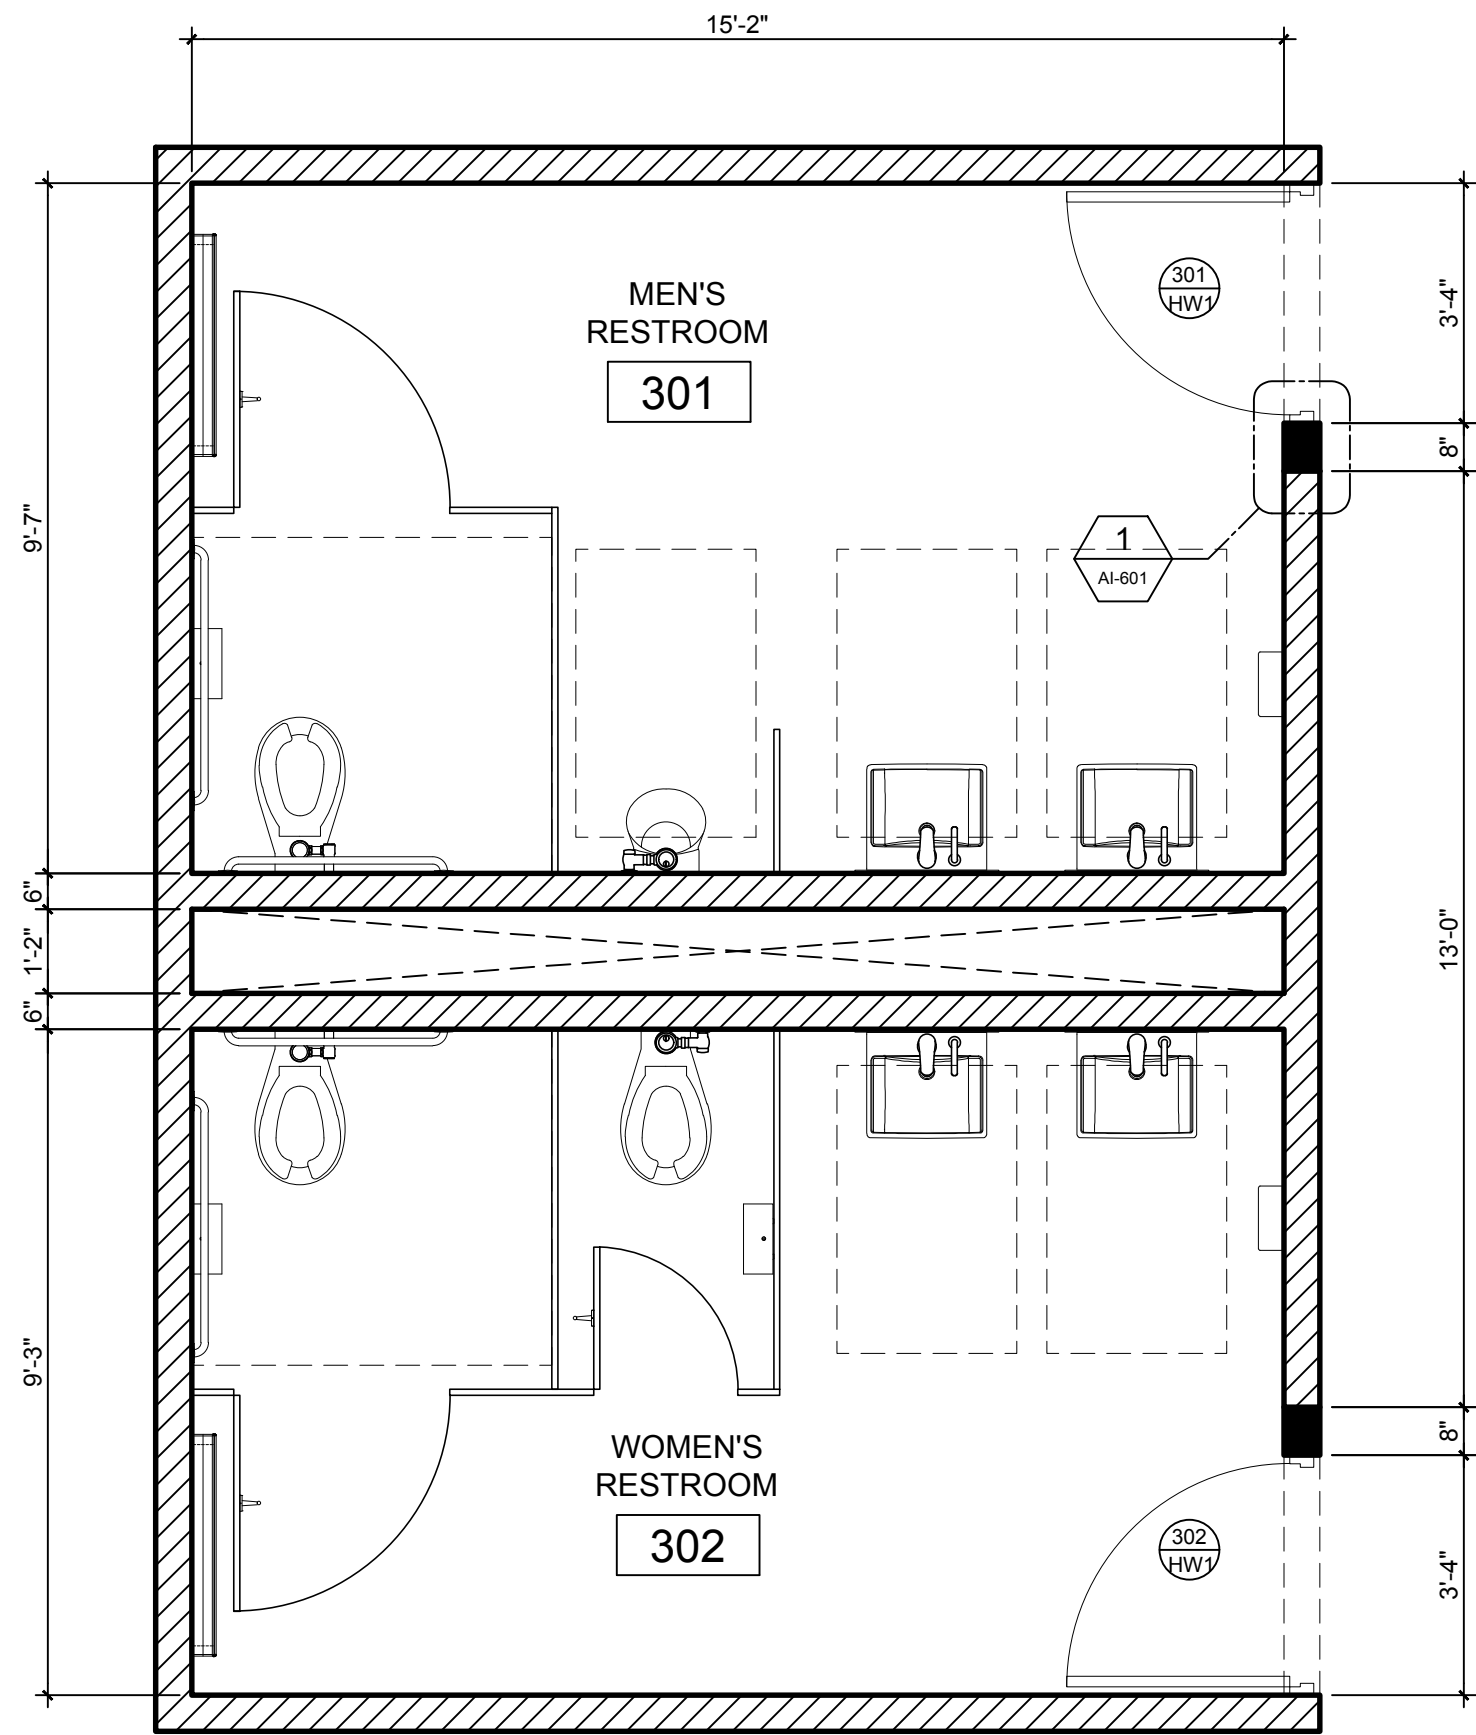


RESTROOM 1 - 3RD FLOOR
SCALE: 3/8"=1'-0"

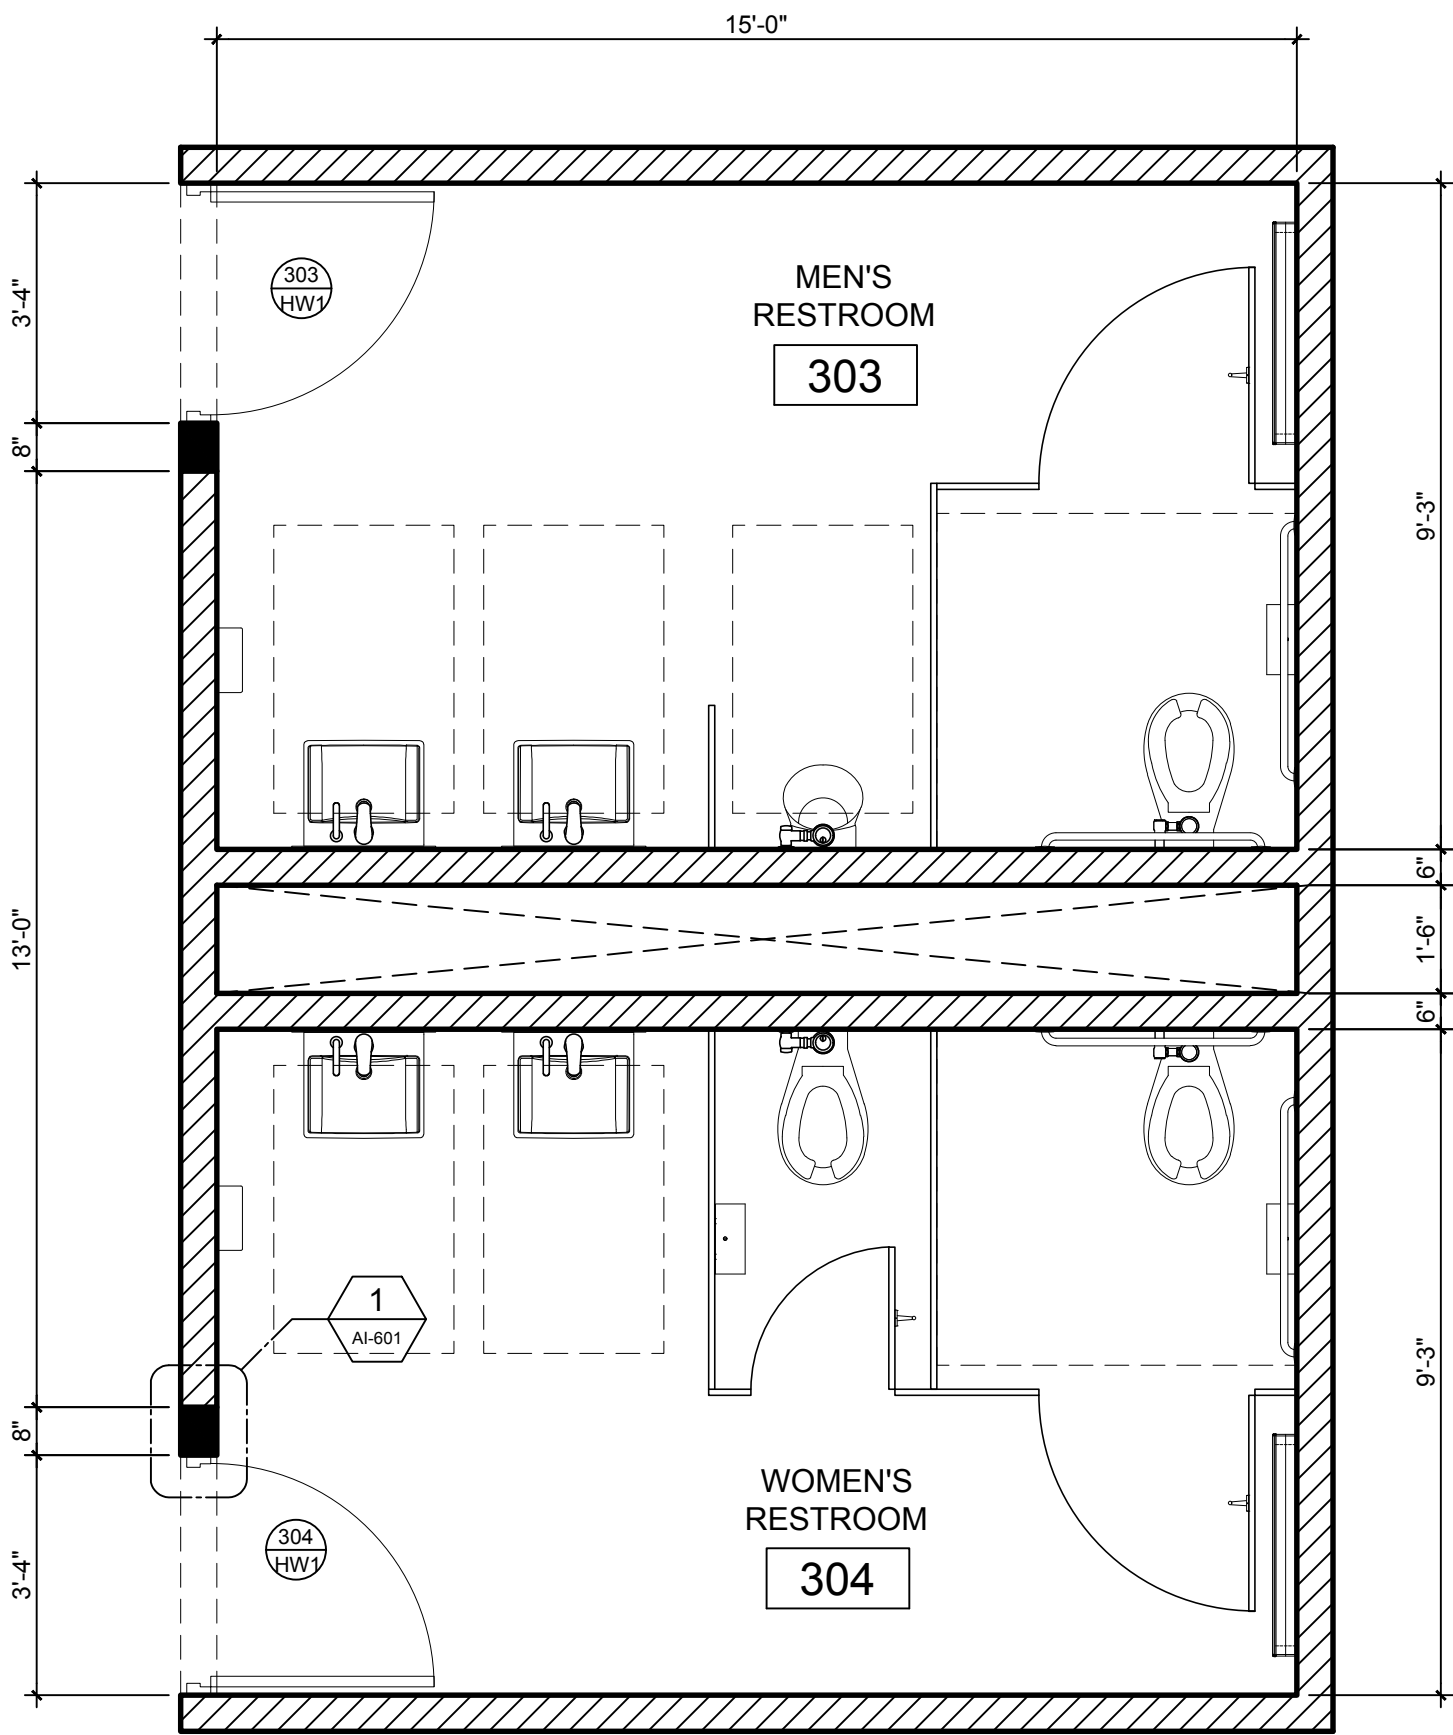


RESTROOM 2 - 3RD FLOOR
SCALE: 3/8"=1'-0"

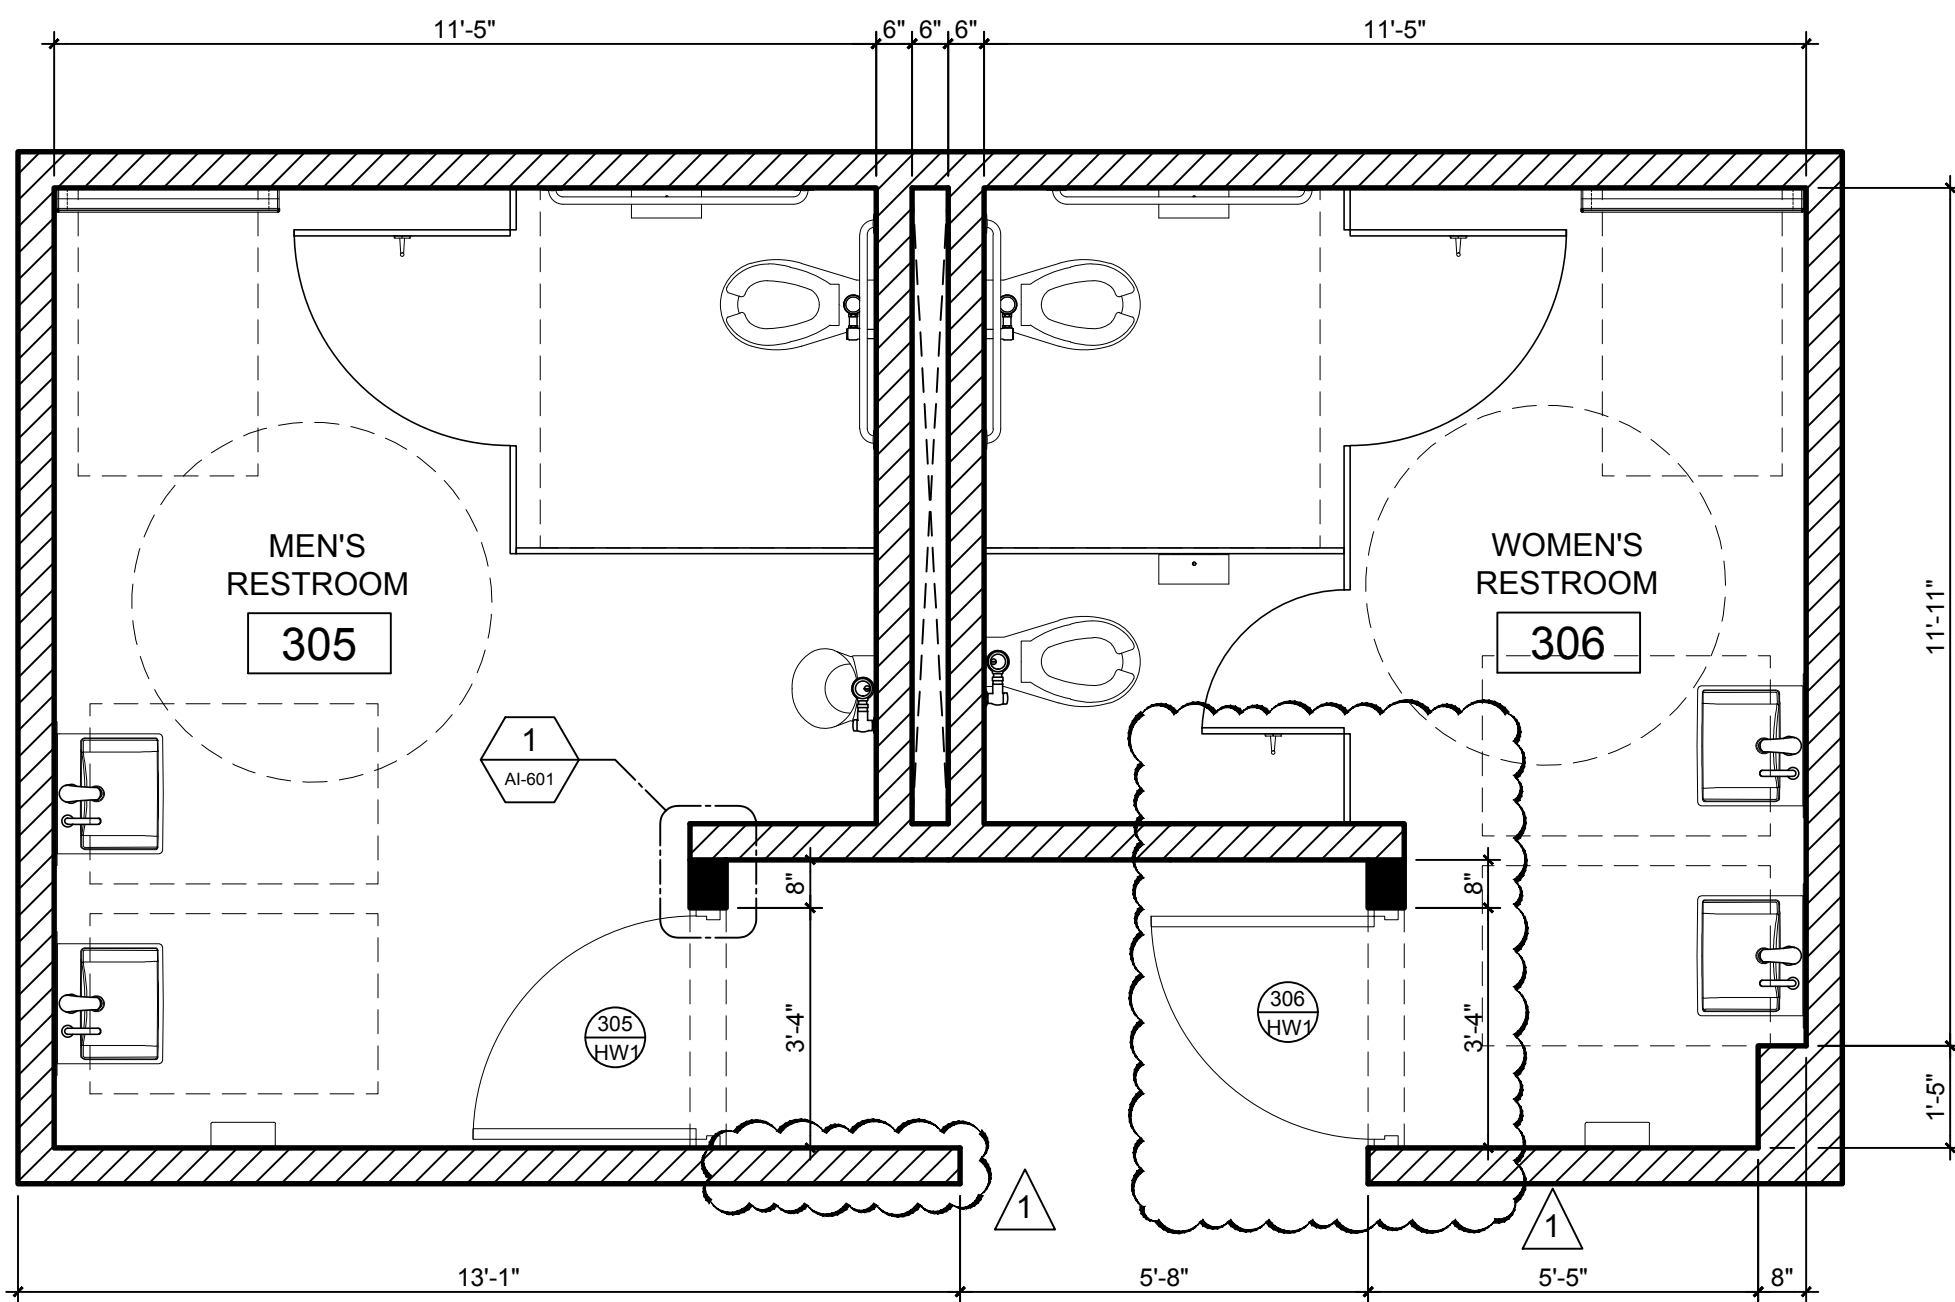

RESTROOM 3 - 2ND FLOOR
SCALE: 3/8"=1'-0"

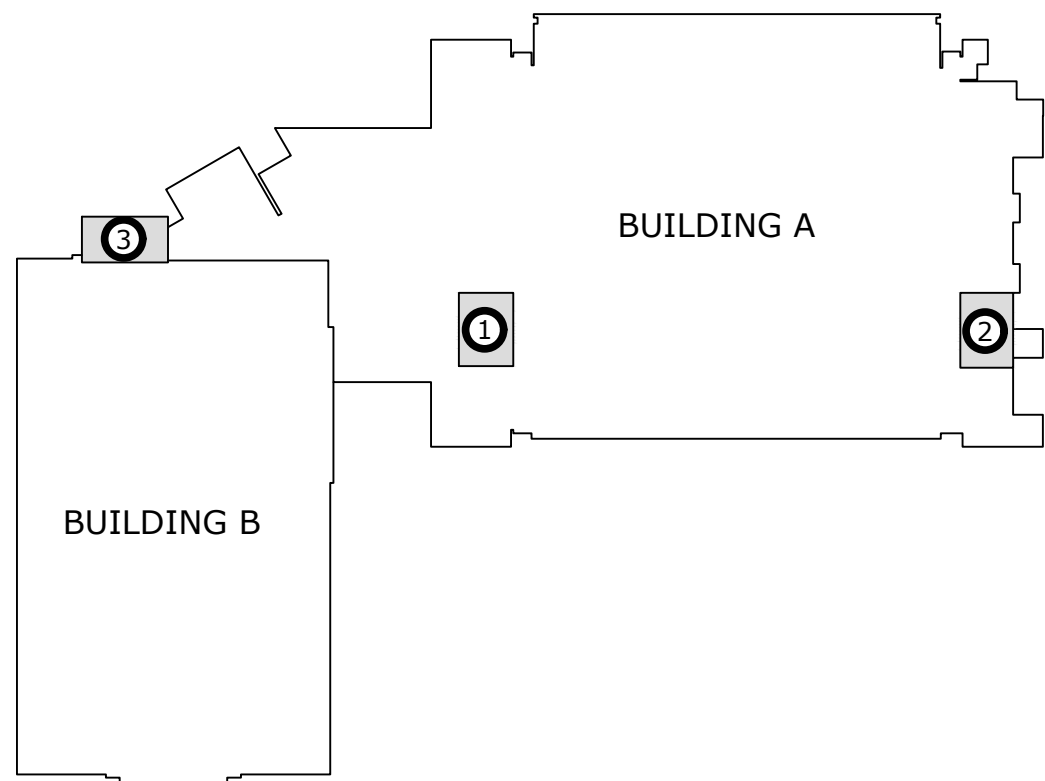

KEYPLAN
NOT TO SCALE

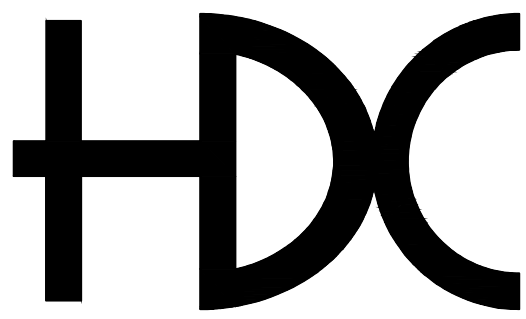

HORACIO DIAZ & ASSOCIATES PSC
CONSULTING ENGINEERS

6 URB. COSTA VERDE
HUMACAO, PUERTO RICO 00791-6036
TEL: (787) 568-1620
E-MAIL: horacio@hdcpr.com



STAMP | SELLO

THIRD LEVEL
PROPOSED
RESTROOM
FLOOR PLANS

TITLE SHEET | TITULO DE LA HOJA

HDC BID SET
NOT FOR CONSTRUCTION
APR 24, 2023

BO. TRUJILLO
BAJO, CARR.
PR-3 KM. 12.1
CAROLINA, PR

CENTRO
JUDICIAL DE
CAROLINA
PODER
JUDICIAL DE
PUERTO RICO

PROJECT NAME | NOMBRE DEL PROYECTO

THIS DRAWING AND ITS CONTENTS BELONGS TO
HORACIO DIAZ & ASSOCIATES.
THEY SHALL BE USED AS A REFERENCE DOCUMENT AND
WORKING INSTRUMENT ONLY BY AUTHORIZED PERSONNEL.
ANY TOTAL OR PARTIAL REPRODUCTION OR USE OF
THIS DOCUMENT IS STRICTLY PROHIBITED WITHOUT THE
APPROPRIATED WRITTEN CONSENT OF THIS FIRM AND
SHALL BE RETURNED TO THEIR OFFICE IF REQUIRED.

REVISIONS | REVISIONES

NO.	DESCRIPTION	DATE
01	REVISED FLOOR PLAN	APR 24, 2023

DRAWN BY | DIBUJADO POR: H. DIAZ
CHECK BY | COTEJADO POR: H. DIAZ
DESIGN BY | DISEÑADO POR: H. DIAZ
APPROVED BY | APROBADO POR: H. DIAZ
DATE | FECHA: APRIL 24, 2023
SCALE | ESCALA: AS SHOWN

PROJECT NO. | NÚM. PROYECTO


2022 39

SHEET NO. | NÚM. DE HOJA


6 OF 15

DRAWING NO. | NÚM. DE DIBUJO


AI-103

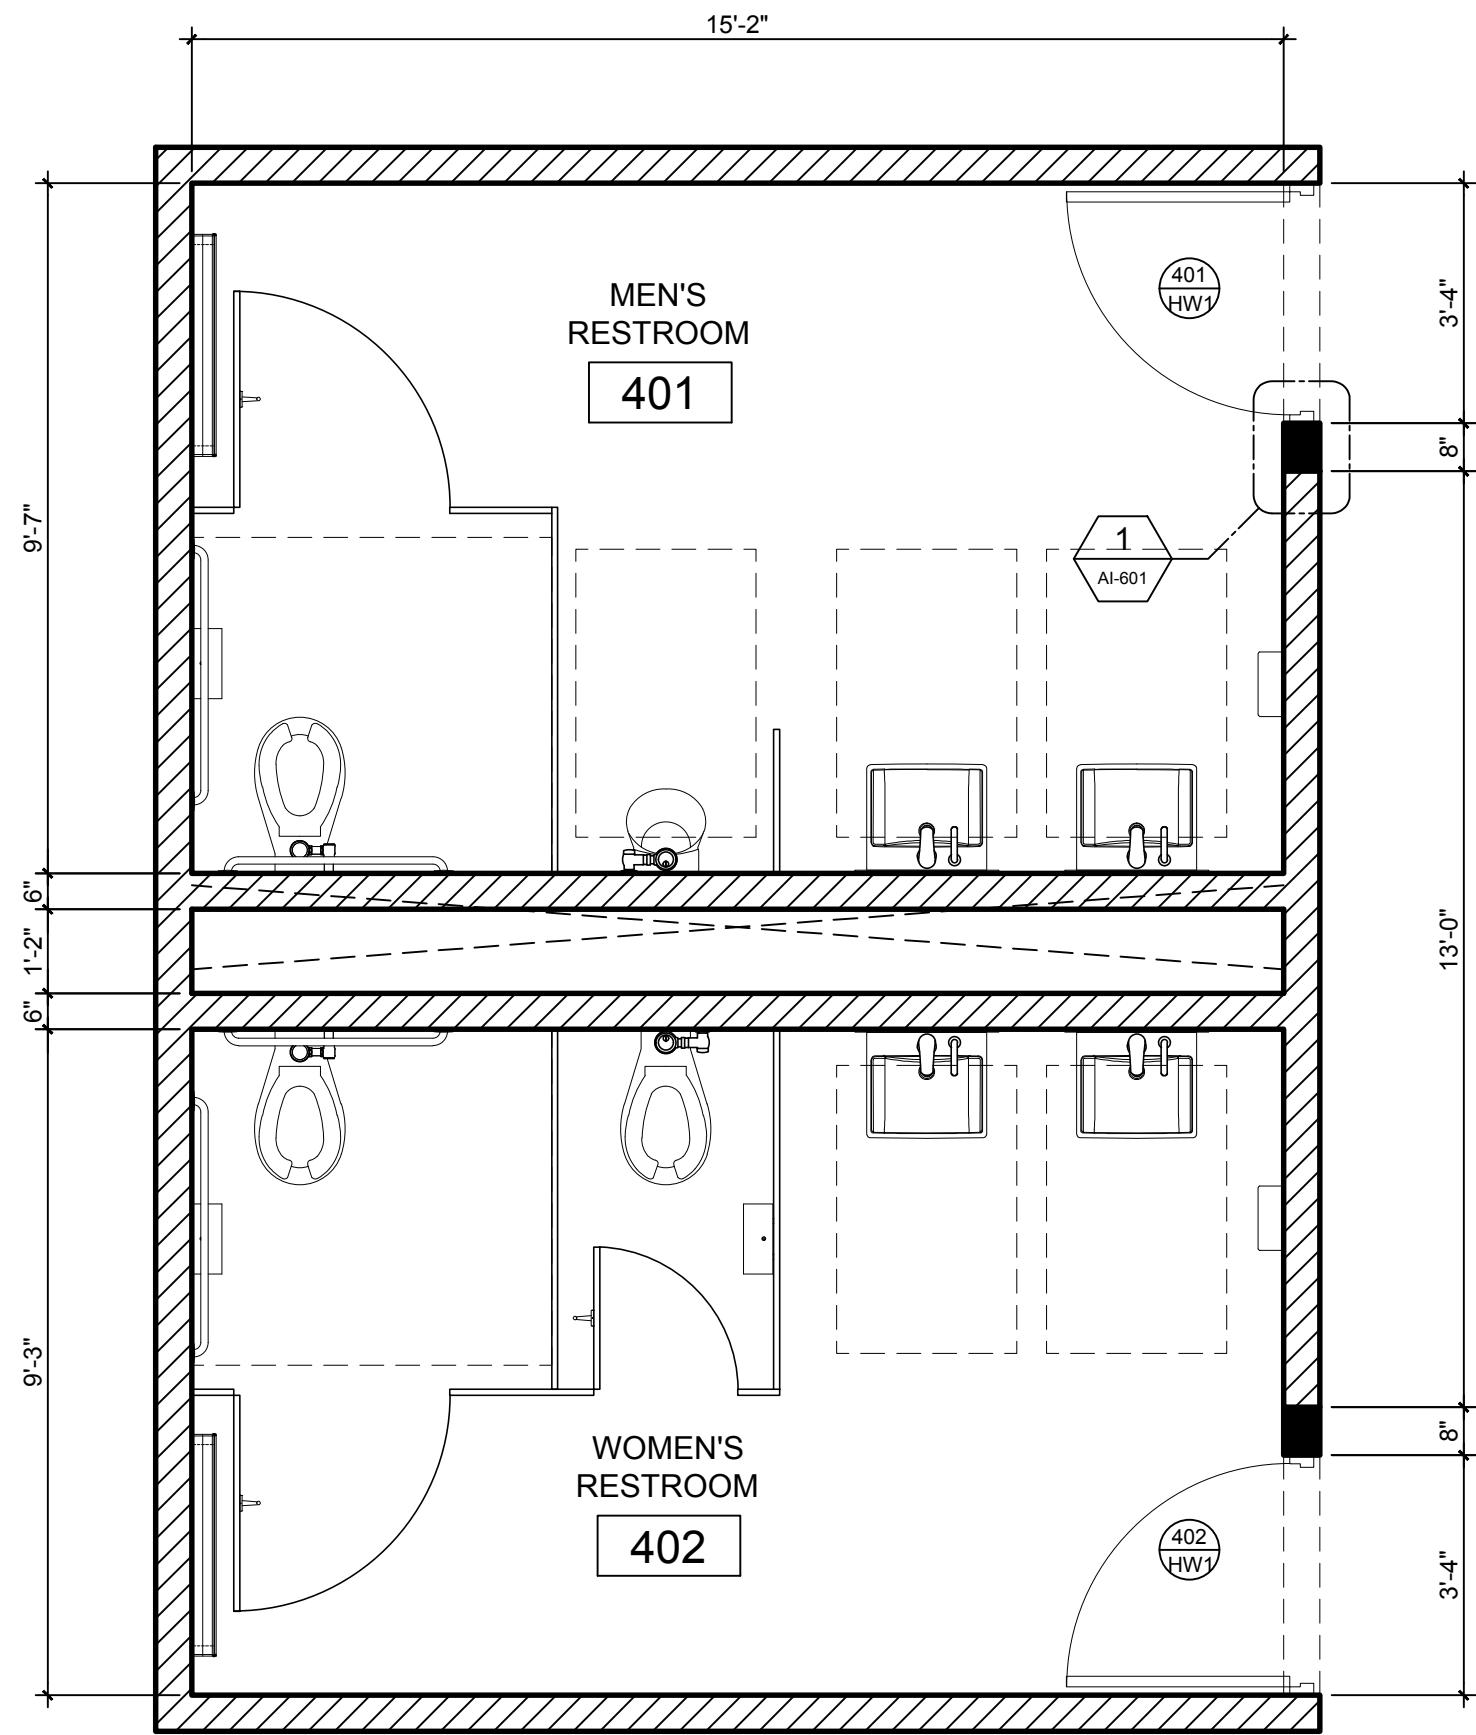


RESTROOM 1 - 4TH FLOOR
SCALE: 3/8"=1'-0"

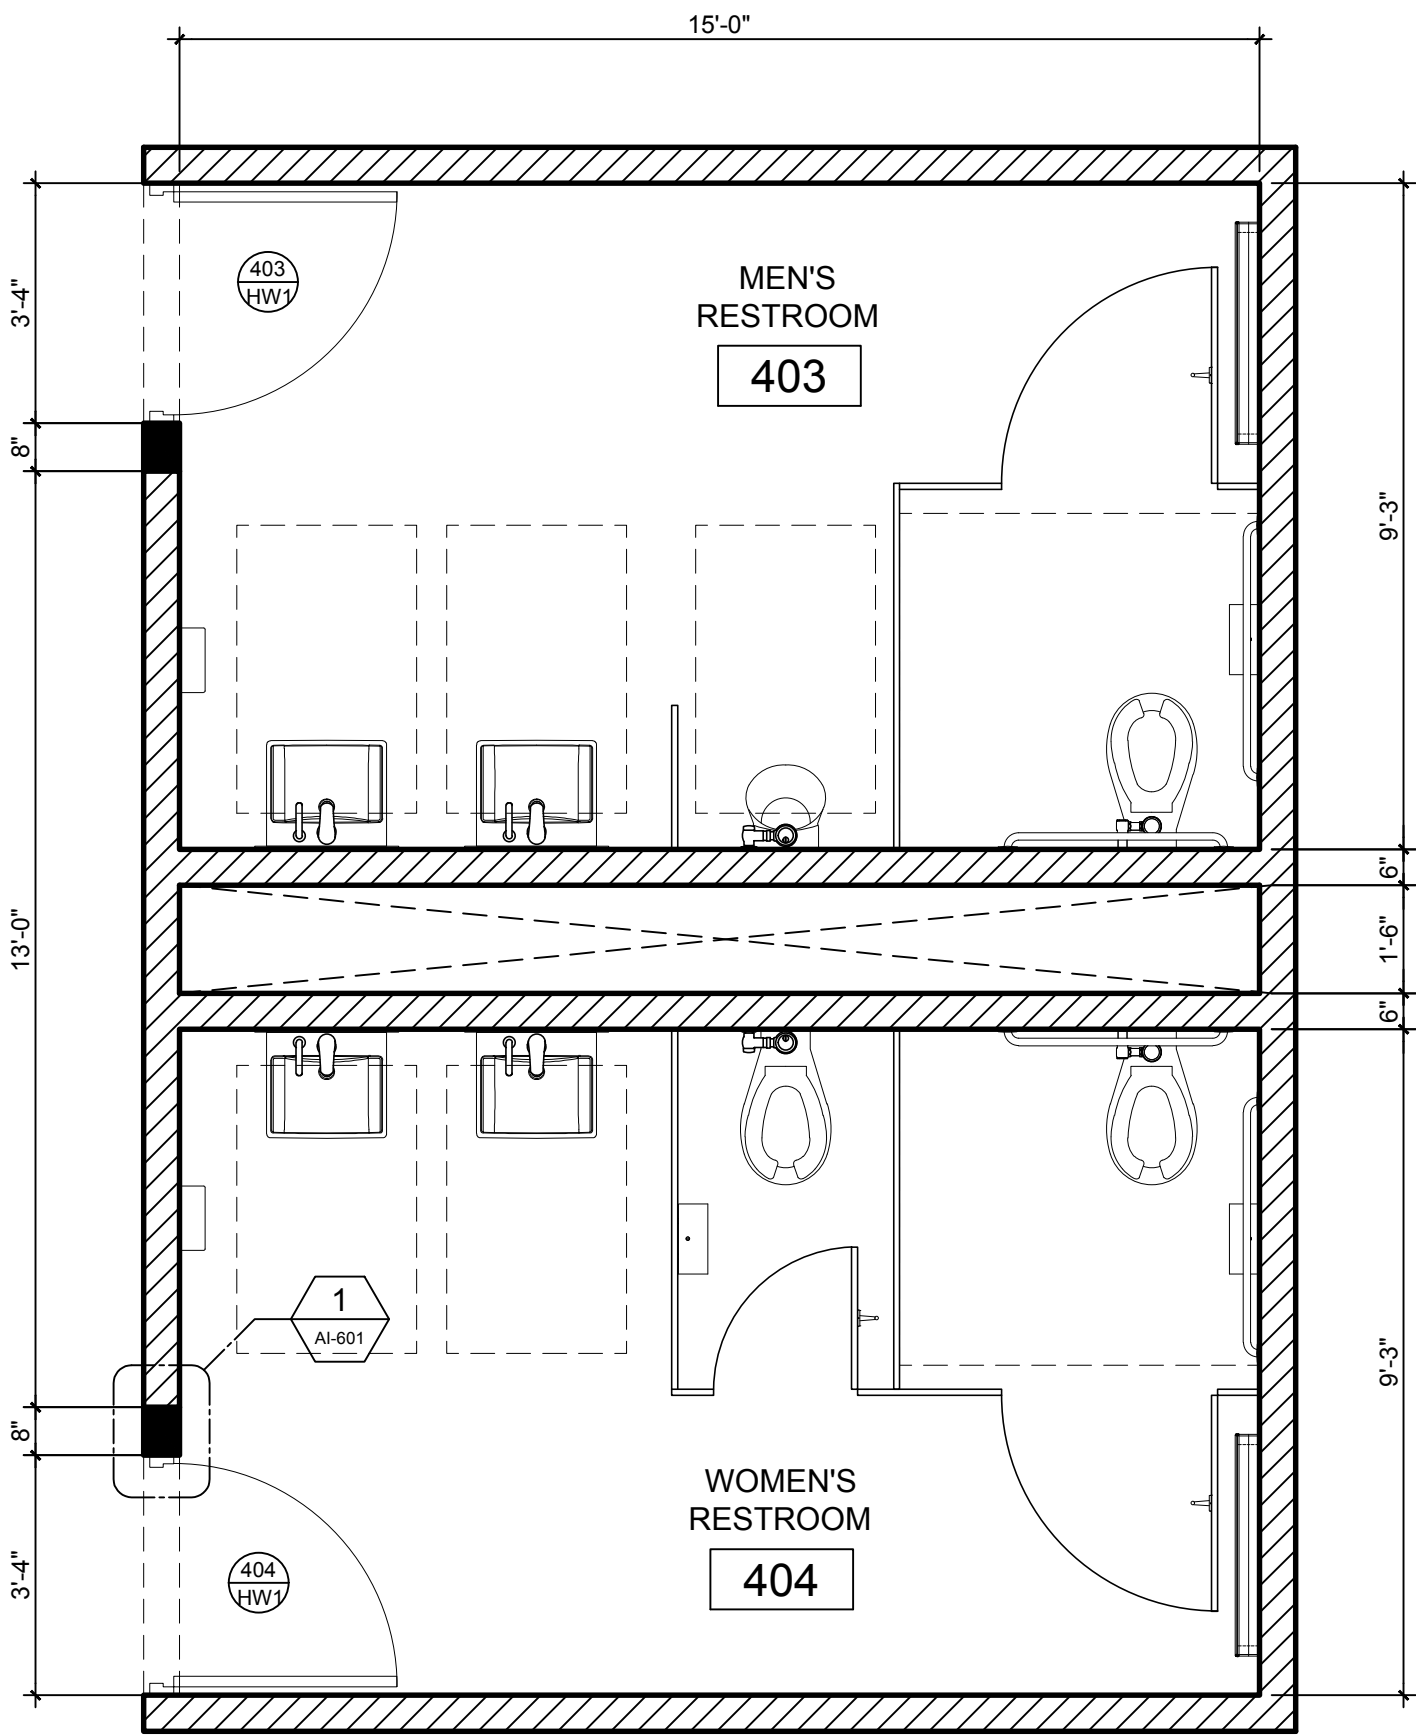


RESTROOM 2 - 4TH FLOOR
SCALE: 3/8"=1'-0"

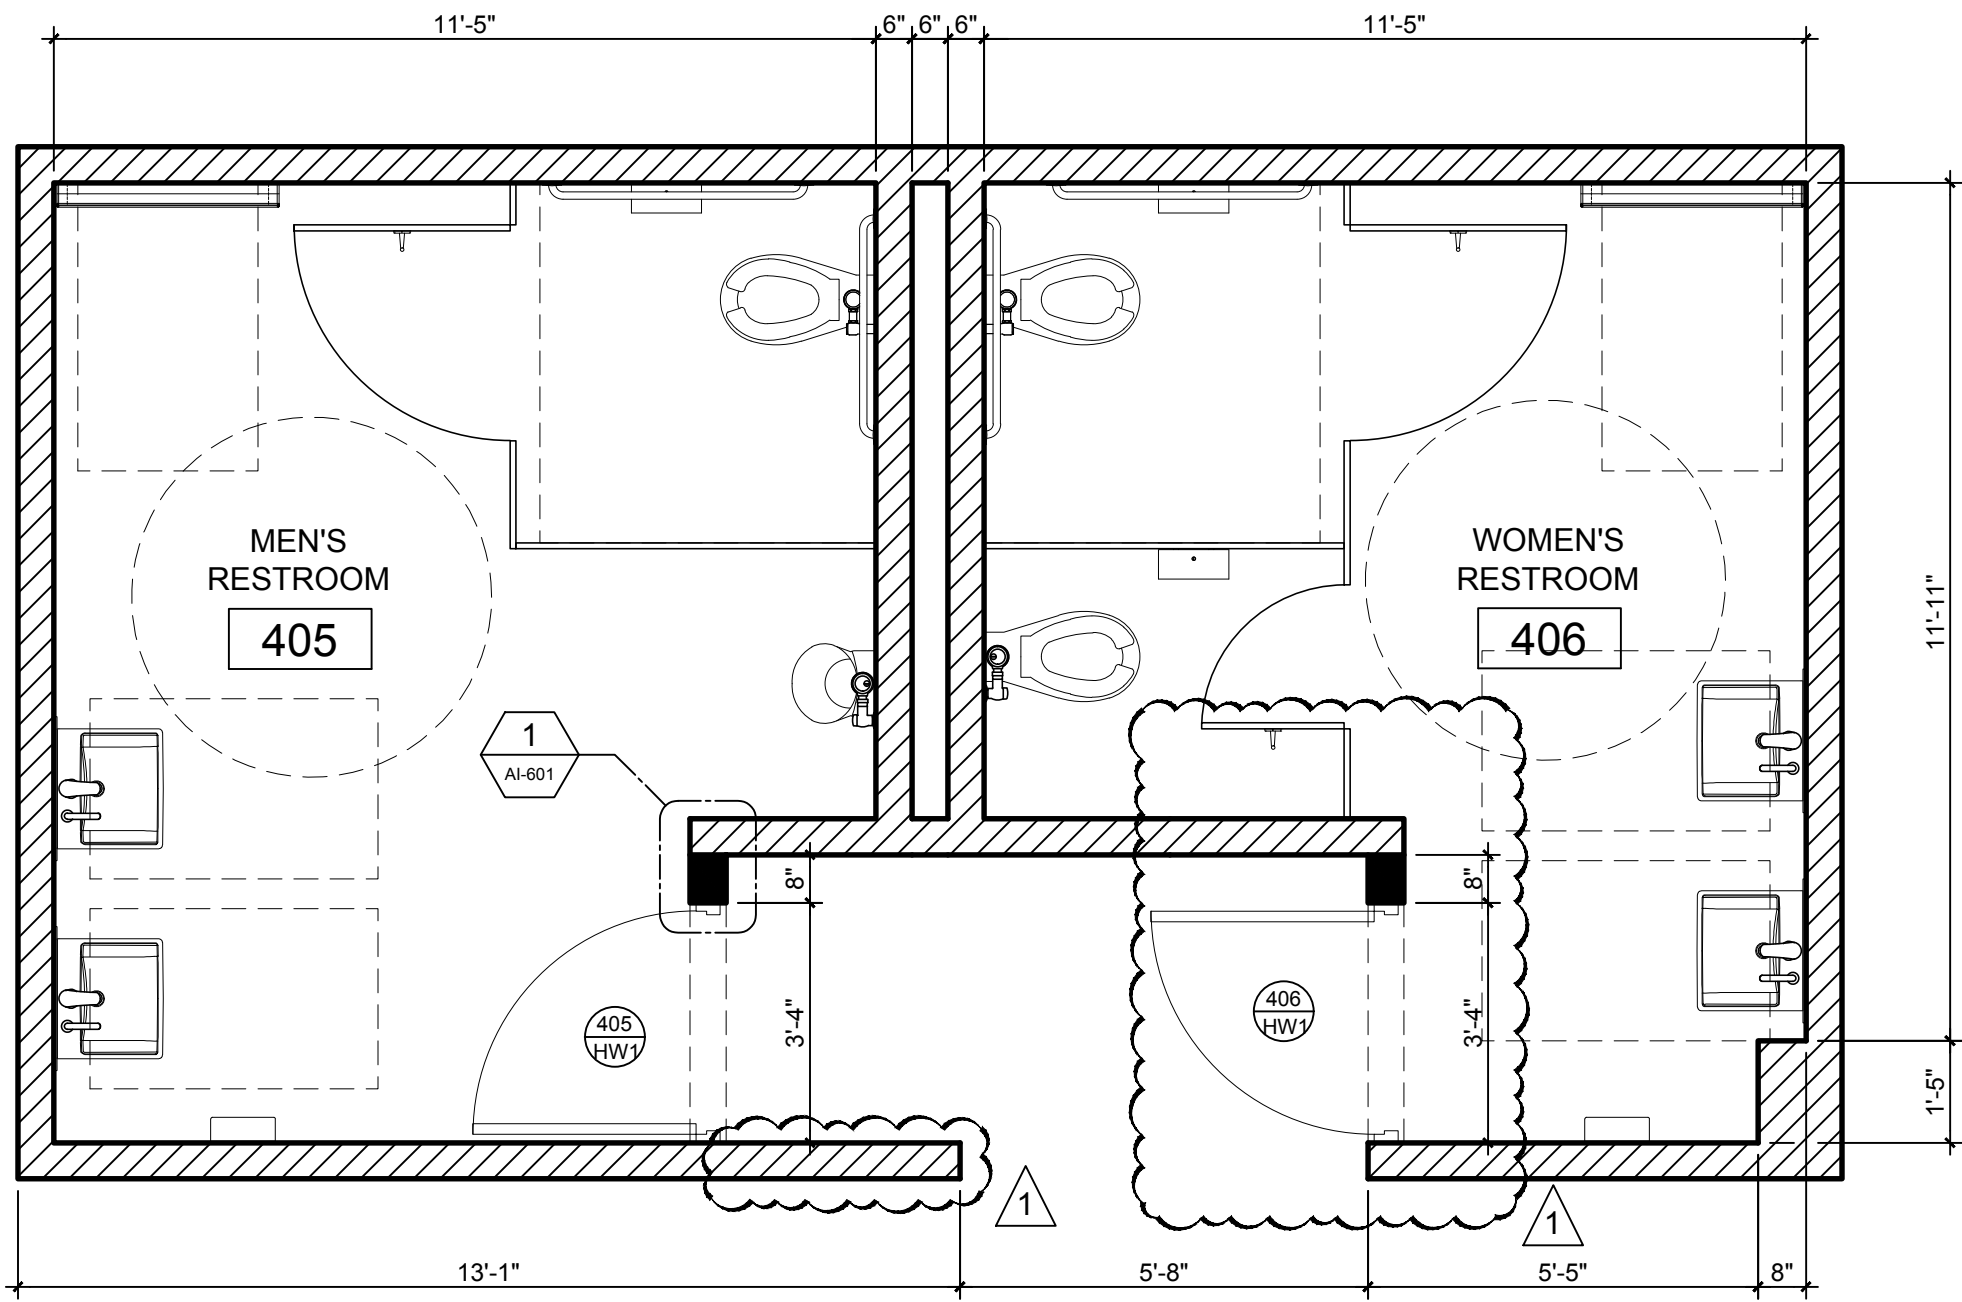

RESTROOM 3 - 3RD FLOOR
SCALE: 3/8"=1'-0"

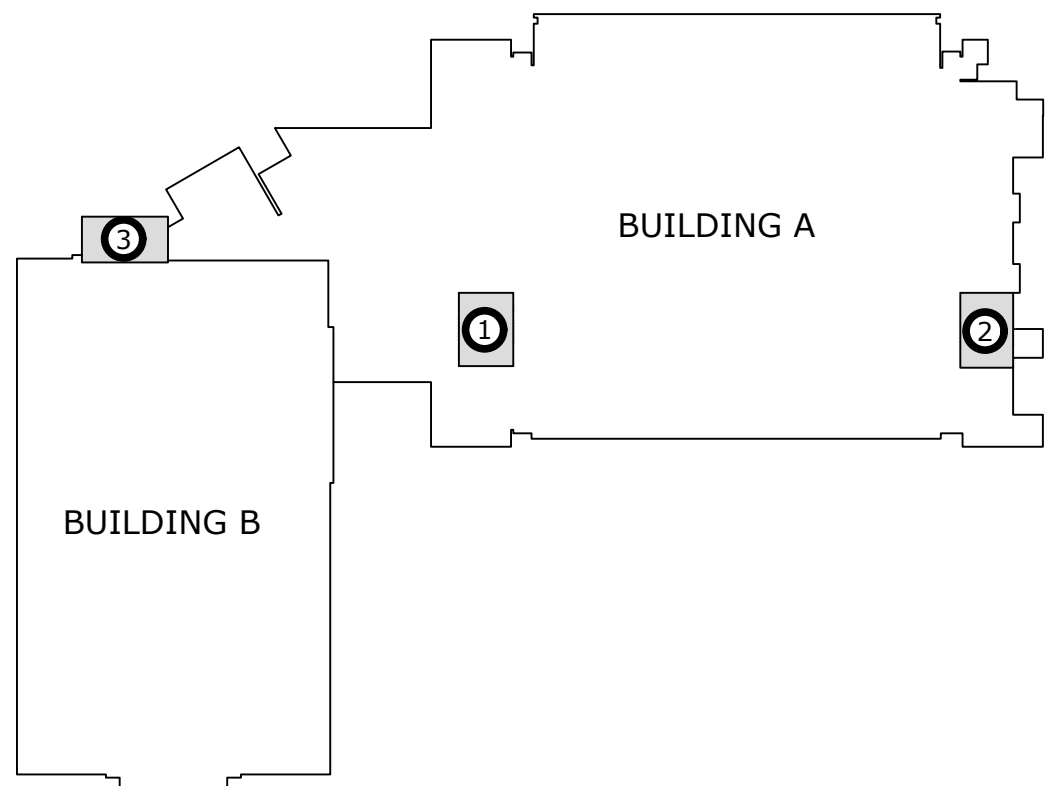

KEYPLAN
NOT TO SCALE

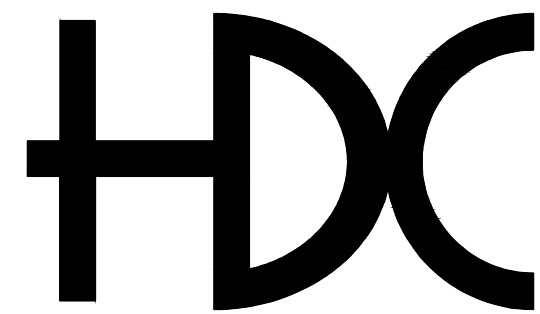

HORACIO DIAZ & ASSOCIATES PSC
CONSULTING ENGINEERS

6 URB. COSTA VERDE
HUMACAO, PUERTO RICO 00791-6036
TEL: (787) 568-1620
E-MAIL: horacio@hdcpr.com



STAMP | SELLO

FOURTH LEVEL
PROPOSED
RESTROOM
FLOOR PLANS

TITLE SHEET | TITULO DE LA HOJA

HDC BID SET
NOT FOR CONSTRUCTION
APR 24, 2023

BO. TRUJILLO
BAJO, CARR.
PR-3 KM. 12.1
CAROLINA, PR

CENTRO
JUDICIAL DE
CAROLINA
PODER
JUDICIAL DE
PUERTO RICO

PROJECT NAME | NOMBRE DEL PROYECTO

THIS DRAWING AND ITS CONTENTS BELONGS TO
HORACIO DIAZ & ASSOCIATES.
THEY SHALL BE USED AS A REFERENCE DOCUMENT AND
WORKING INSTRUMENT ONLY BY AUTHORIZED PERSONNEL.
ANY TOTAL OR PARTIAL REPRODUCTION OR USE OF
THIS DOCUMENT IS STRICTLY PROHIBITED WITHOUT THE
APPROPRIATED WRITTEN CONSENT OF THIS FIRM AND
SHALL BE RETURNED TO THEIR OFFICE IF REQUIRED.

REVISIONS | REVISIONES

NO.	DESCRIPTION	DATE
01	REVISED FLOOR PLAN	APR 24, 2023

DRAWN BY | DIBUJADO POR: H. DIAZ
CHECK BY | COTEJADO POR: H. DIAZ
DESIGN BY | DISEÑADO POR: H. DIAZ
APPROVED BY | APROBADO POR: H. DIAZ
DATE | FECHA: APRIL 24, 2023
SCALE | ESCALA: AS SHOWN

PROJECT NO. | NÚM. PROYECTO


2022 39

SHEET NO. | NÚM. DE HOJA

7 OF 15


DRAWING NO. | NÚM. DE DIBUJO

AI-104

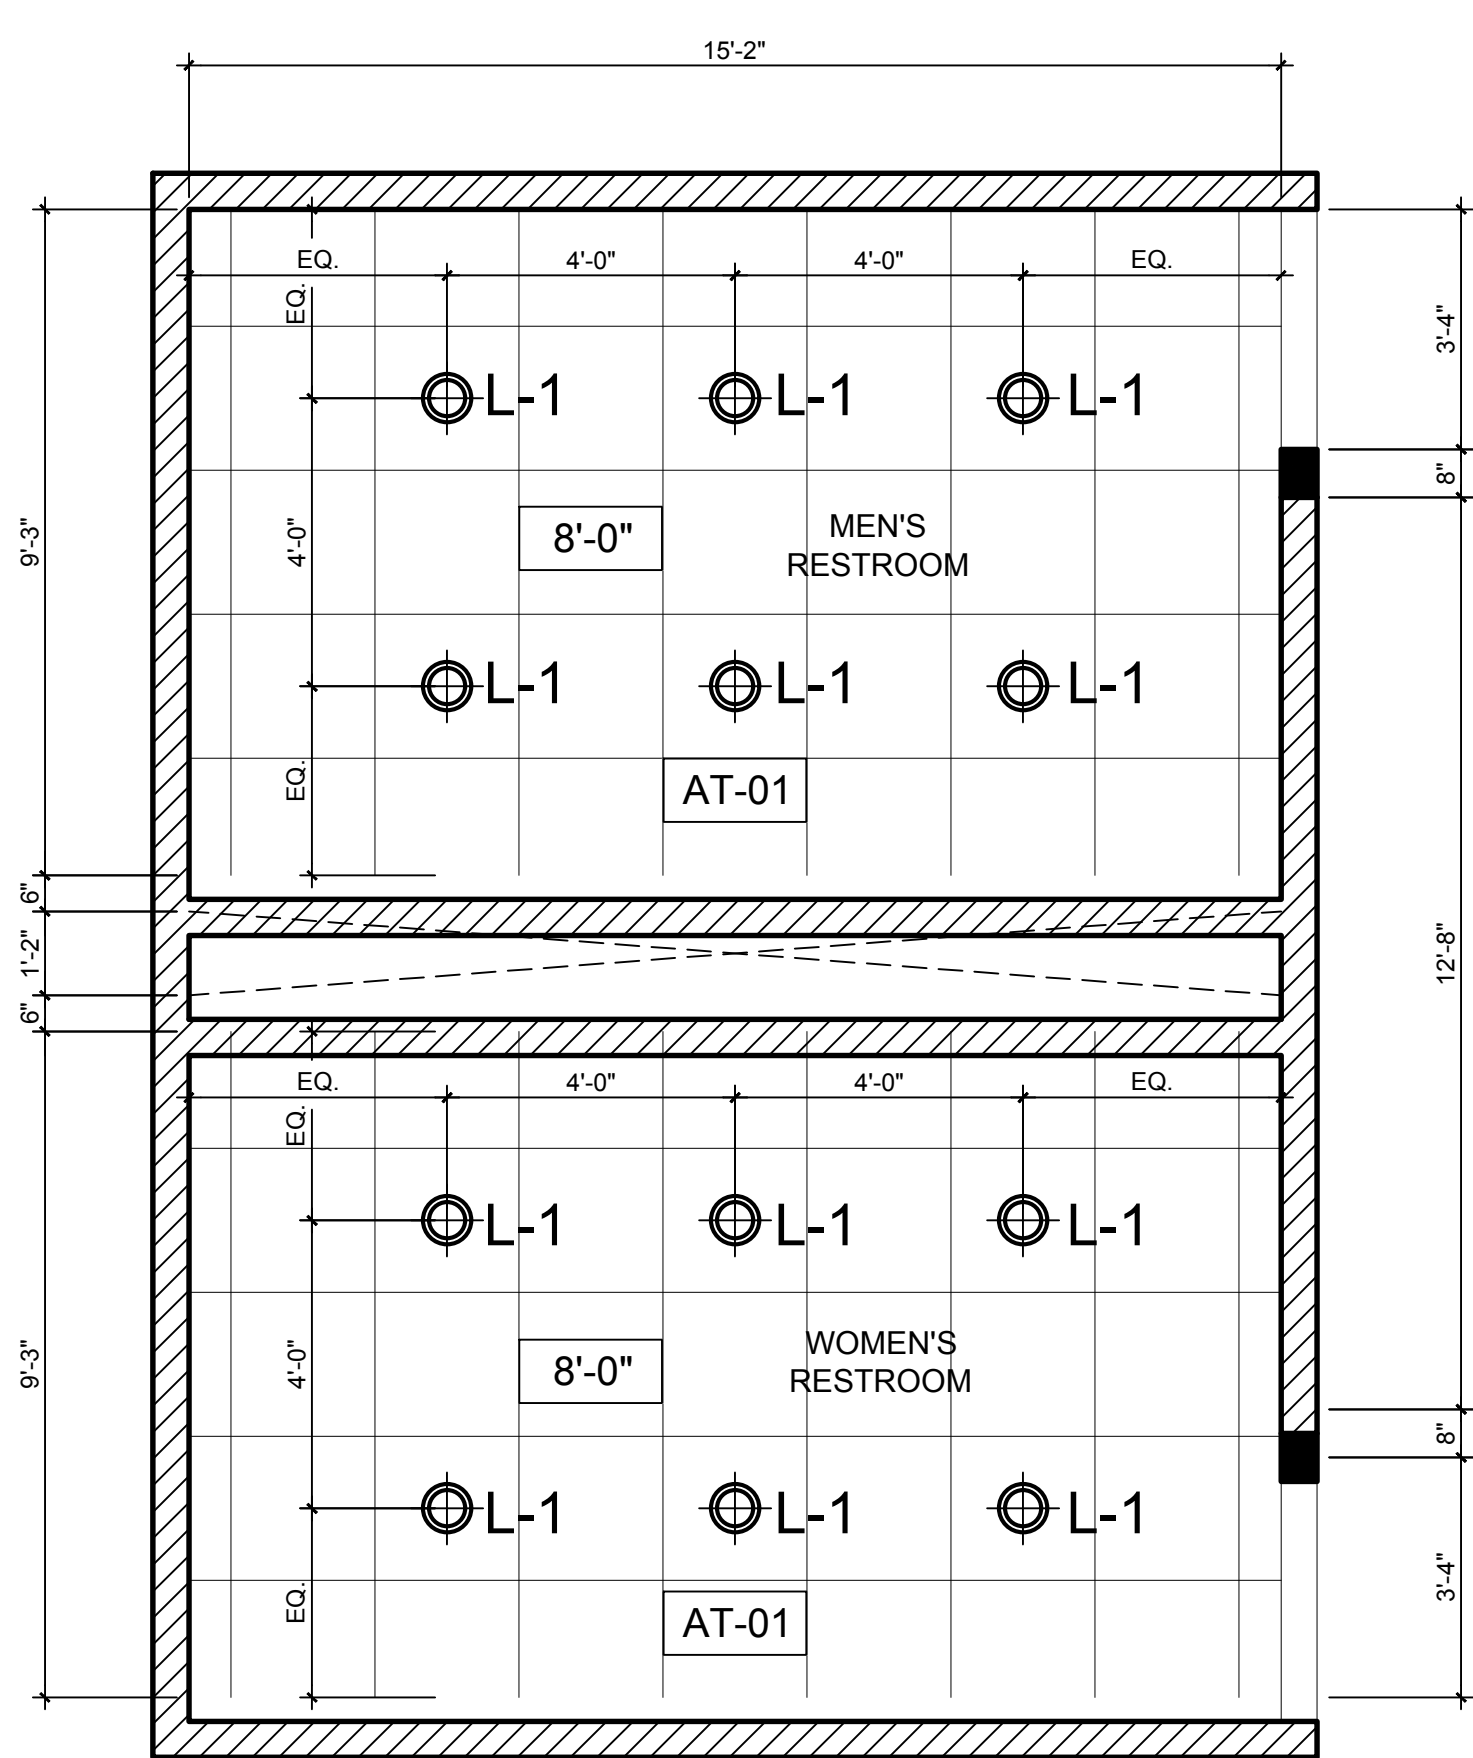


RESTROOM 1 - 1ST, 2ND, 3RD & 4TH FLOOR REFLECTED CEILING PLAN

SCALE: 3/8"=1'-0"

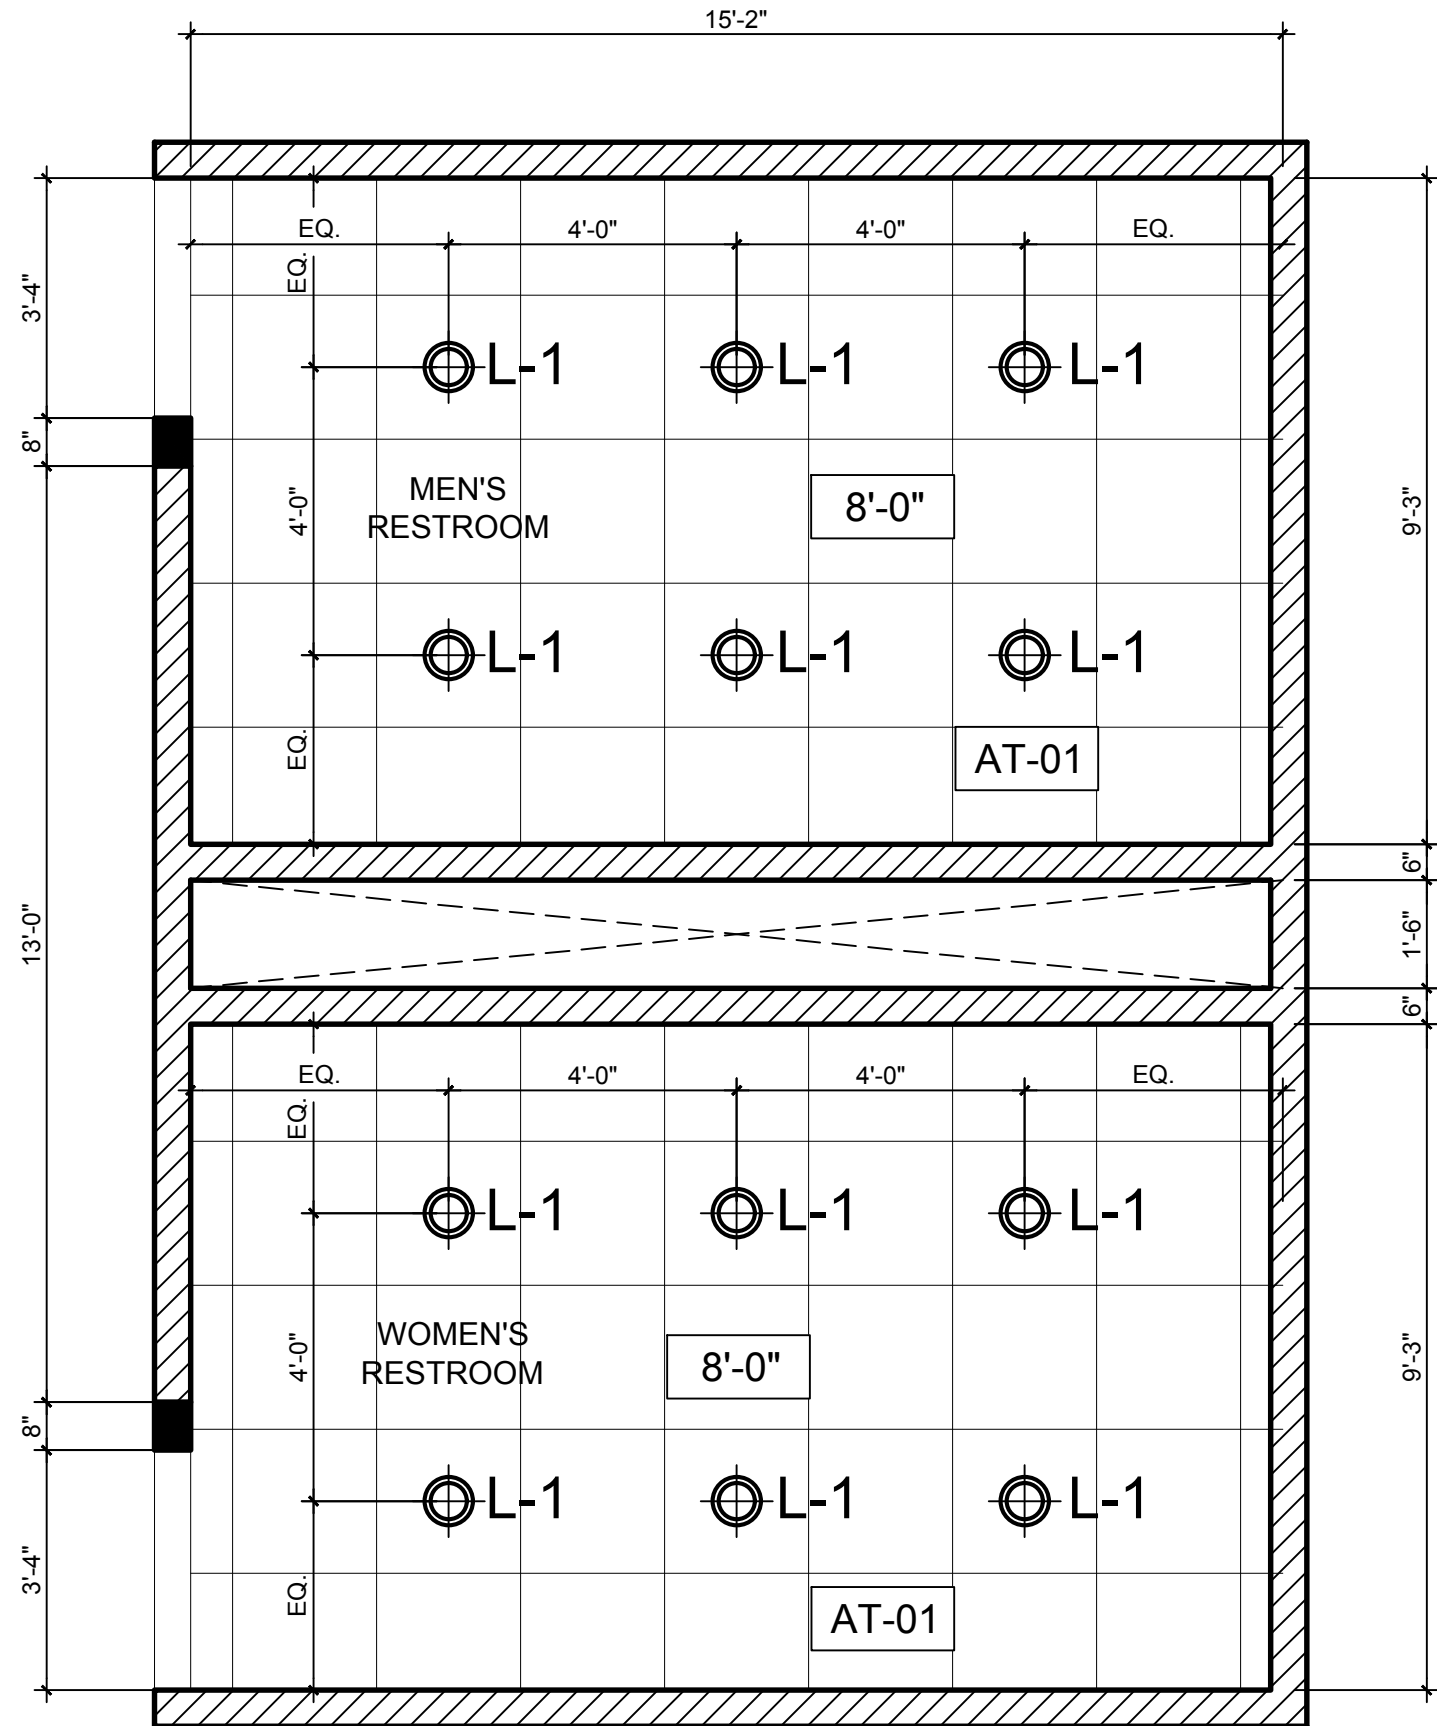

RESTROOM 2 - 1ST, 2ND, 3RD & 4TH FLOOR REFLECTED CEILING PLAN




SCALE: 3/8"=1'-0"

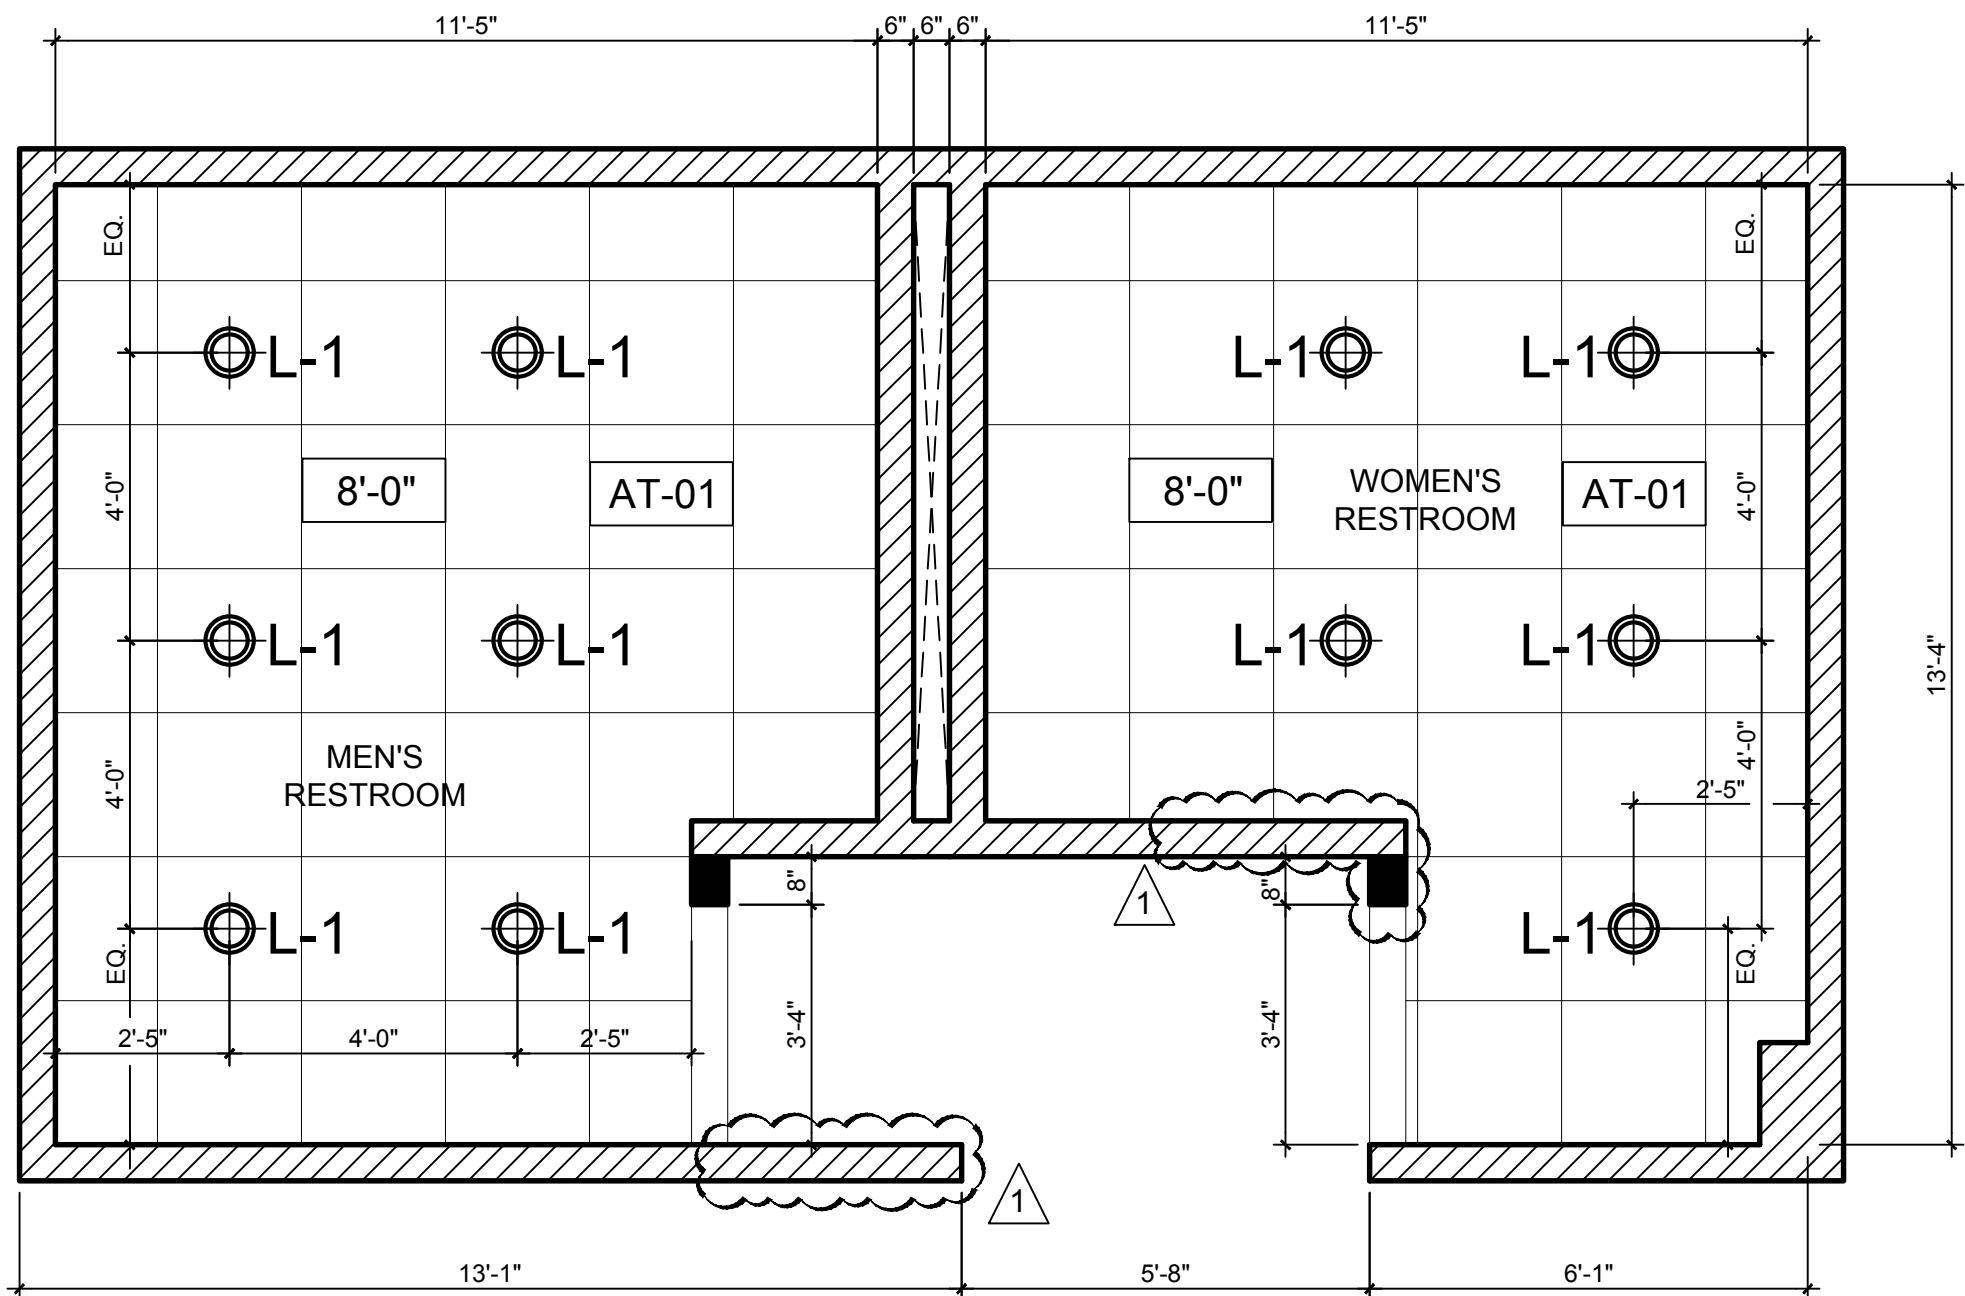


RESTROOM 3 - BASEMENT, 1ST, 2ND & 3RD FLOOR REFLECTED CEILING PLAN


SCALE: 3/8"=1'-0"

  LEGEND

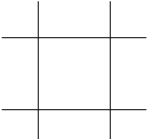
-  L-1 RECESSED LED DOWNLIGHT
-  NEW 2'X2' ACOUSTICAL CEILING AND SUSPENSION SYSTEM
-  8'-0" INDICATES CEILING HEIGHT ABOVE FINISHED FLOOR A.F.F.
-  INDICATES EXISTING WALL TO REMAIN
-  AT-01 INDICATES ACOUSTIC TILE TYPE

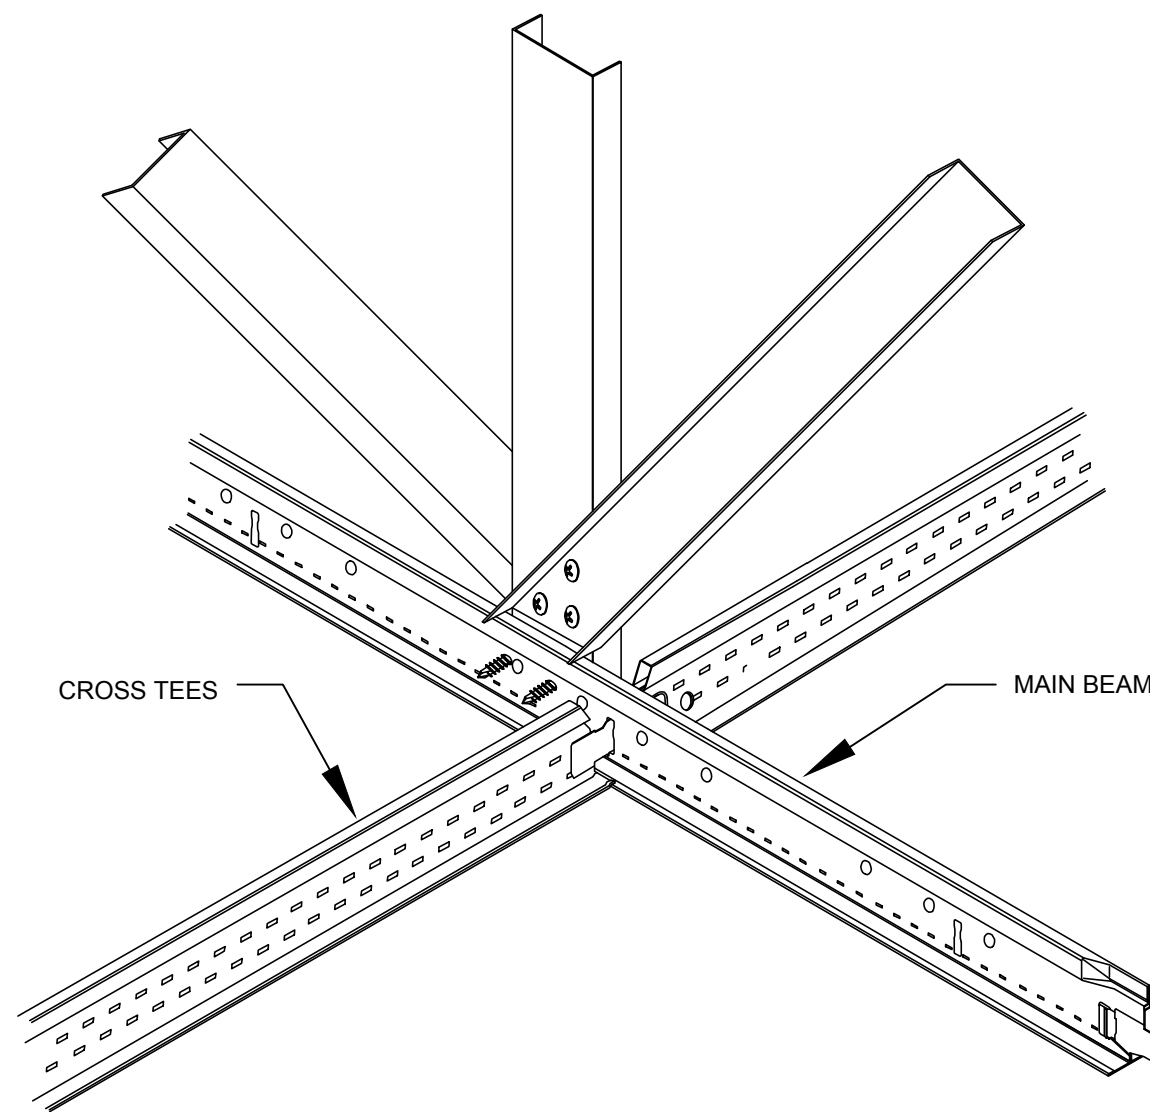

TYPICAL SEISMIC BRACING
NOT TO SCALE

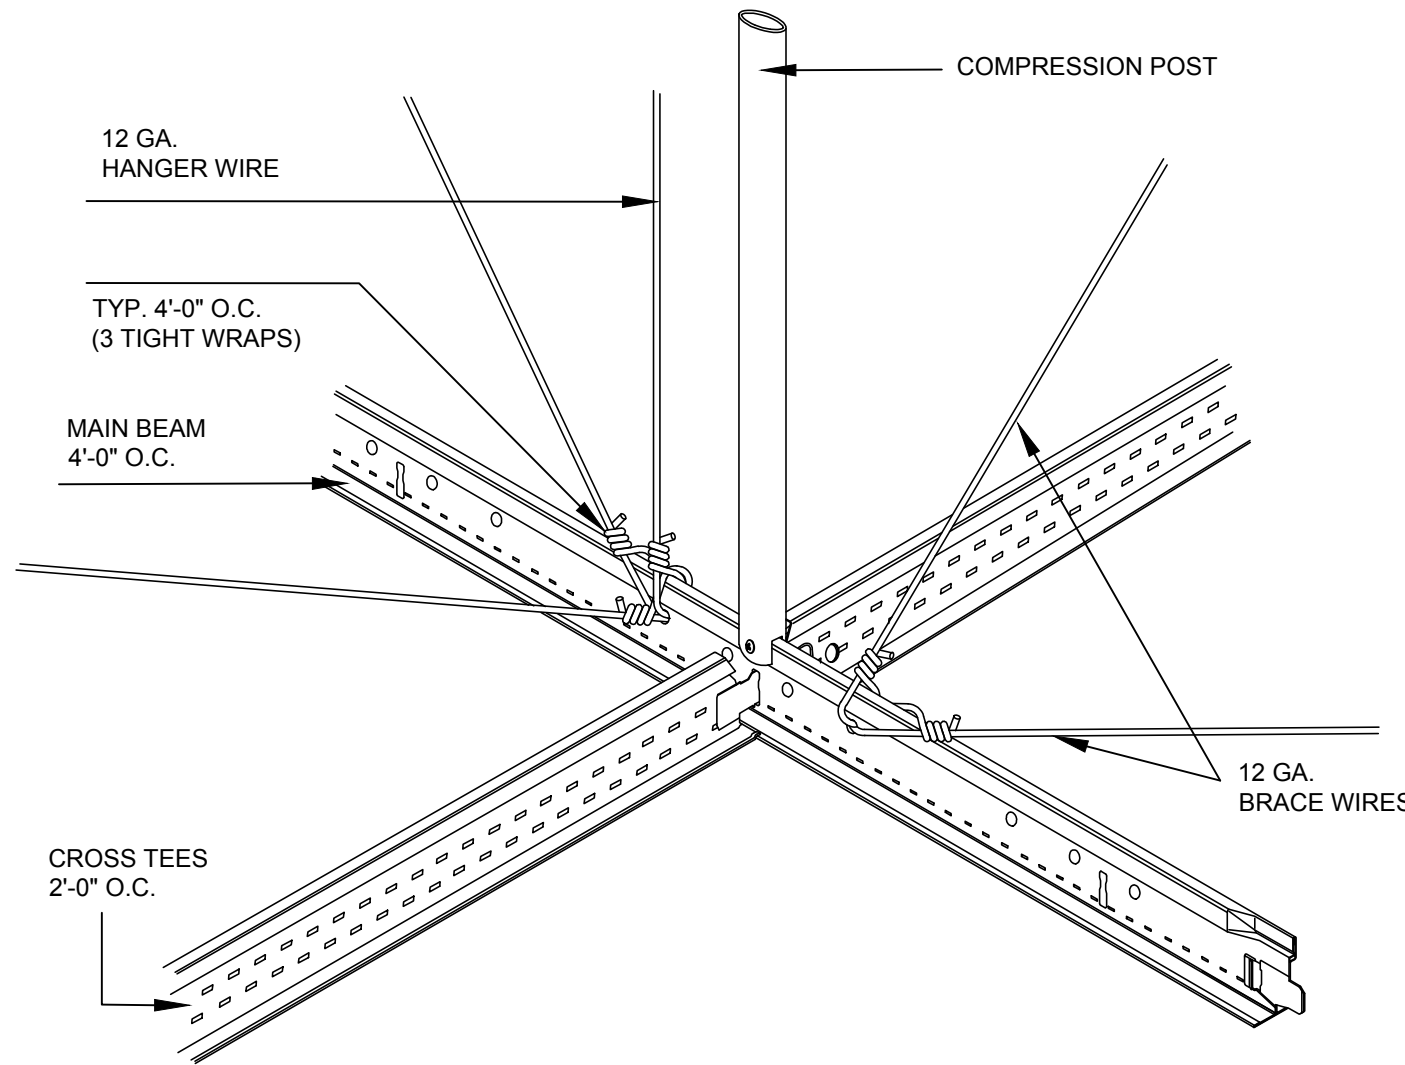


TYPICAL SEISMIC BRACING
NOT TO SCALE

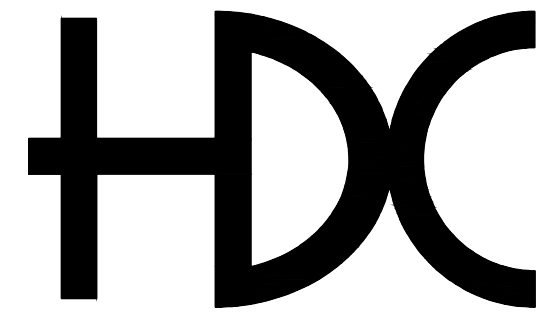

HORACIO DIAZ & ASSOCIATES PSC
CONSULTING ENGINEERS

6 URB. COSTA VERDE
HUMACAO, PUERTO RICO 00791-6036
TEL: (787) 568-1620
E-MAIL: horacio@hdcpr.com

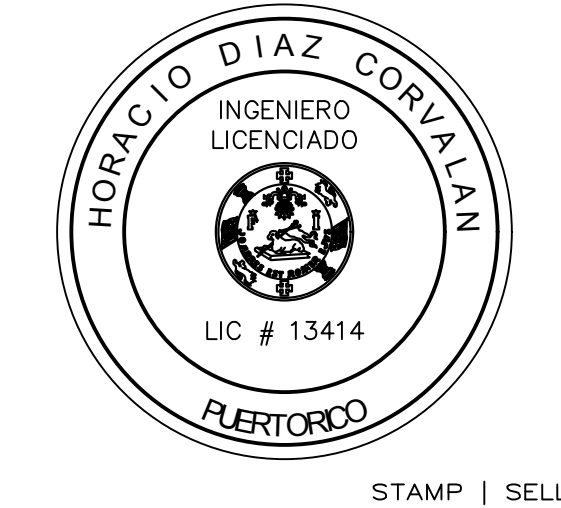

STAMP | SELLO

PROPOSED
RESTROOM
REFLECTED CEILING
PLANS

TITLE SHEET | TITULO DE LA HOJA



BO. TRUJILLO
BAJO, CARR.
PR-3 KM. 12.1
CAROLINA, PR

CENTRO
JUDICIAL DE
CAROLINA
PODER
JUDICIAL DE
PUERTO RICO

PROJECT NAME | NOMBRE DEL PROYECTO

THIS DRAWING AND ITS CONTENTS BELONGS TO
HORACIO DIAZ & ASSOCIATES.
THEY SHALL BE USED AS A REFERENCE DOCUMENT AND
WORKING INSTRUMENT ONLY BY AUTHORIZED PERSONNEL.
ANY TOTAL OR PARTIAL REPRODUCTION OR USE OF
THIS DOCUMENT IS STRICTLY PROHIBITED WITHOUT THE
APPROPRIATED WRITTEN CONSENT OF THIS FIRM AND
SHALL BE RETURNED TO THEIR OFFICE IF REQUIRED.

REVISIONS | REVISIONES

NO.	DESCRIPTION	DATE
01	REVISED CEILING PLAN	APR 24, 2023

DRAWN BY | DIBUJADO POR H. DIAZ
DESIGN BY | DISEÑADO POR H. DIAZ
CHECK BY | COTEJADO POR H. DIAZ
APPROVED BY | APROBADO POR H. DIAZ
DATE | FECHA APRIL 24, 2023
SCALE | ESCALA AS SHOWN

PROJECT NO. | NÚM. PROYECTO


2022 39

SHEET NO. | NÚM. DE HOJA


8 OF 15

DRAWING NO. | NÚM. DE DIBUJO


AI-105

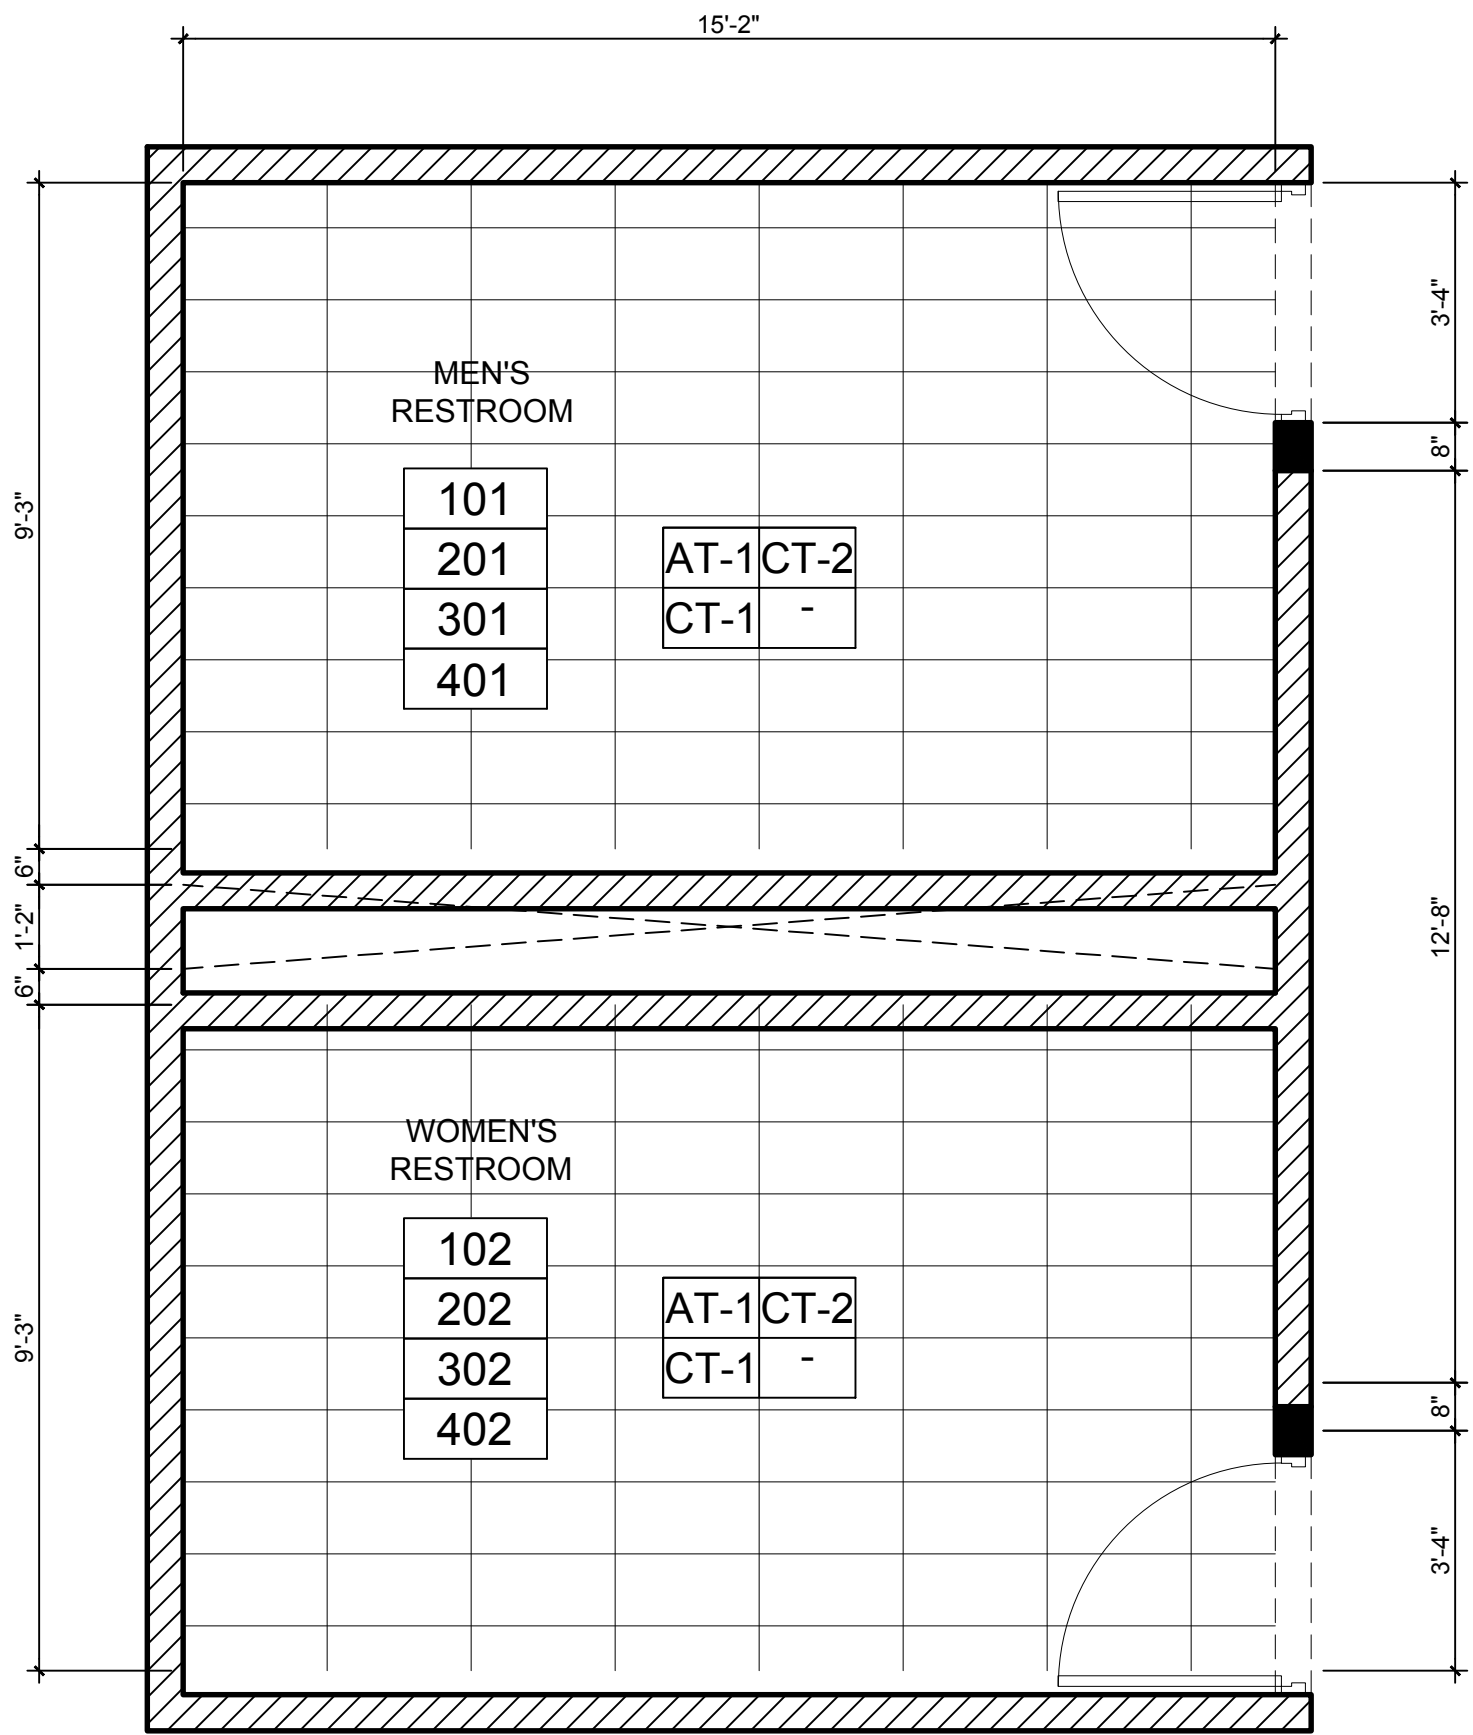

RESTROOM 1 - 1ST, 2ND, 3RD & 4TH FLOOR
FINISHES PLAN
SCALE: 3/8"=1'-0"

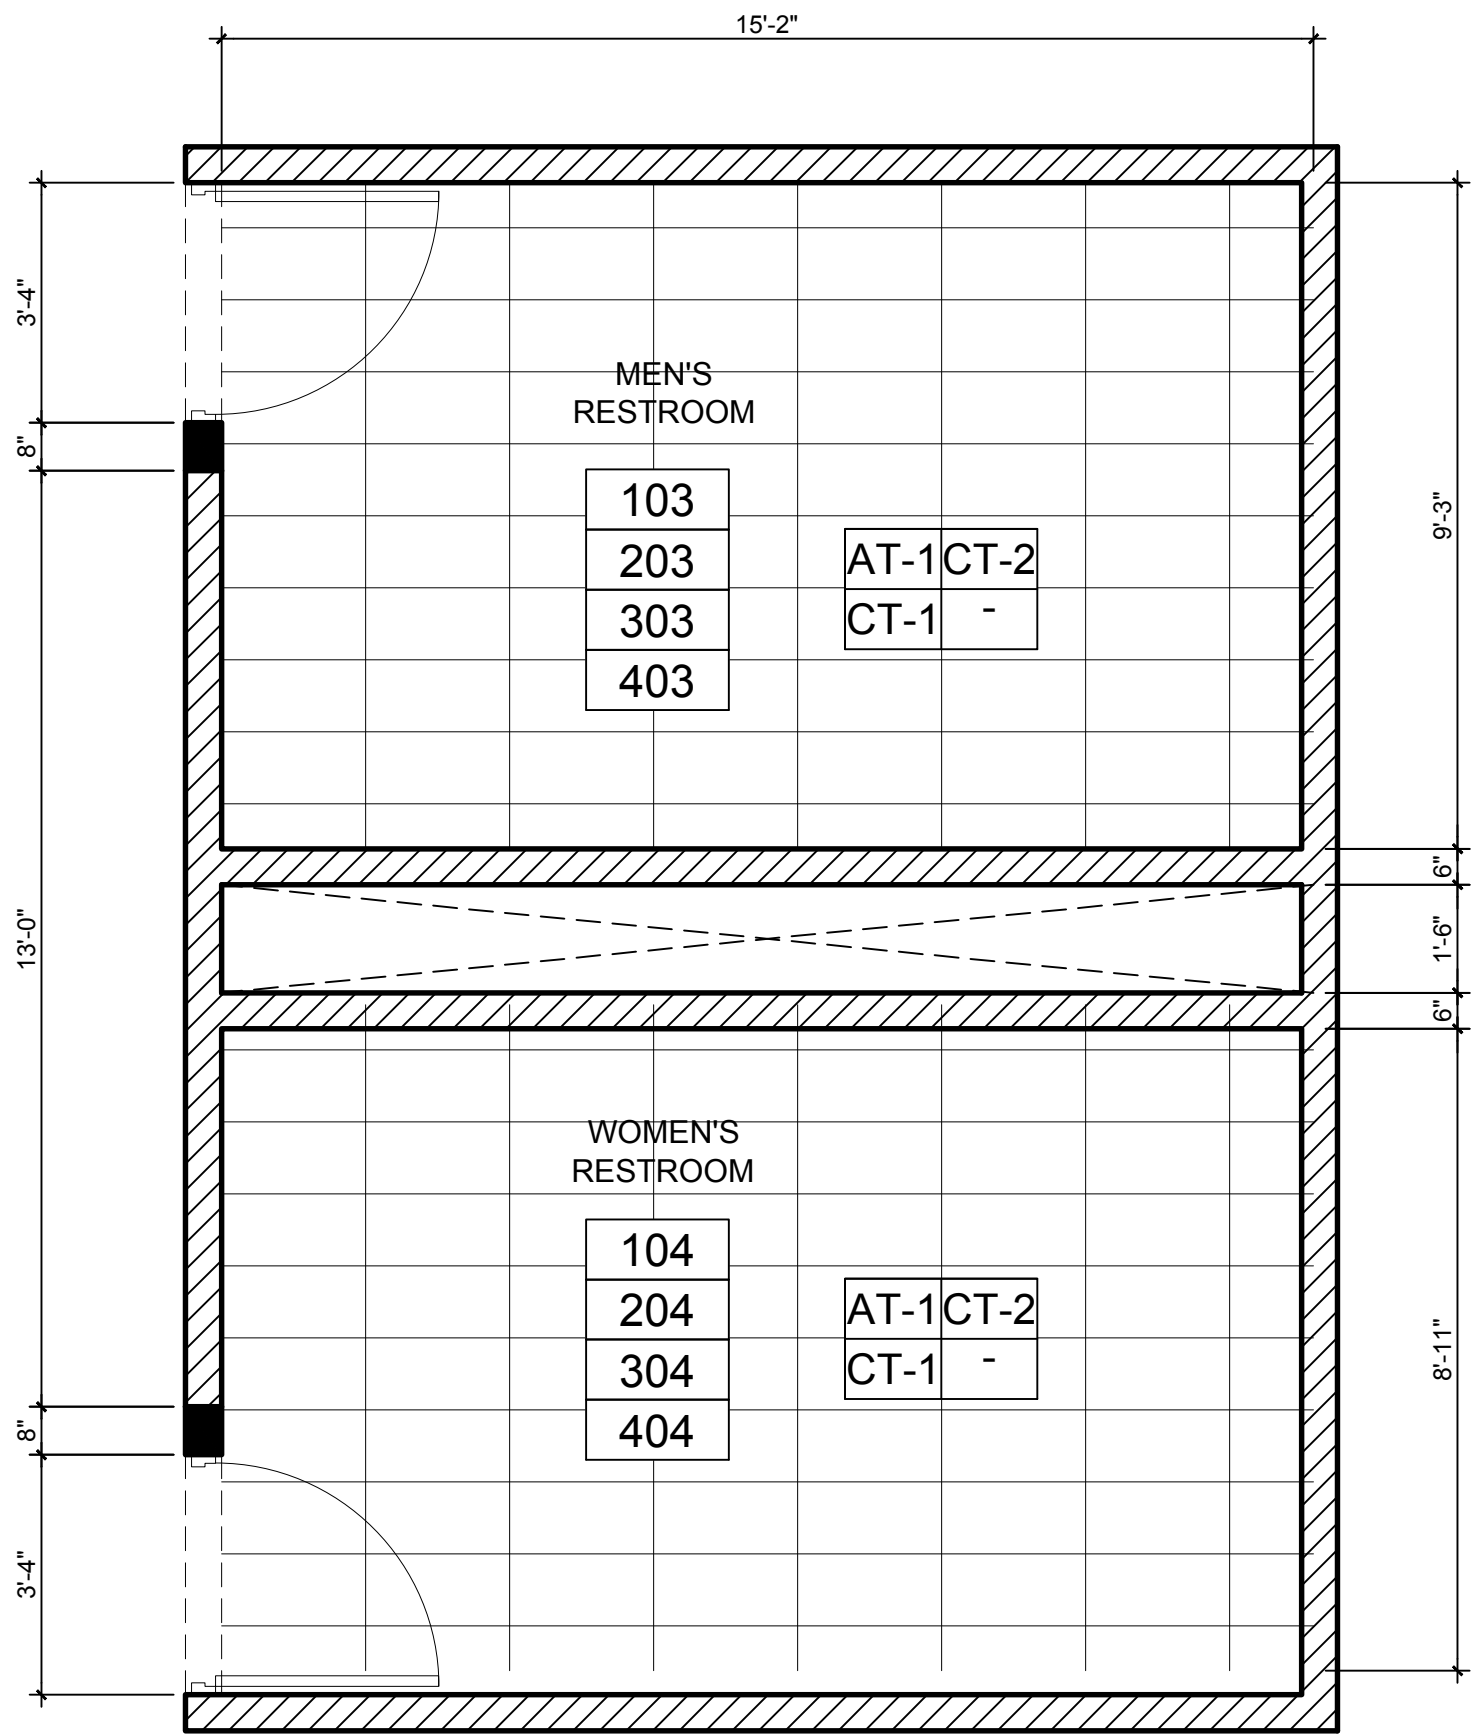


RESTROOM 2 - 1ST, 2ND, 3RD & 4TH FLOOR
FINISHES PLAN
SCALE: 3/8"=1'-0"

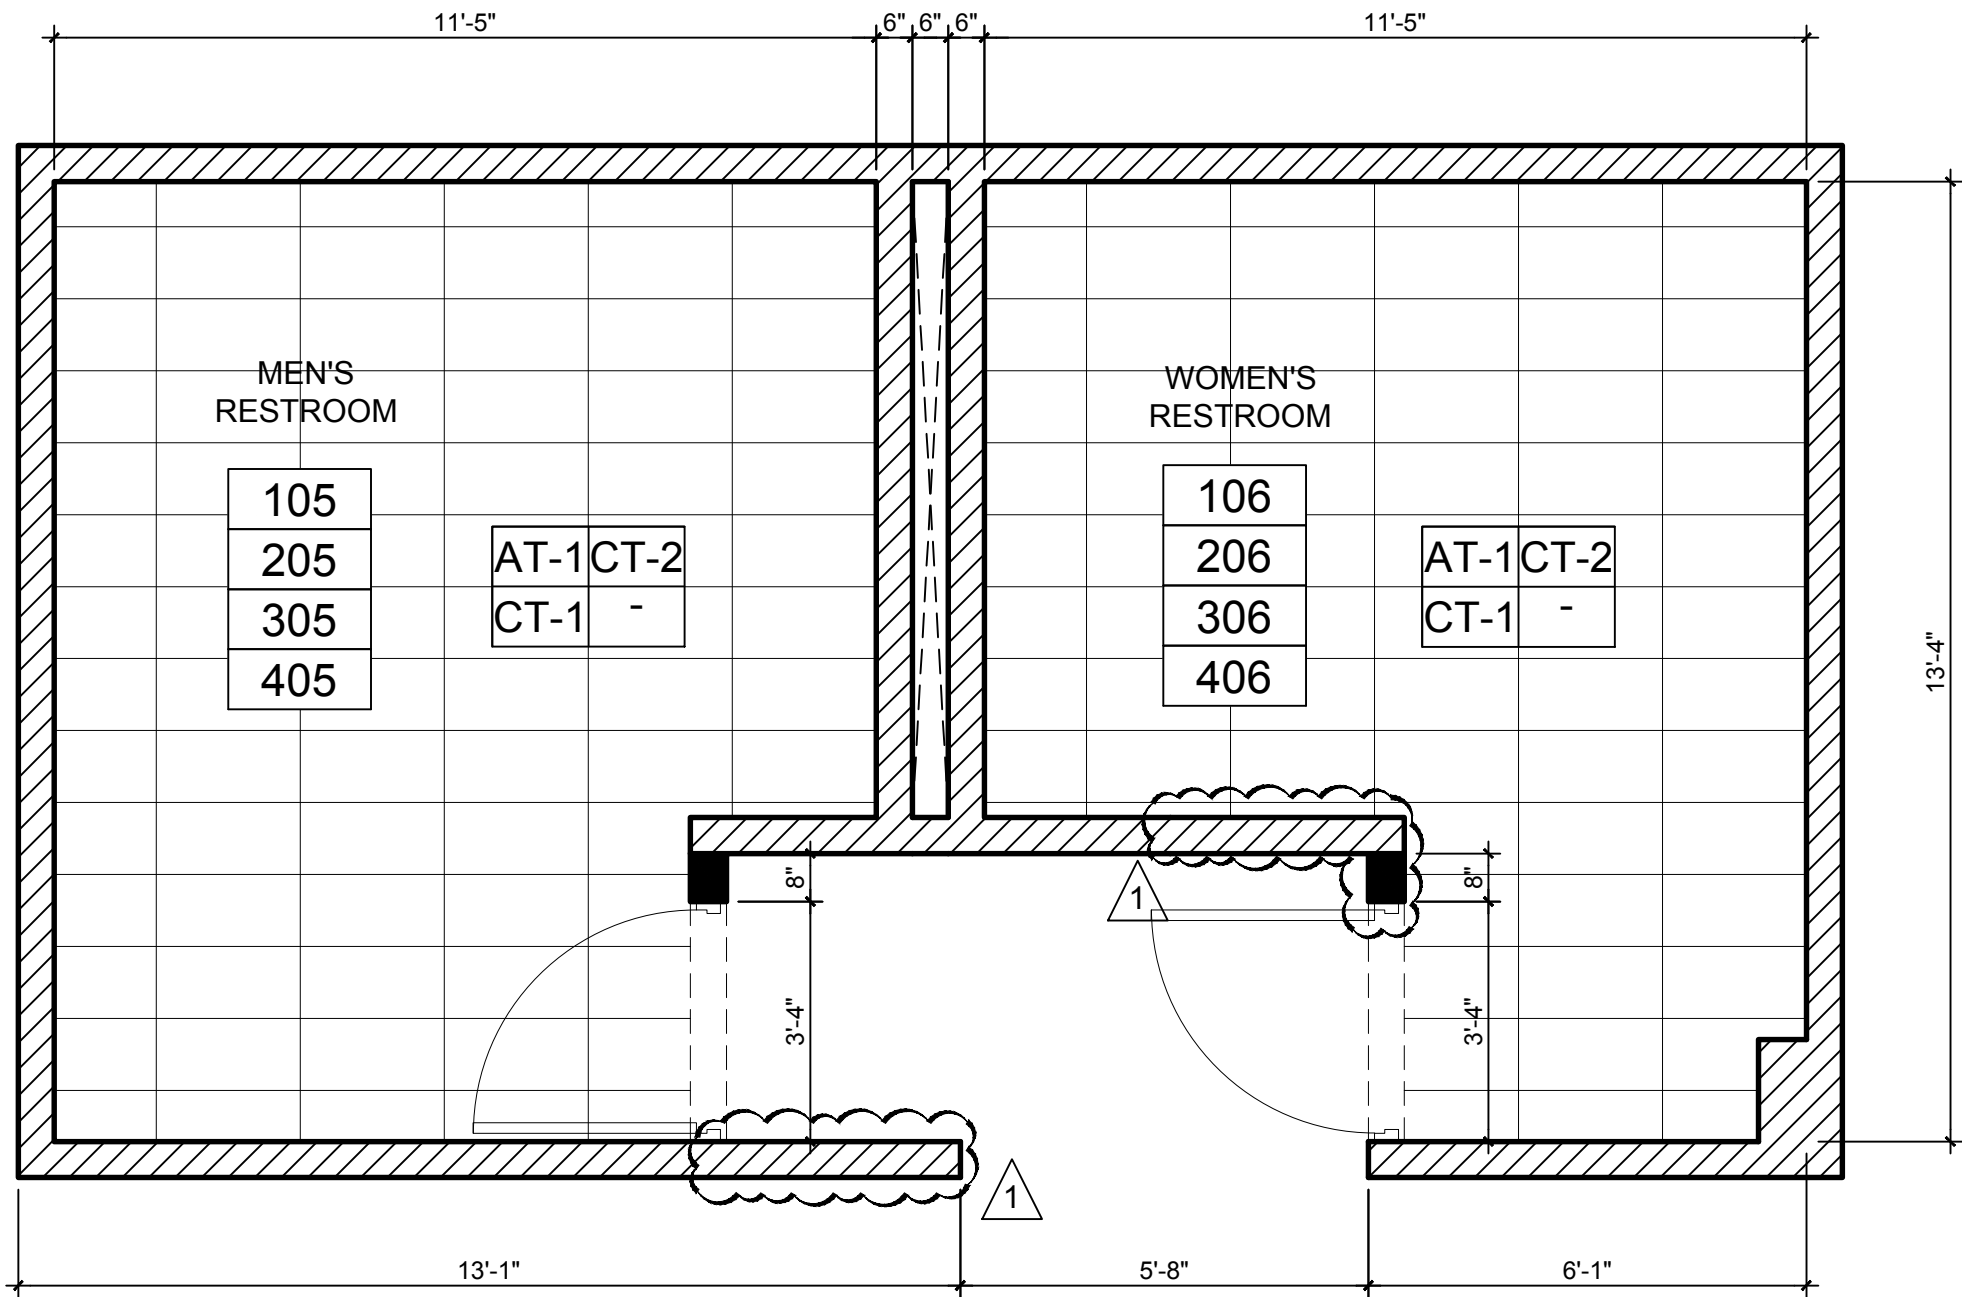

RESTROOM 3 - BASEMENT, 1ST, 2ND & 3RD FLOOR
FINISHES PLAN
SCALE: 3/8"=1'-0"

FINISH SCHEDULE							
MKD	DESCRIPTION	SIZE	STYLE	COLOR	FINISH	MANUFACTURER	LOCATION
ACOUSTIC TILE							
AT-01	ACOSUTIC CEILING TILE	2'-0"X2'-0"X5/8"	CERRAMAGUARD FINE FISSURES 607	WHITE	PRELUDE XL 15/16" FIRE GUARD	ARMSTRONG	ALL RESTROOMS
CERAMIC TILE							
CT-01	CERAMIC TILE (FLOOR)	12" X 24"	NEOCONCRETE COLORBODY PORCELAIN	LIGHT GRAY NE12 & COVE BASE 6" X 12" P-36C9TB	LIGHT POLISHED	DAL TILE	ALL RESTROOMS
CT-02	CERAMIC TILE (WALL)	12" X 24"	COHESION COLORBODY PORCELAIN	BEIGE CO22	POLISHED		ALL RESTROOMS
NOTES: 1. FLOOR TILE MIN. GROUT JOINT RECOMMENDATION: 1/8". 2. ADDITIONAL GROUT RECOMMENDATIONS: FLOOR – 3/16" WHEN MULTIPLE SIZES ARE INSTALLED IN A MODULAR PATTERN AND/OR WHEN TILE WITH A LENGHT 15" O GRATER IS INSTALLED IN A STAGGERED BRICK-JOINT PATTERN. OVERLAP SHOULD NOT EXCEED 33% 3. DCOF WET & LEVEL INTERIOR ≥ .42 / EXTERIOR FLOOR APPLICATIONS ≥ .60 / RAMPS & INCLINES ≥ .65. 2. FOR CT-01 PROVIDE 6"X12" COVE BASE P-36C9TB. GENERAL CONTRACTOR MUST SUBMIT TILE SAMPLE FOR ARCHITECT APPROVAL PRIOR TO ORDERING.							

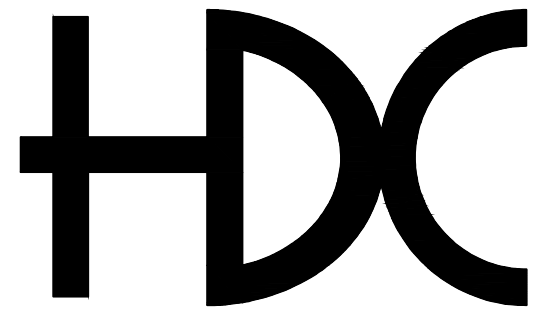

HORACIO DIAZ & ASSOCIATES PSC
CONSULTING ENGINEERS
6 URB. COSTA VERDE
HUMACAO, PUERTO RICO 00791-6036
TEL: (787) 568-1620
E-MAIL: horacio@hdcpr.com



STAMP | SELLO

PROPOSED
RESTROOM
FINISHES FLOOR
PLANS

TITLE SHEET | TITULO DE LA HOJA

HDC BID SET
NOT FOR CONSTRUCTION
APR 24, 2023

BO. TRUJILLO
BAJO, CARR.
PR-3 KM. 12.1
CAROLINA, PR

CENTRO
JUDICIAL DE
CAROLINA
PODER
JUDICIAL DE
PUERTO RICO

PROJECT NAME | NOMBRE DEL PROYECTO

THIS DRAWING AND ITS CONTENTS BELONGS TO
HORACIO DIAZ & ASSOCIATES.
THEY SHALL BE USED AS A REFERENCE DOCUMENT AND
WORKING INSTRUMENT ONLY BY AUTHORIZED PERSONNEL.
ANY TOTAL OR PARTIAL REPRODUCTION OR USE OF
THIS DOCUMENT IS STRICTLY PROHIBITED WITHOUT THE
APPROPRIATED WRITTEN CONSENT OF THIS FIRM AND
SHALL BE RETURNED TO THEIR OFFICE IF REQUIRED.

REVISIONS | REVISIONES

NO.	DESCRIPTION	DATE
01	REVISED FLOOR/WALL TILES & FLOOR PLAN	APR 24, 2023

DRAWN BY | DIBUJADO POR H. DIAZ
CHECK BY | COTEJADO POR H. DIAZ
DESIGN BY | DISEÑADO POR H. DIAZ
APPROVED BY | APROBADO POR H. DIAZ
DATE | FECHA APRIL 24, 2023
SCALE | ESCALA AS SHOWN


PROJECT NO. | NÚM. PROYECTO

2022 39


SHEET NO. | NÚM. DE HOJA

9 OF 15

DRAWING NO. | NÚM. DE DIBUJO

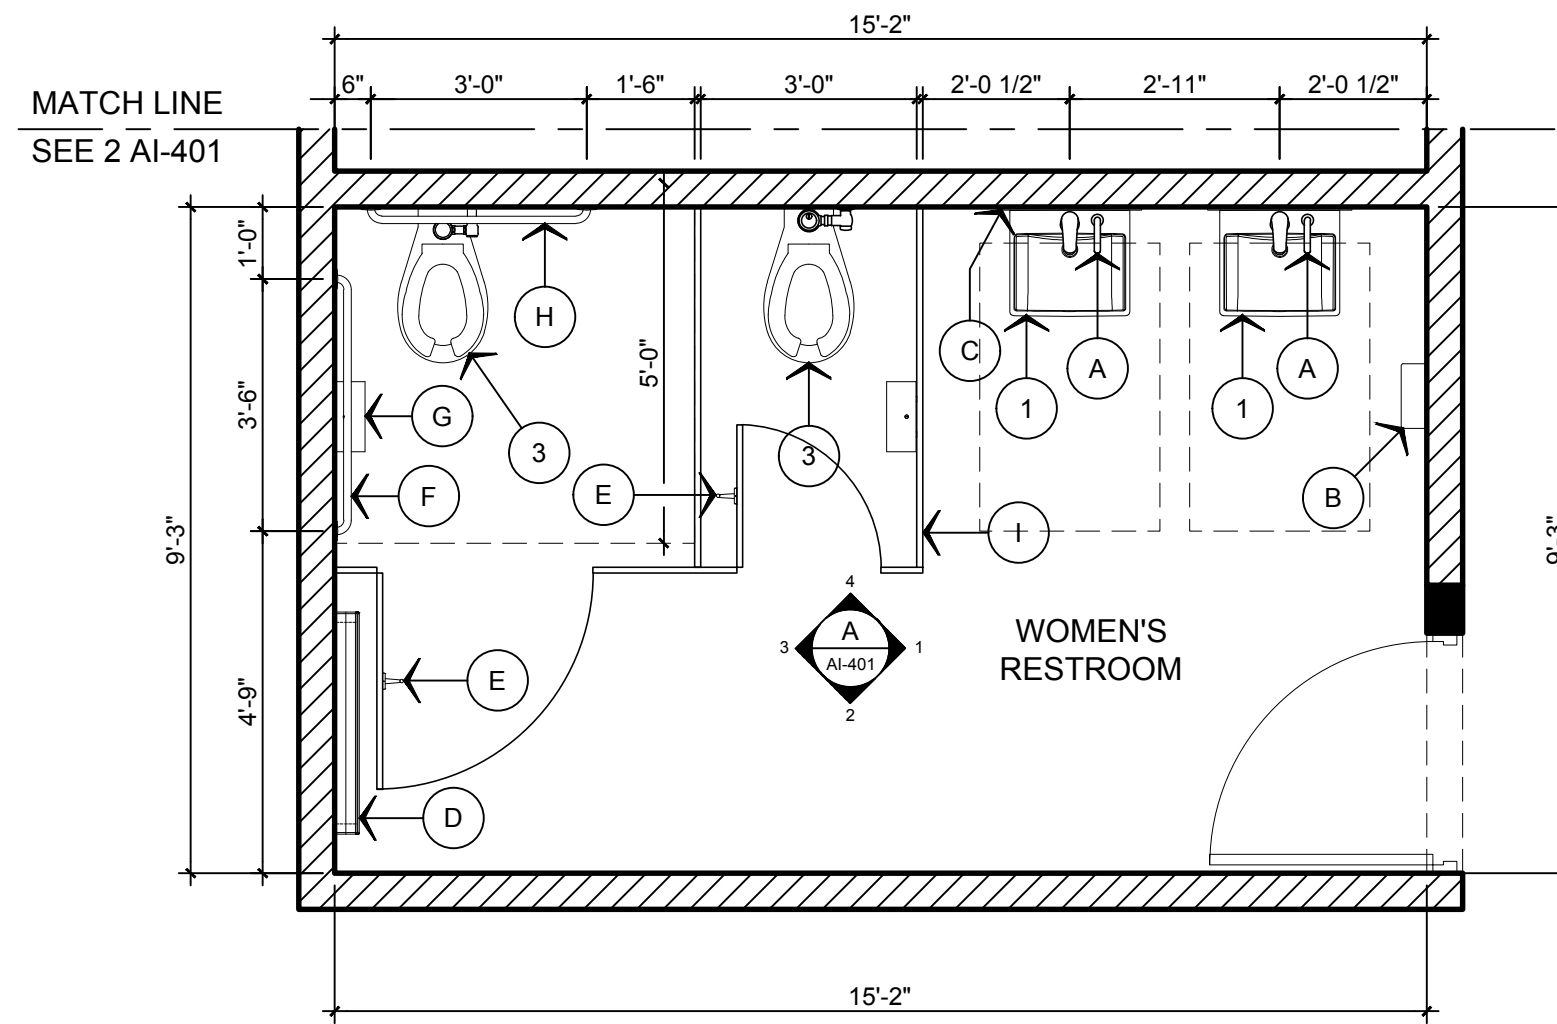


WOMEN'S RESTROOM 1
102, 202, 302 & 402

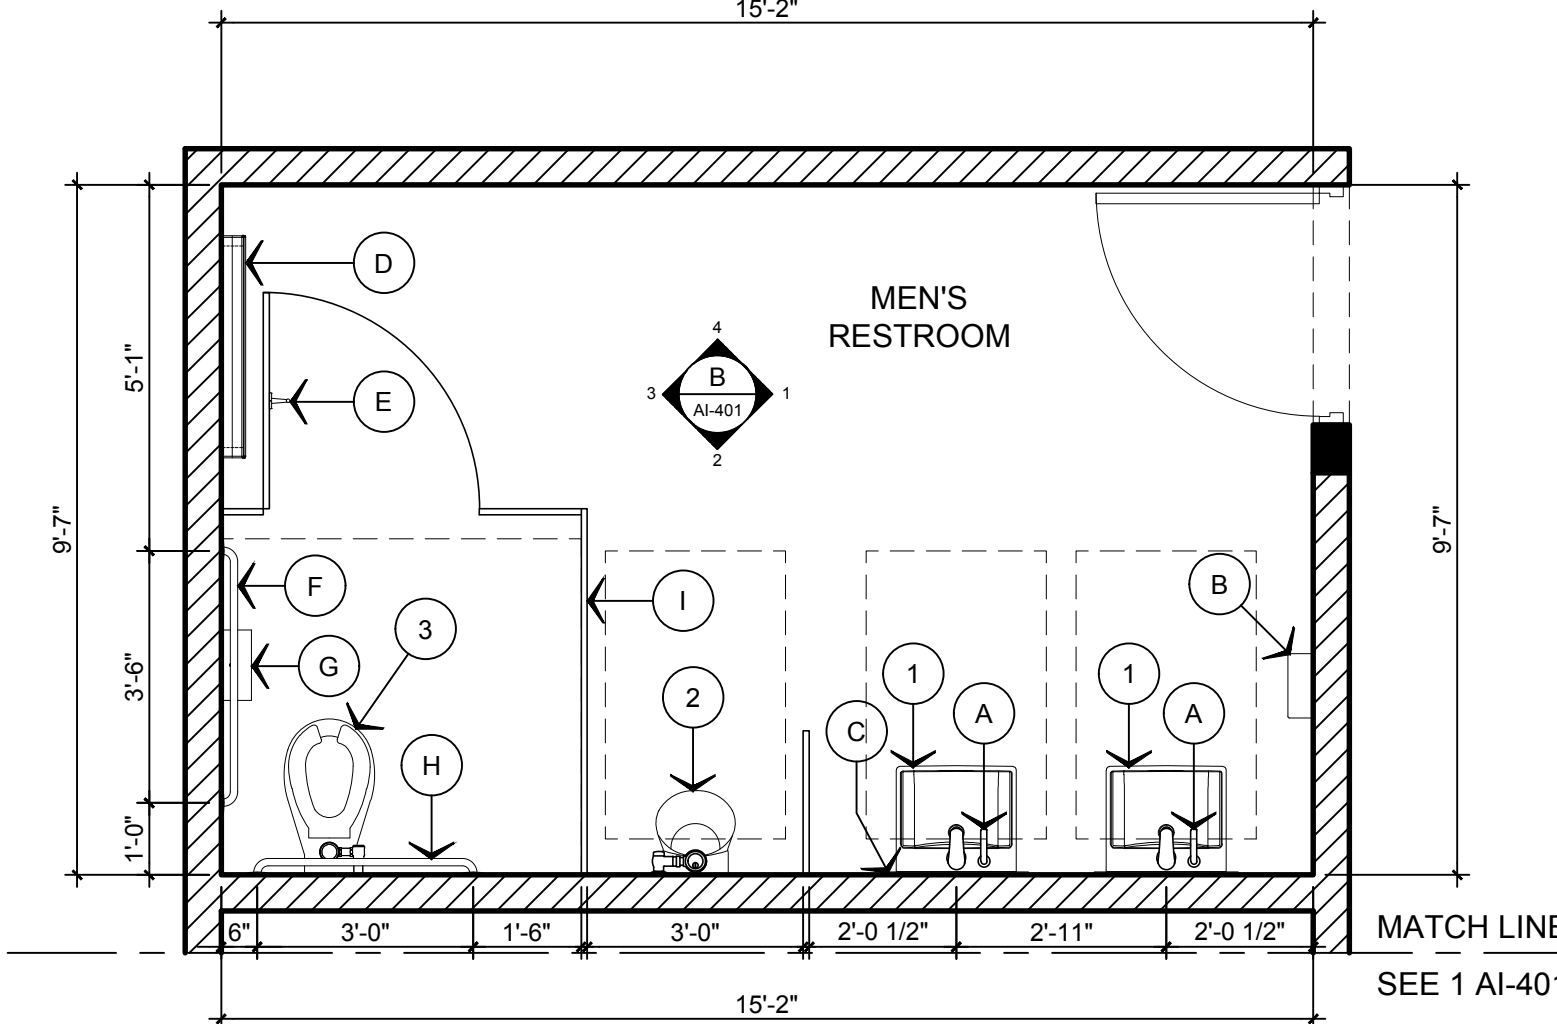


MEN'S RESTROOM 1
101, 201, 301 & 401


BATHROOM ACCESSORIES							
MKD.	DESCRIPTION	STYLE	MODEL NUMBER	MOUNTING HEIGHT	MFR.	REMARKS	LOCATION
A	FOAM SOAP DISPENSER	TOUCHLESS SENSOR- OPERATED	7770100.002	-	AMERICAN STANDARD	POLISHED CHROME FINISH	ALL BATHROOMS
B	PAPER TOWEL DISPENSER & WASTE RECEPTACLE	SURFACE MOUNTED CONVERTIBLE	B-3949	SURFACE MOUNTED SEE ELEV.	BOBRICK	SATIN-FINISH STAINLESS STEEL	ALL BATHROOMS
C	MIRROR	STAINLESS STEEL CHANNEL FRAME	B-165	40" MAX. TO REFLECTIVE SURFACE	BOBRICK	STAINLESS STEEL WITH BRIGHT-POLISHED FINISH	ALL BATHROOMS
D	BABY CHANGING STATION	SURFACE MOUNTED STAINLESS STEEL	9013-9	SEE ELEVATION	AMERICAN SPECIALTIES, INC.	STAINLESS STEEL	ALL BATHROOMS
E	COAT HOOK	HEAVY-DUTY CLOTHES HOOK	B-2116	48" MAX. A.F.F.	BOBRICK	38" TO 40" MAX A.F.F. TO TOP OF BASE	ALL TOILET COMPARTMENT DOORS
F	42" GRAB BAR	STRAIGHT GRAB BAR	B-5806X42	36" MAX. GRIPPING SURFACE	BOBRICK	33" MIN. - 36" MAX. A.F.F. TO TOP GRIPPING SURFACE	ACCESSIBLE TOILET COMPARTMENT
G	TOILET ROLL HOLDER	SURFACE MOUNTED SINGLE JUMBO-TOILET ROLL HOLDER	B-9890	15" MIN. OPERABLE PART A.F.F.	BOBRICK	STAINLESS STEEL, SATIN FINISH	ALL TOILET COMPARTMENTS
H	36" GRAB BAR	STRAIGHT GRAB BAR	B-5806X36	36" MAX. GRIPPING SURFACE A.F.F.	BOBRICK	33" MIN. - 36" MAX. A.F.F. TO TOP GRIPPING SURFACE	ACCESSIBLE TOILET COMPARTMENT
I	TOILET PARTITION	SOLID PLASTIC HDPE	SERIES 400	MIN. 17" - MAX 19" TO TOP OF THE SEAT	BRADLEY	SUBMIT COLOR PALETTE FOR ARCHITECT APPROVAL	ALL BATHROOMS

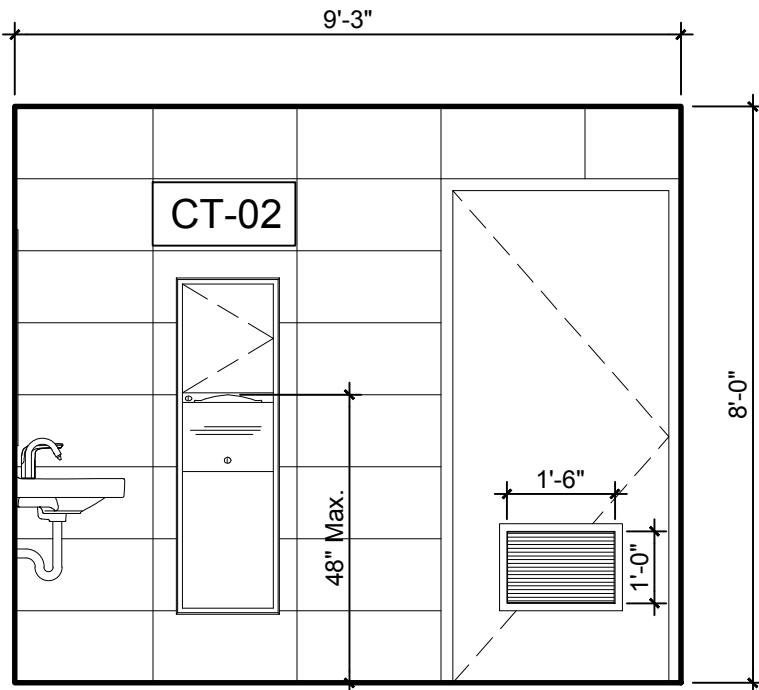


ELEVATION A1

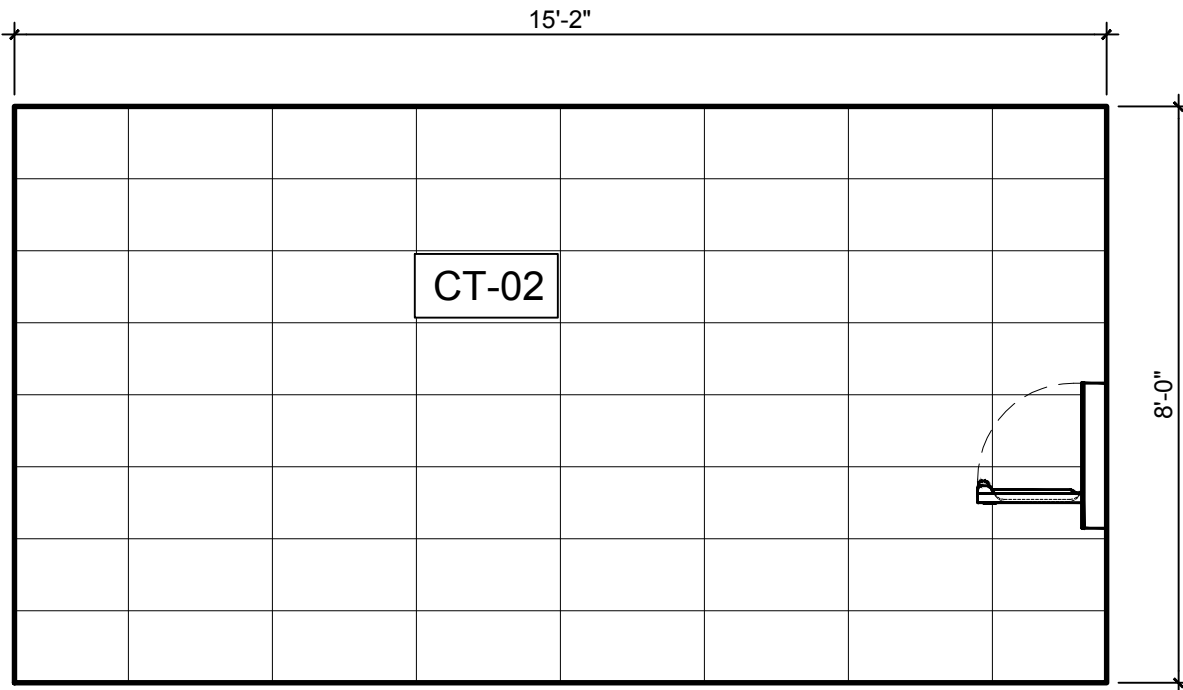


ELEVATION A2

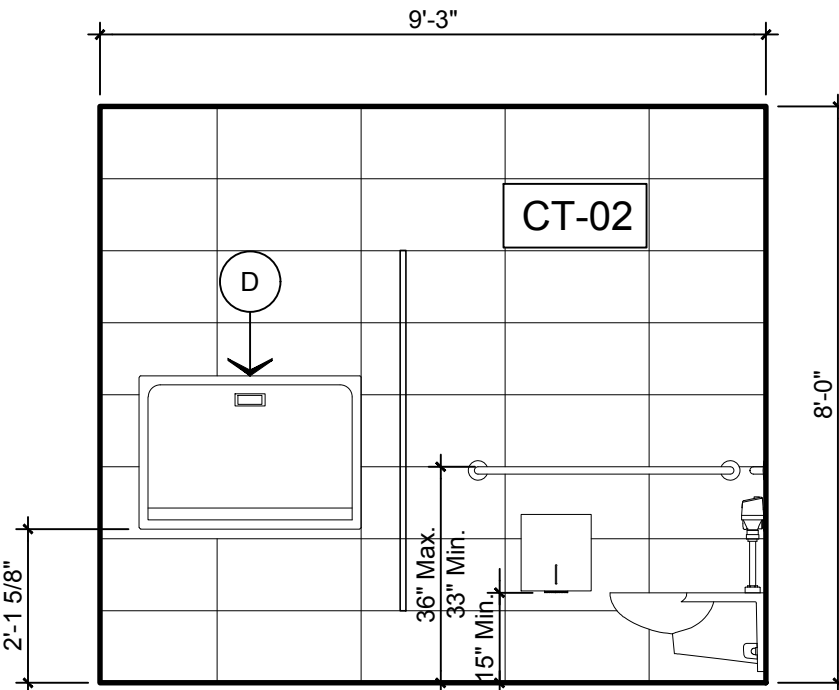


ELEVATION A3

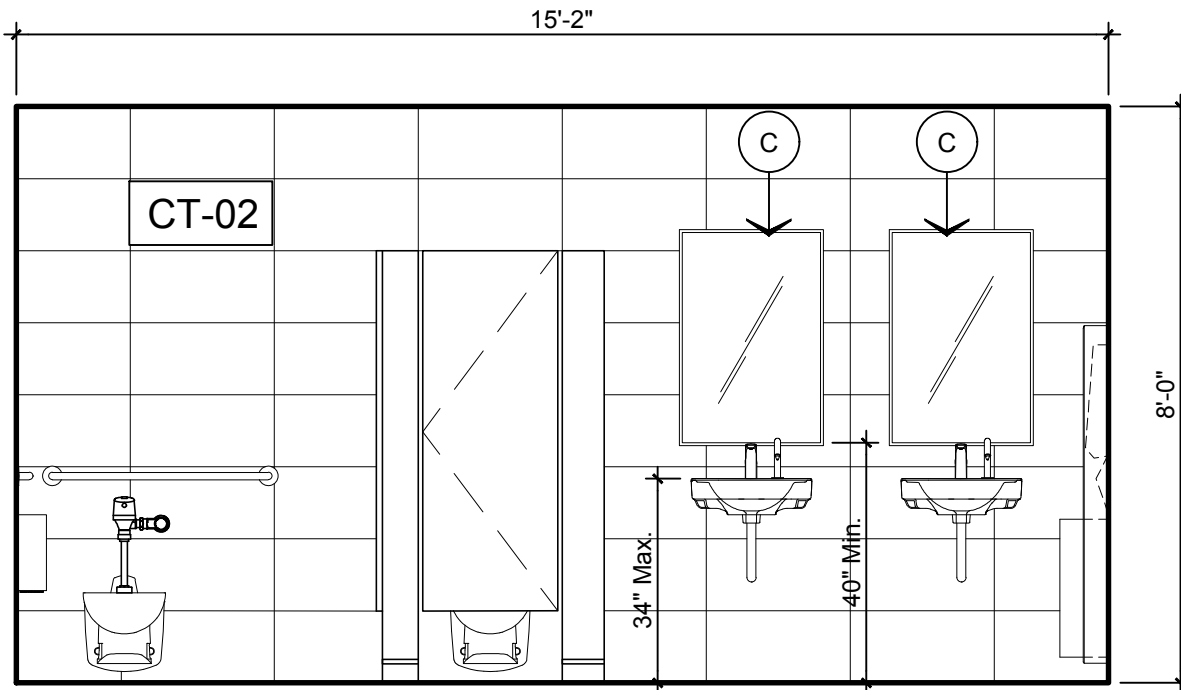


ELEVATION A4

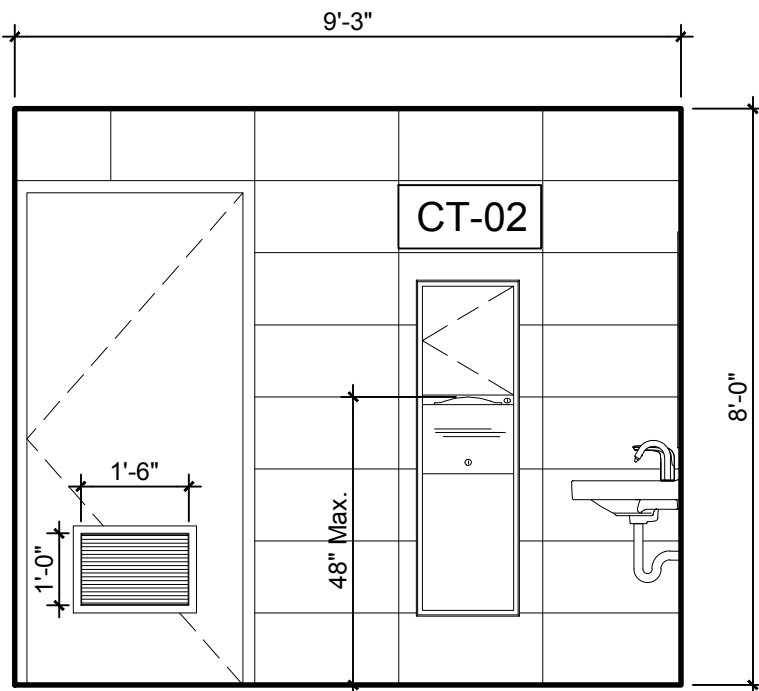


ELEVATION B1

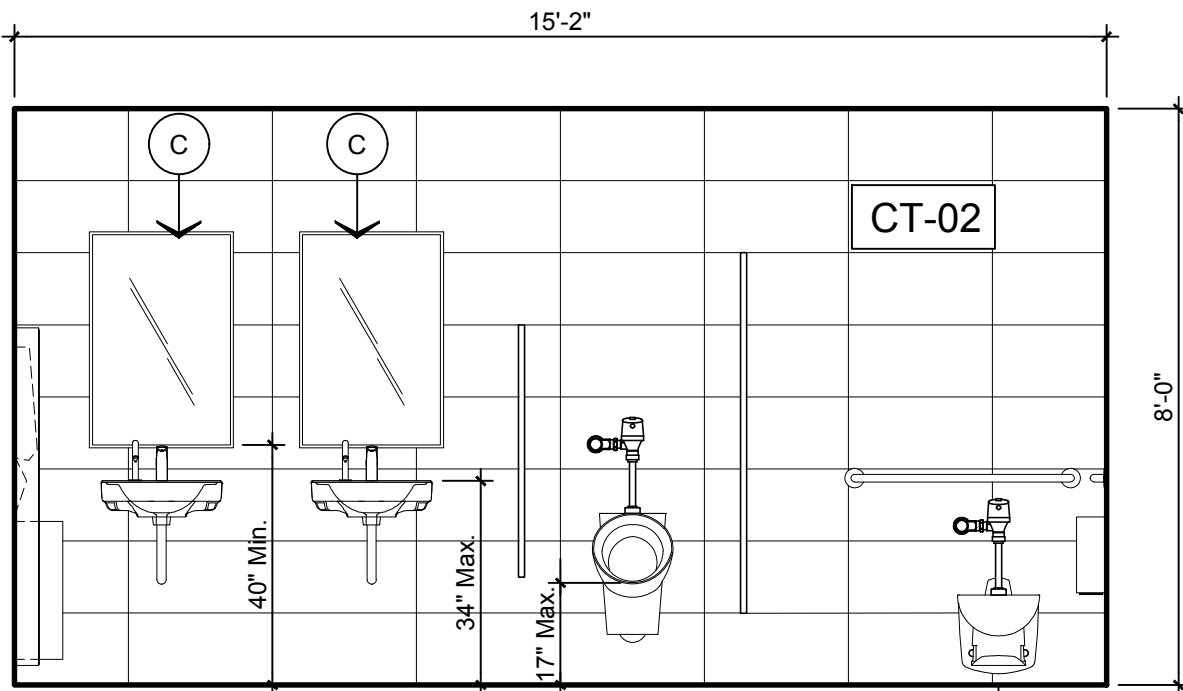


ELEVATION B2

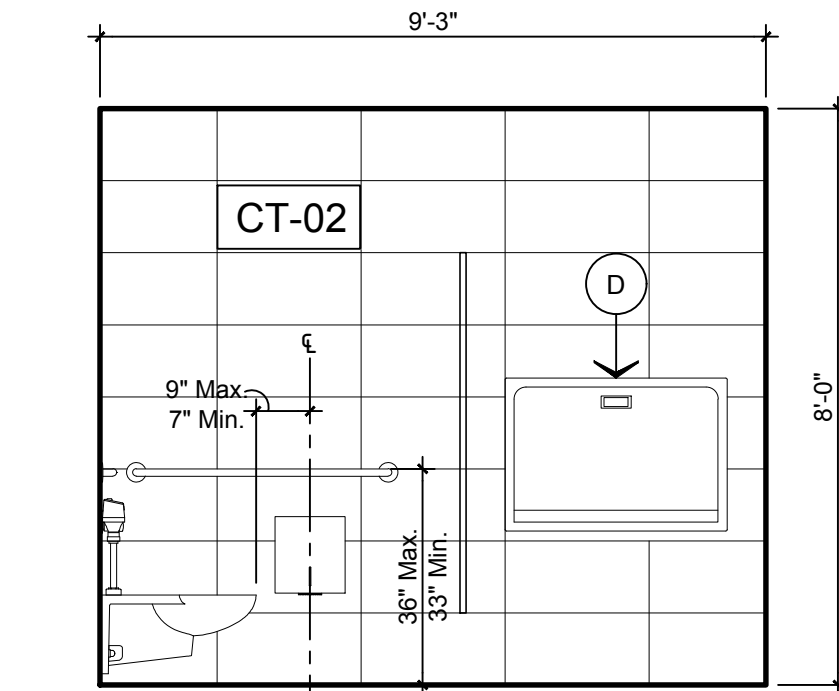

ELEVATION B3

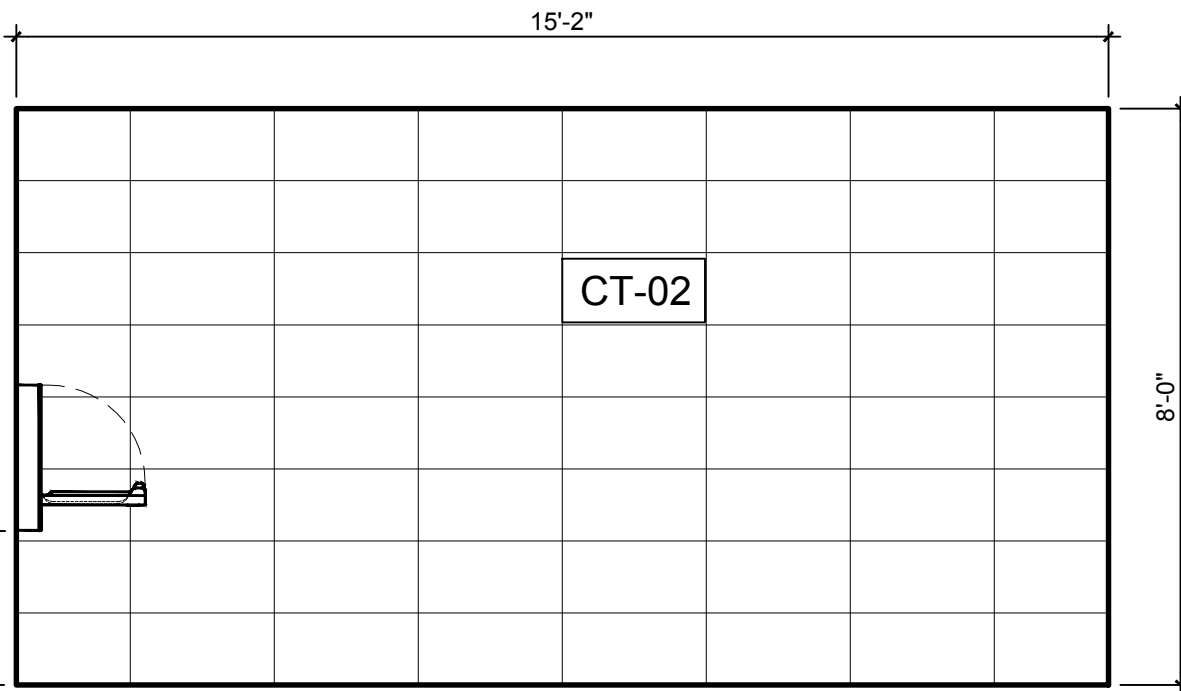

ELEVATION B4

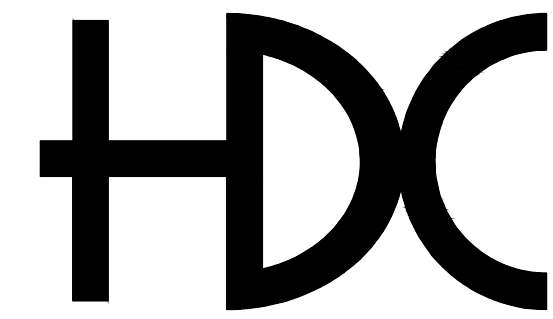

HORACIO DIAZ & ASSOCIATES PSC
CONSULTING ENGINEERS
6 URB. COSTA VERDE
HUMACAO, PUERTO RICO 00791-6036
TEL: (787) 568-1620
E-MAIL: horacio@hdcpr.com



PROPOSED
RESTROOM
ENLARGED FLOOR
PLANS AND
ELEVATIONS

TITLE SHEET | TITULO DE LA HOJA

BID SET
NOT FOR CONSTRUCTION
APR 24, 2023

BO. TRUJILLO
BAJO, CARR.
PR-3 KM. 12.1
CAROLINA, PR

CENTRO
JUDICIAL DE
CAROLINA
PODER
JUDICIAL DE
PUERTO RICO

PROJECT NAME | NOMBRE DEL PROYECTO


THIS DRAWING AND ITS CONTENTS BELONGS TO
HORACIO DIAZ & ASSOCIATES.
THEY SHALL BE USED AS A REFERENCE DOCUMENT AND
WORKING INSTRUMENT ONLY BY AUTHORIZED PERSONNEL.
ANY TOTAL OR PARTIAL REPRODUCTION OR USE OF
THIS DOCUMENT IS STRICTLY PROHIBITED WITHOUT THE
APPROPRIATED WRITTEN CONSENT OF THIS FIRM AND
SHALL BE RETURNED TO THEIR OFFICE IF REQUIRED.

REVISIONS REVISIONES		
NO.	DESCRIPTION	DATE

DRAWN BY | DIBUJADO POR: H. DIAZ
DESIGN BY | DISEÑADO POR: H. DIAZ
DATE | FECHA: APRIL 24, 2023
CHECK BY | COTEJADO POR: H. DIAZ
APPROVED BY | APROBADO POR: H. DIAZ
SCALE | ESCALA: AS SHOWN

PROJECT NO. | NÚM. PROYECTO: 2022 39
SHEET NO. | NÚM. DE HOJA: 10 OF 15
DRAWING NO. | NÚM. DE DIBUJO


AI-401

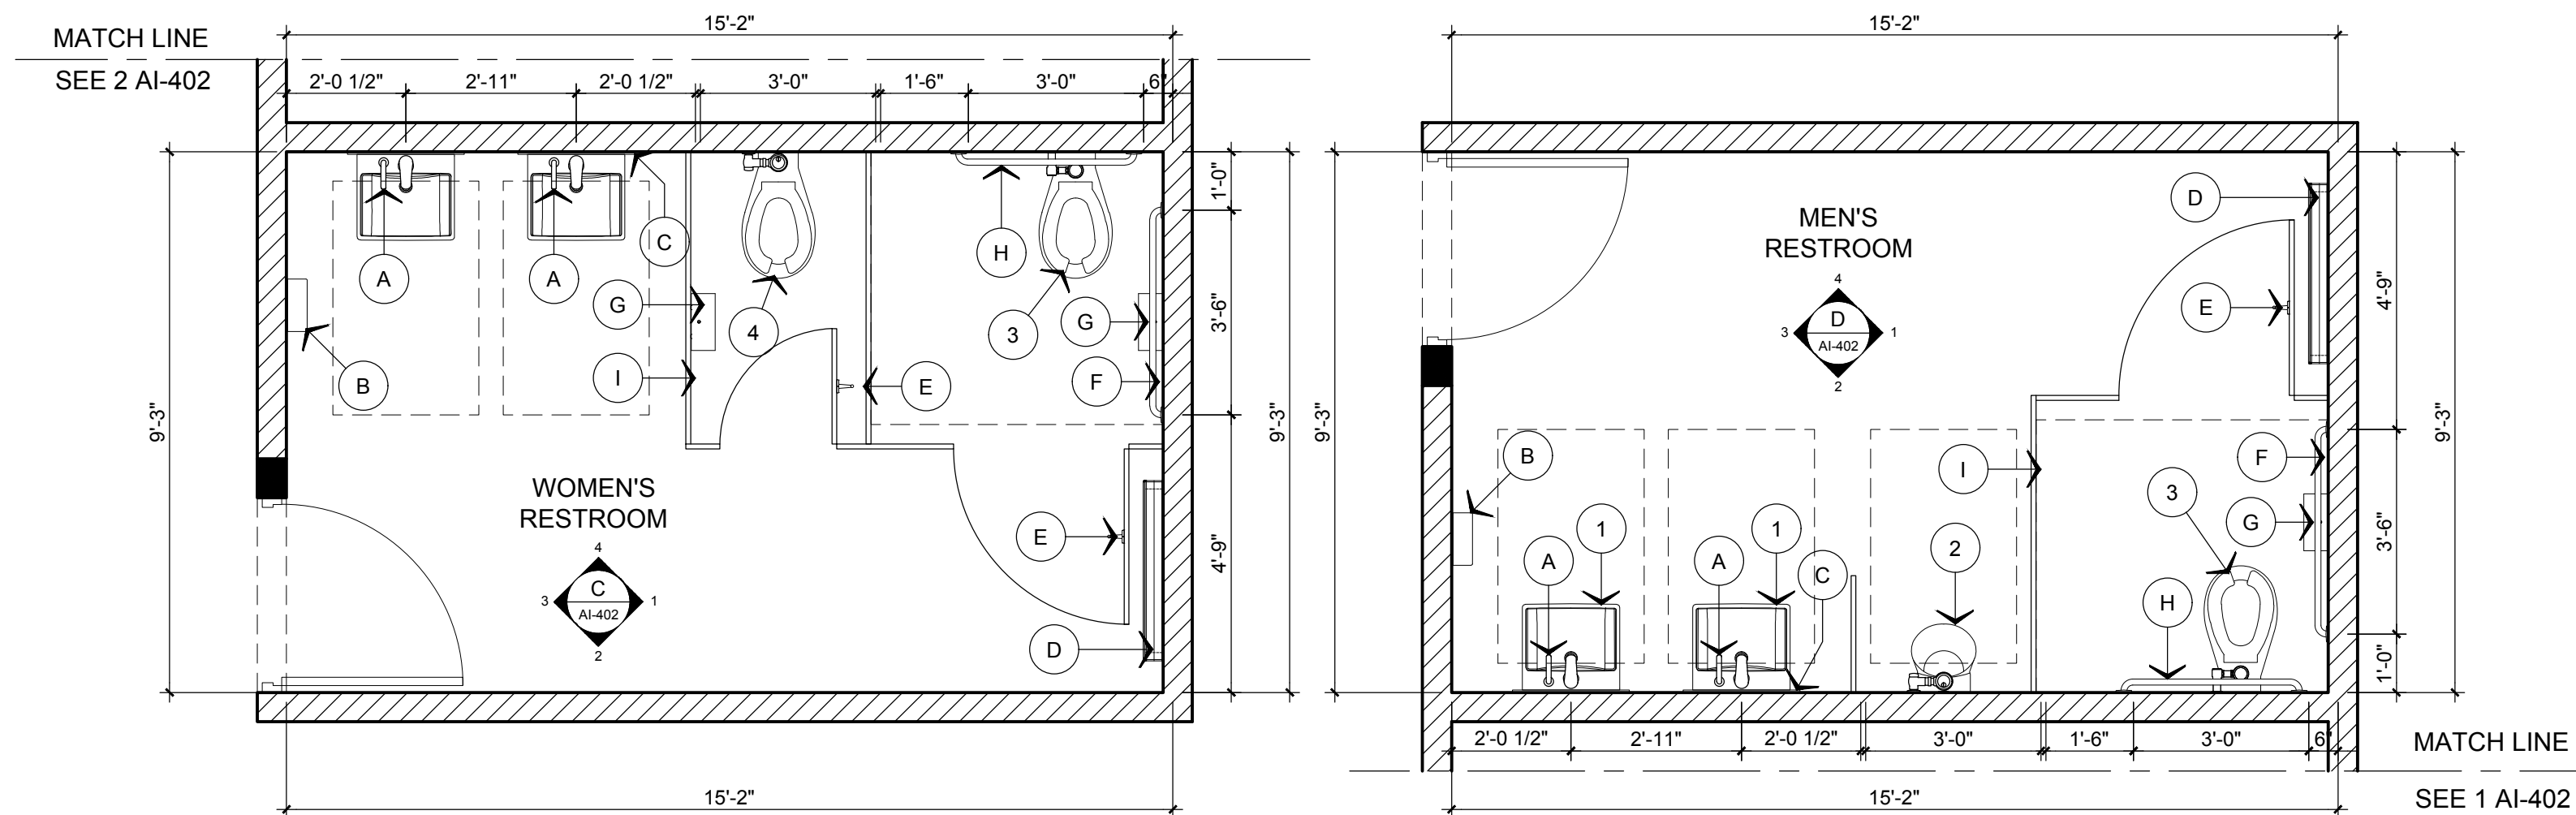


WOMEN'S RESTROOM 2
104, 204, 304 & 404 FLOOR
SCALE: 3/8"=1'-0"

MEN'S RESTROOM 2
103, 203, 303 & 403
SCALE: 3/8"=1'-0"


BATHROOM ACCESSORIES							
MKD.	DESCRIPTION	STYLE	MODEL NUMBER	MOUNTING HEIGHT	MFR.	REMARKS	LOCATION
A	FOAM SOAP DISPENSER	TOUCHLESS SENSOR- OPERATED	7770100.002	-	AMERICAN STANDARD	POLISHED CHROME FINISH	ALL BATHROOMS
B	PAPER TOWEL DISPENSER & WASTE RECEPTACLE	SURFACE MOUNTED CONVERTIBLE	B-3949	SURFACE MOUNTED SEE ELEV.	BOBRICK	SATIN-FINISH STAINLESS STEEL	ALL BATHROOMS
C	MIRROR	STAINLESS STEEL CHANNEL FRAME	B-165	48" MAX. TO REFLECTIVE SURFACE	BOBRICK	STAINLESS STEEL WITH BRIGHT-POLISHED FINISH	ALL BATHROOMS
D	BABY CHANGING STATION	SURFACE MOUNTED STAINLESS STEEL	9013-9	SEE ELEVATION	AMERICAN SPECIALTIES, INC.	STAINLESS STEEL	ALL BATHROOMS
E	COAT HOOK	HEAVY-DUTY CLOTHES HOOK	B-2116	48" MAX. A.F.F.	BOBRICK	38" TO 40" MAX A.F.F. TO TOP OF BASE	ALL TOILET COMPARTMENT DOORS
F	42" GRAB BAR	STRAIGHT GRAB BAR	B-5806X42	36" MAX. GRIPPING SURFACE	BOBRICK	33" MIN. - 36" MAX. A.F.F. TO TOP GRIPPING SURFACE	ACCESSIBLE TOILET COMPARTMENT
G	TOILET ROLL HOLDER	SURFACE MOUNTED SINGLE JUMBO-TOILET ROLL HOLDER	B-9890	15" MIN. OPERABLE PART A.F.F.	BOBRICK	STAINLESS STEEL, SATIN FINISH	ALL TOILET COMPARTMENTS
H	36" GRAB BAR	STRAIGHT GRAB BAR	B-5806X36	36" MAX. GRIPPING SURFACE A.F.F.	BOBRICK	33" MIN. - 36" MAX. A.F.F. TO TOP GRIPPING SURFACE	ACCESSIBLE TOILET COMPARTMENT
I	TOILET PARTITION	SOLID PLASTIC HDPE	SERIES 400	MIN. 17" - MAX 19" TO TOP OF THE SEAT	BRADLEY	SUBMIT COLOR PALETTE FOR ARCHITECT APPROVAL	ALL BATHROOMS

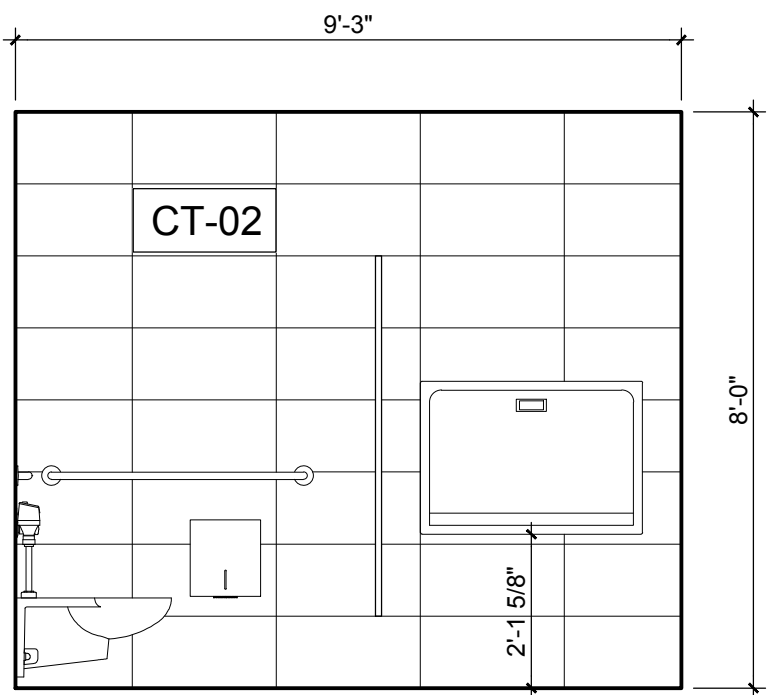


ELEVATION C1
SCALE: 3/8"=1'-0"

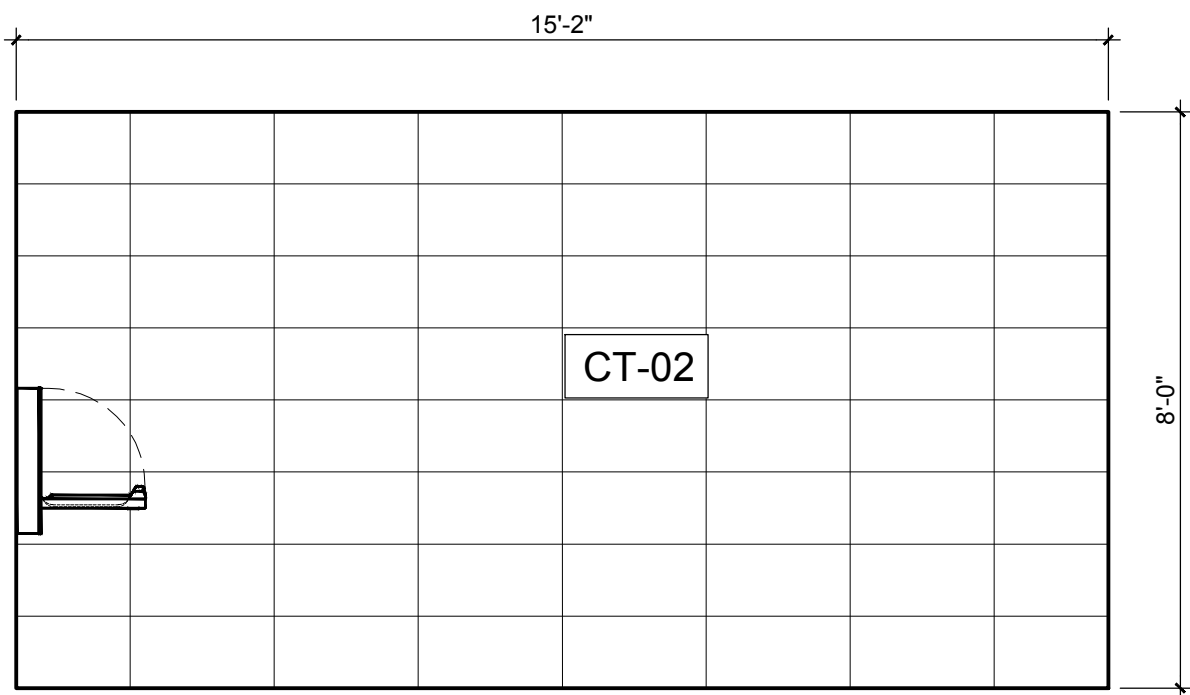


ELEVATION C2
SCALE: 3/8"=1'-0"

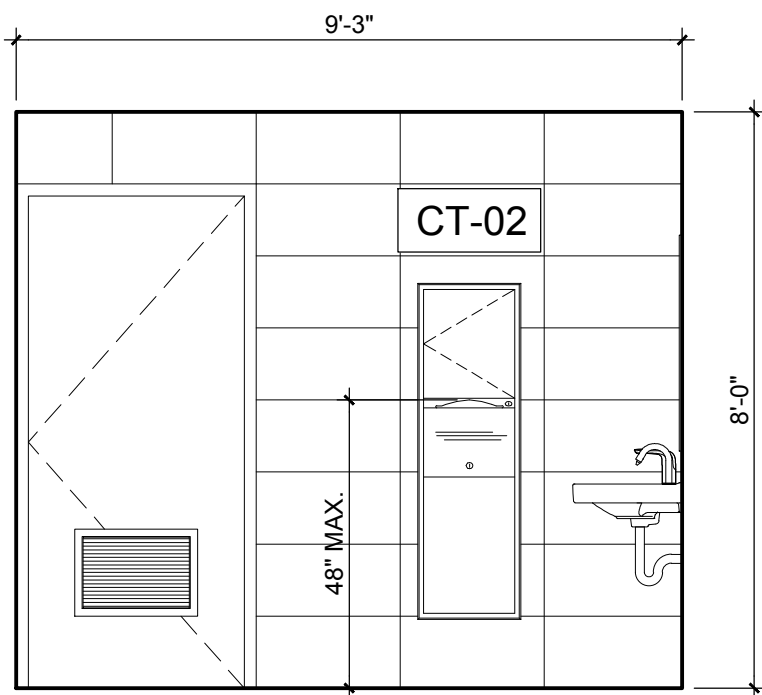


ELEVATION C3
SCALE: 3/8"=1'-0"

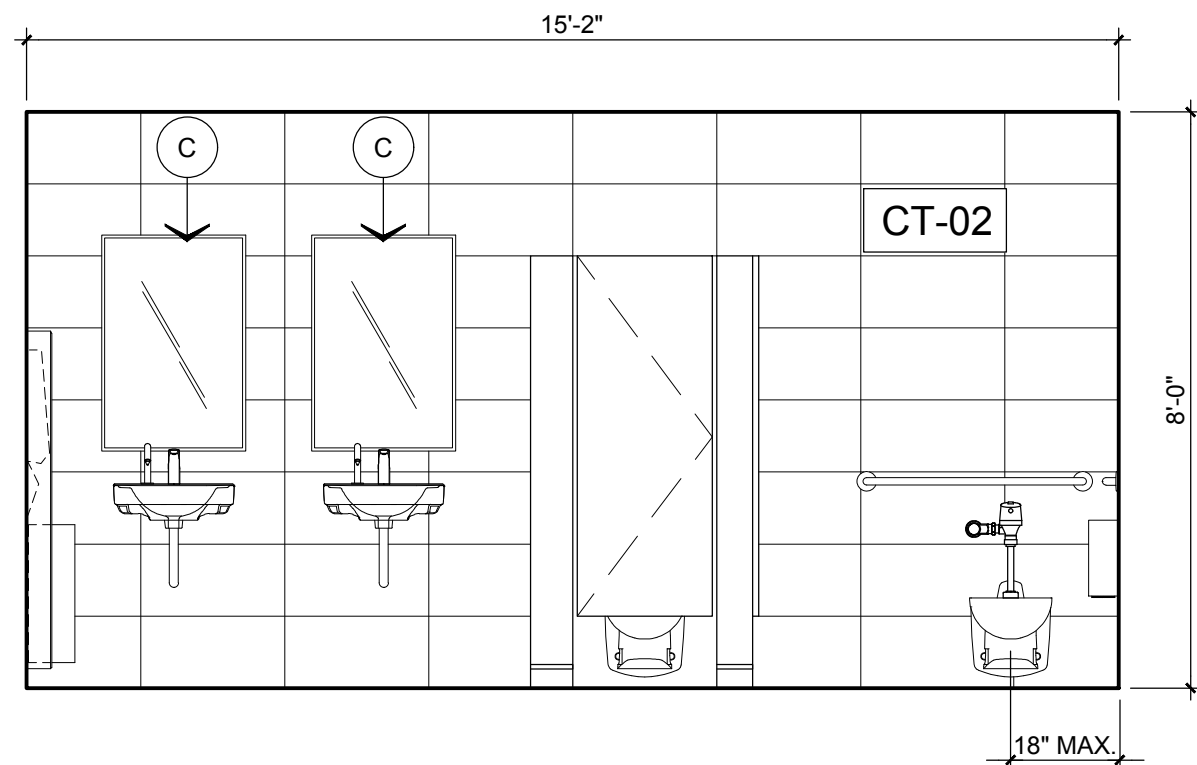


ELEVATION C4
SCALE: 3/8"=1'-0"

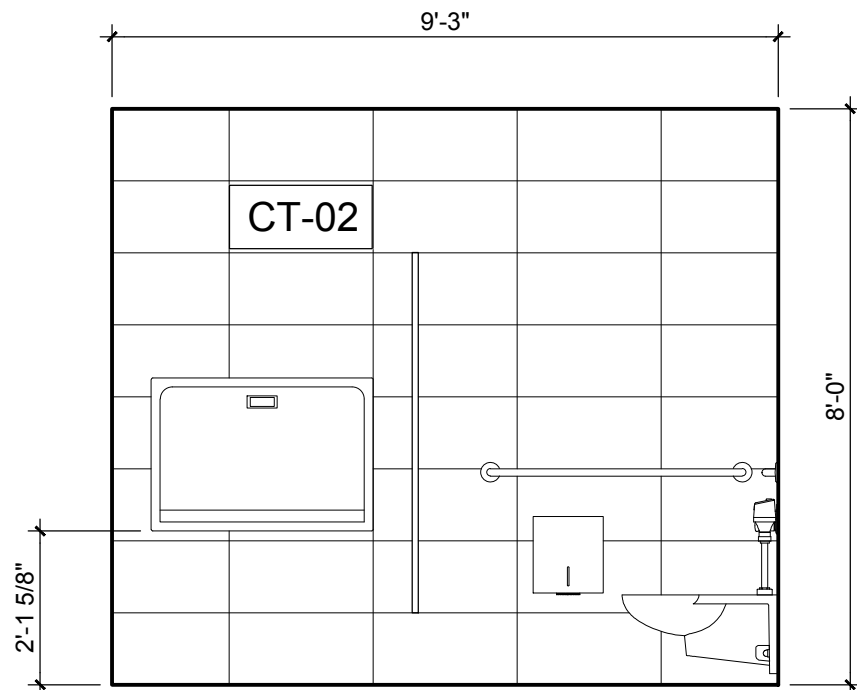


ELEVATION D1
SCALE: 3/8"=1'-0"

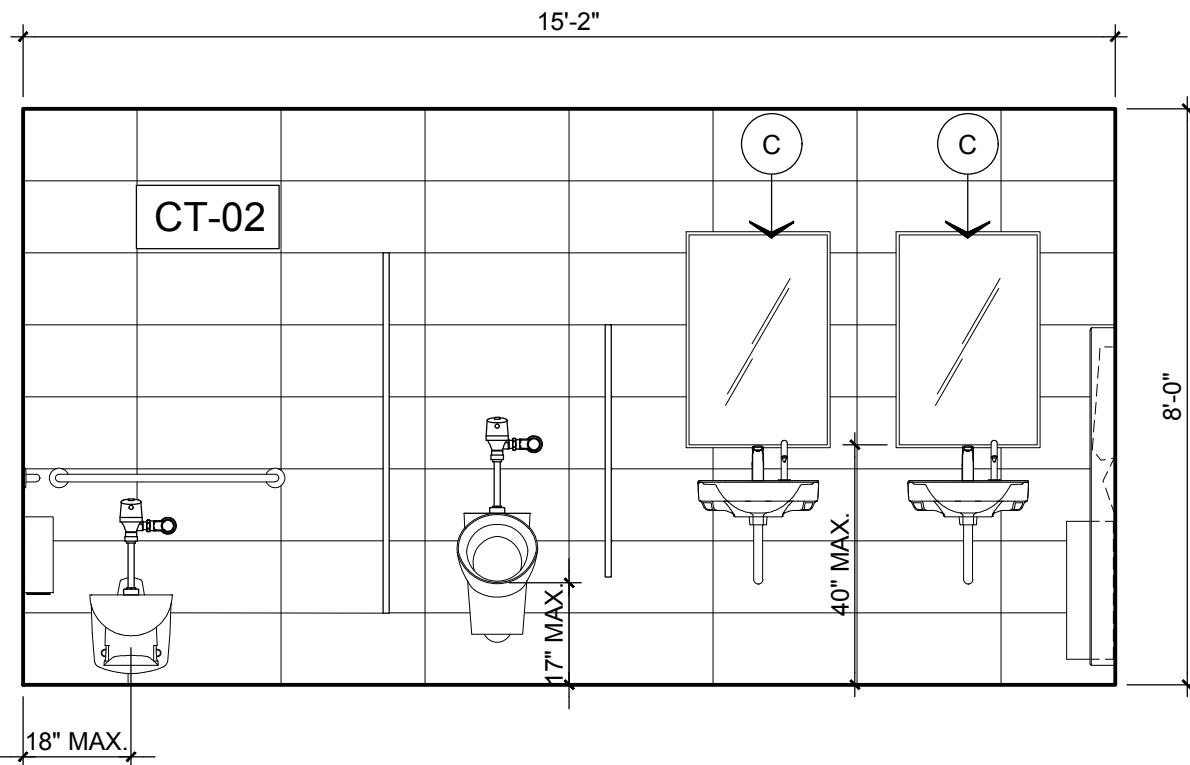


ELEVATION D2
SCALE: 3/8"=1'-0"

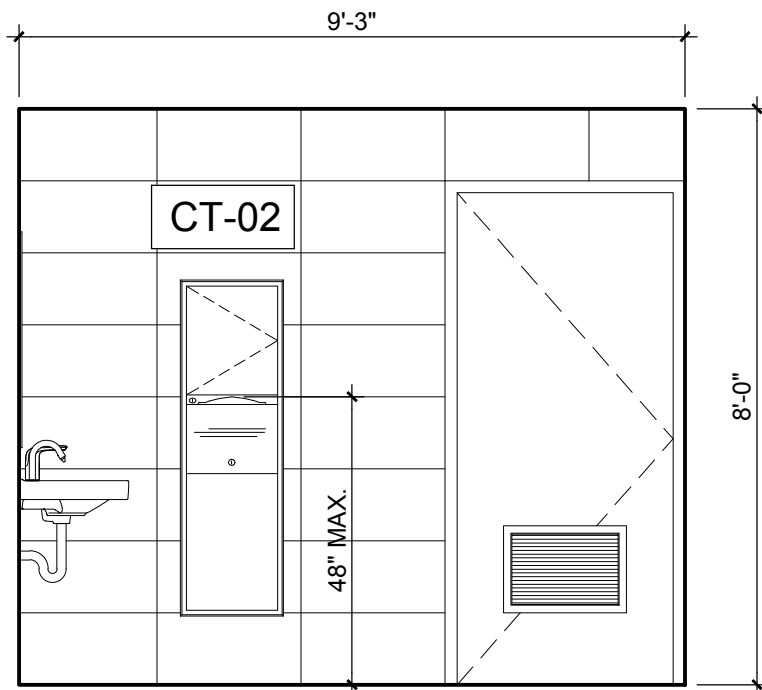

ELEVATION D3
SCALE: 3/8"=1'-0"

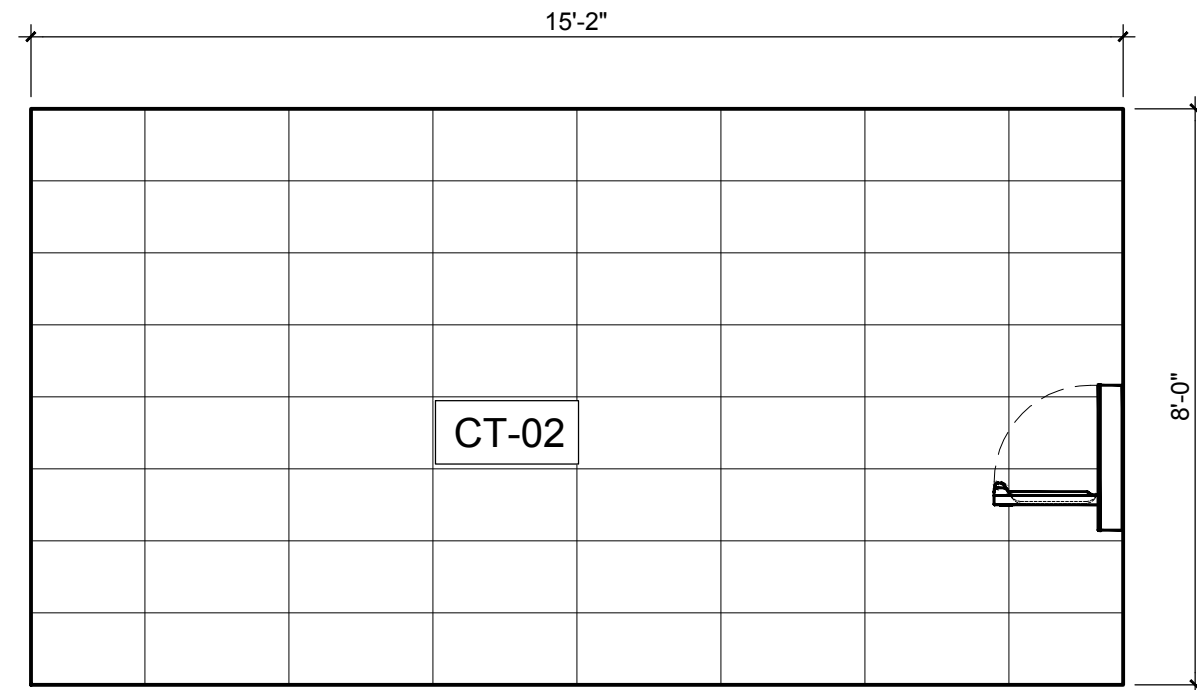

ELEVATION D4
SCALE: 3/8"=1'-0"

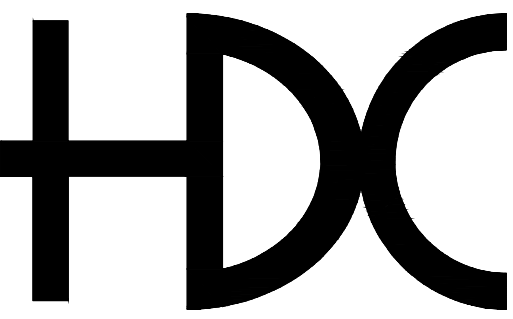

HORACIO DIAZ & ASSOCIATES PSC
CONSULTING ENGINEERS

6 URB. COSTA VERDE
HUMACAO, PUERTO RICO 00791-6036
TEL: (787) 568-1620
E-MAIL: horacio@hdcpr.com



STAMP | SELLO

PROPOSED
RESTROOM
ENLARGED FLOOR
PLANS AND
ELEVATIONS

TITLE SHEET | TITULO DE LA HOJA



BO. TRUJILLO
BAJO, CARR.
PR-3 KM. 12.1
CAROLINA, PR

CENTRO
JUDICIAL DE
CAROLINA
PODER
JUDICIAL DE
PUERTO RICO

PROJECT NAME | NOMBRE DEL PROYECTO

THIS DRAWING AND ITS CONTENTS BELONGS TO
HORACIO DIAZ & ASSOCIATES.
THEY SHALL BE USED AS A REFERENCE DOCUMENT AND
WORKING INSTRUMENT ONLY BY AUTHORIZED PERSONNEL.
ANY TOTAL OR PARTIAL REPRODUCTION OR USE OF
THIS DOCUMENT IS STRICTLY PROHIBITED WITHOUT THE
APPROPRIATED WRITTEN CONSENT OF THIS FIRM AND
SHALL BE RETURNED TO THEIR OFFICE IF REQUIRED.

REVISIONS | REVISIONES

NO.	DESCRIPTION	DATE

DRAWN BY | DIBUJADO POR: H. DIAZ
DESIGN BY | DISEÑADO POR: H. DIAZ
DATE | FECHA: APRIL 24, 2023
CHECK BY | COTEJADO POR: H. DIAZ
APPROVED BY | APROBADO POR: H. DIAZ
SCALE | ESCALA: AS SHOWN

PROJECT NO. | NÚM. PROYECTO


2022 39

SHEET NO. | NÚM. DE HOJA


11 OF 15

DRAWING NO. | NÚM. DE DIBUJO

AI-402

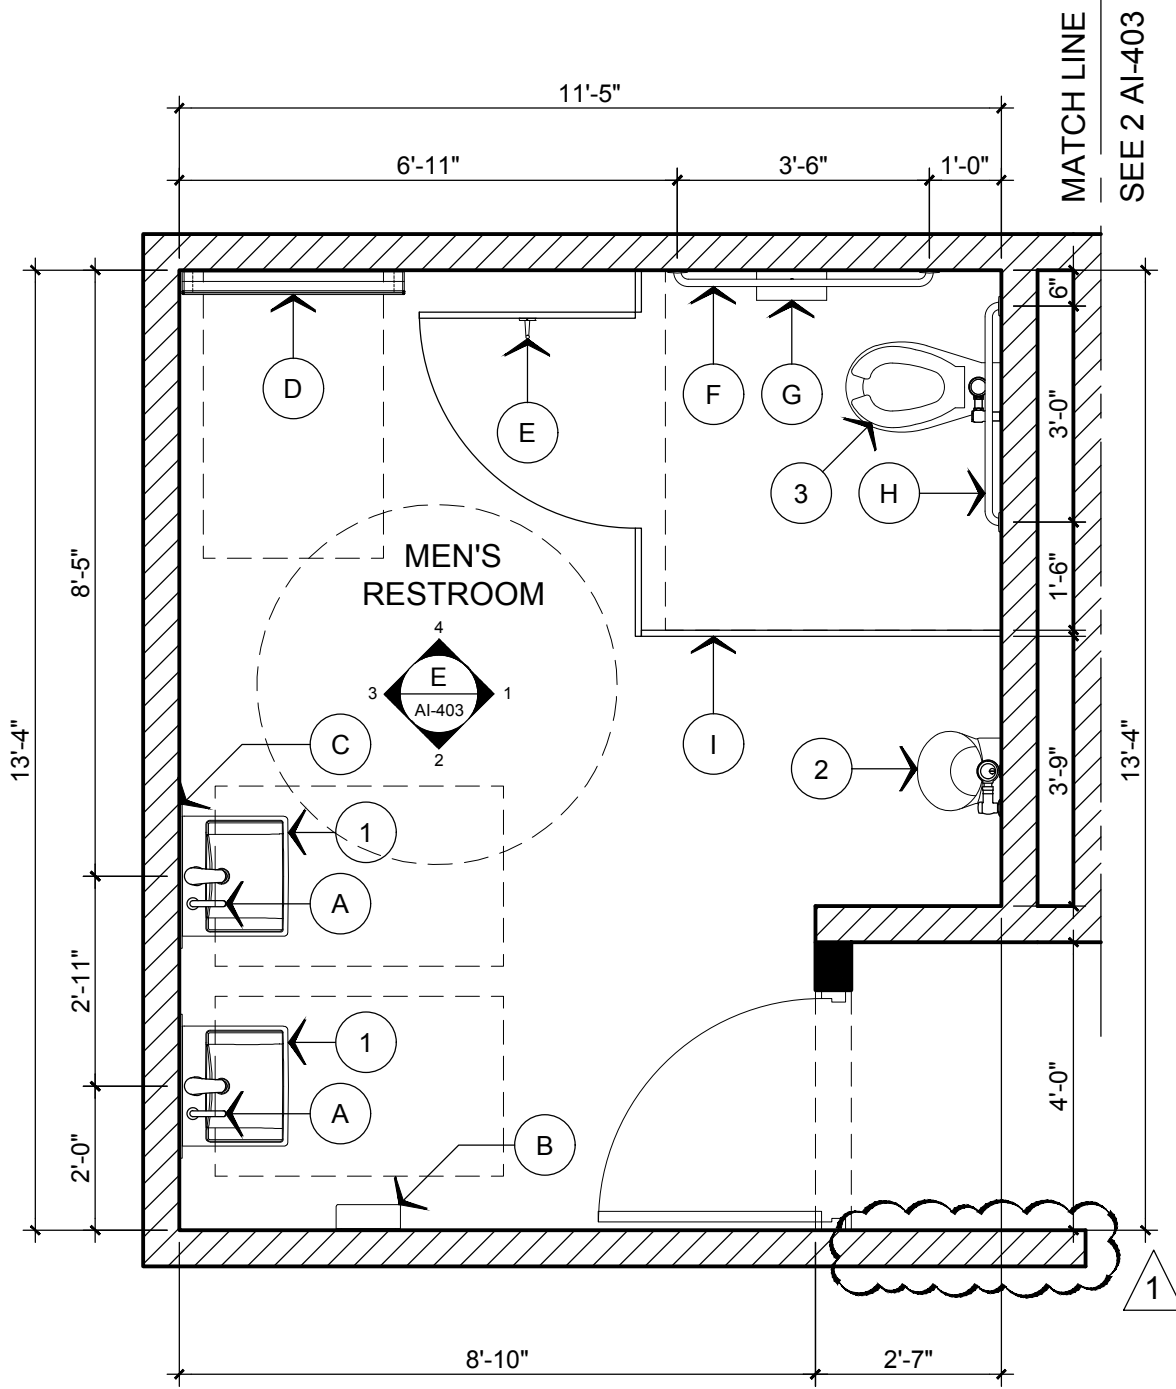


MEN'S RESTROOM 3
105, 205, 305 & 405

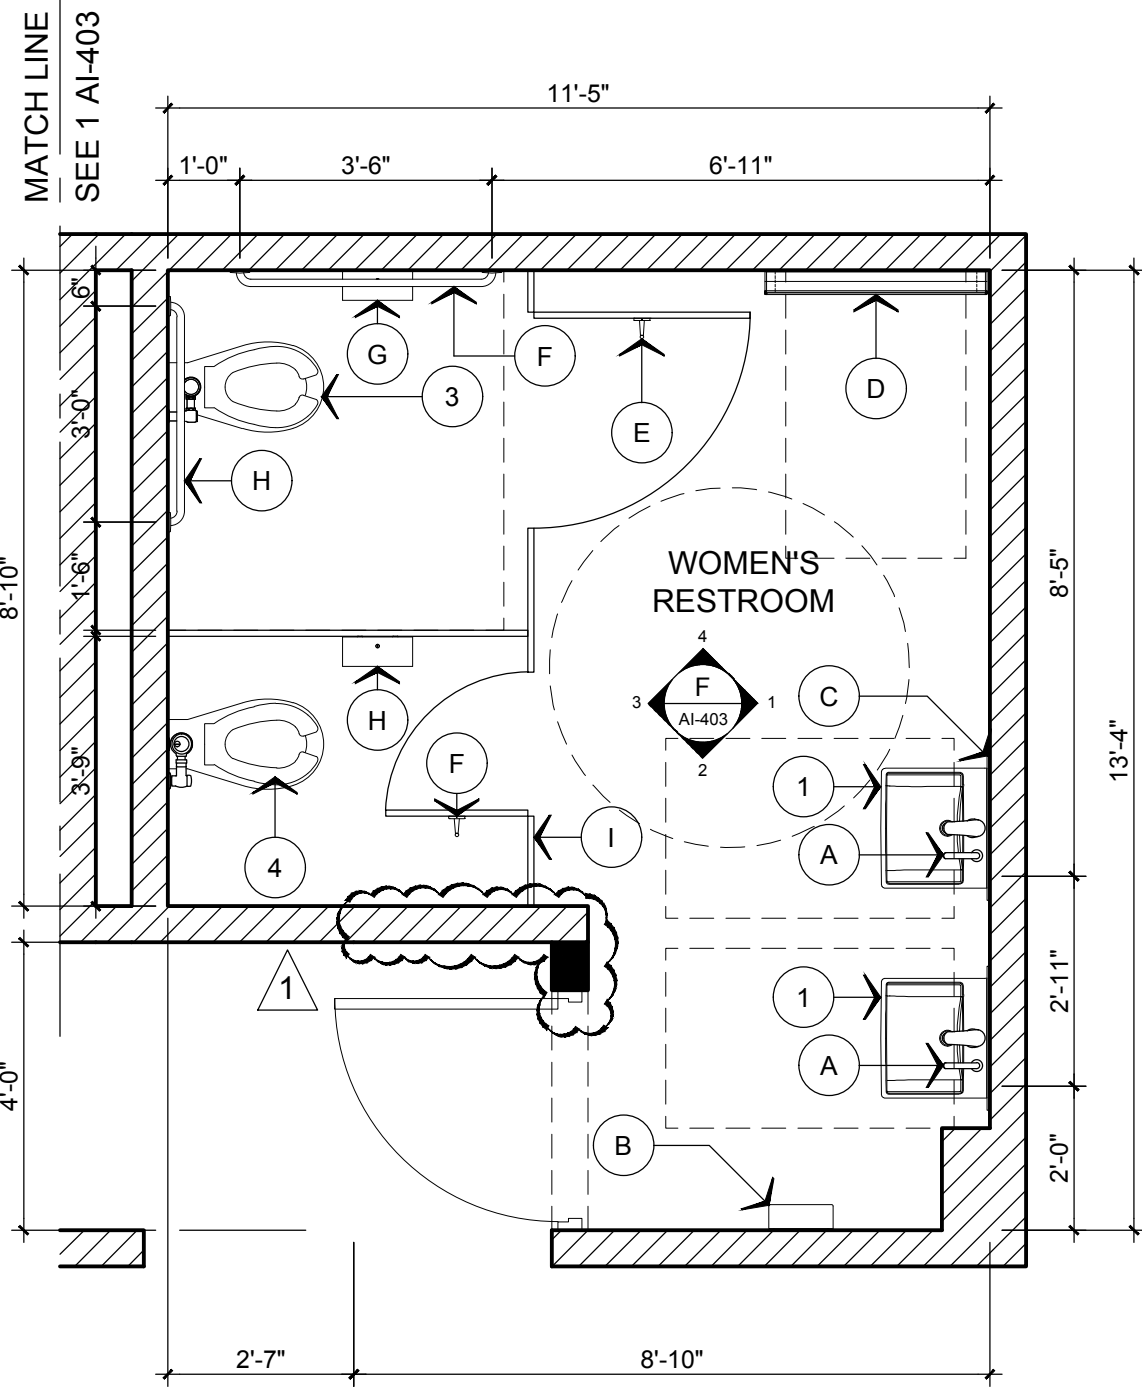


WOMEN'S RESTROOM 3
106, 206, 306 & 406


BATHROOM ACCESSORIES							
MKD.	DESCRIPTION	STYLE	MODEL NUMBER	MOUNTING HEIGHT	MFR.	REMARKS	LOCATION
A	FOAM SOAP DISPENSER	TOUCHLESS SENSOR- OPERATED	7770100.002	-	AMERICAN STANDARD	POLISHED CHROME FINISH	ALL BATHROOMS
B	PAPER TOWEL DISPENSER & WASTE RECEPTACLE	SURFACE MOUNTED CONVERTIBLE	B-3949	SURFACE MOUNTED SEE ELEV.	BOBRICK	SATIN-FINISH STAINLESS STEEL	ALL BATHROOMS
C	MIRROR	STAINLESS STEEL CHANNEL FRAME	B-165	40" MAX. TO REFLECTIVE SURFACE	BOBRICK	STAINLESS STEEL WITH BRIGHT-POLISHED FINISH	ALL BATHROOMS
D	BABY CHANGING STATION	SURFACE MOUNTED STAINLESS STEEL	9013-9	SEE ELEVATION	AMERICAN SPECIALTIES, INC	STAINLESS STEEL	ALL BATHROOMS
E	COAT HOOK	HEAVY-DUTY CLOTHES HOOK	B-2116	48" MAX. A.F.F.	BOBRICK	38" TO 40" MAX A.F.F. TO TOP OF BASE	ALL TOILET COMPARTMENT DOORS
F	42" GRAB BAR	STRAIGHT GRAB BAR	B-5806X42	36" MAX. GRIPPING SURFACE	BOBRICK	33" MIN. - 36" MAX. A.F.F. TO TOP GRIPPING SURFACE	ACCESSIBLE TOILET COMPARTMENT
G	TOILET ROLL HOLDER	SURFACE MOUNTED SINGLE JUMBO-TOILET ROLL HOLDER	B-9890	15" MIN. OPERABLE PART A.F.F.	BOBRICK	STAINLESS STEEL, SATIN FINISH	ALL TOILET COMPARTMENTS
H	36" GRAB BAR	STRAIGHT GRAB BAR	B-5806X36	36" MAX. GRIPPING SURFACE A.F.F.	BOBRICK	33" MIN. - 36" MAX. A.F.F. TO TOP GRIPPING SURFACE	ACCESSIBLE TOILET COMPARTMENT
I	TOILET PARTITION	SOLID PLASTIC HDPE	SERIES 400	MIN. 17" - MAX 19" TO TOP OF THE SEAT	BRADLEY	SUBMIT COLOR PALETTE FOR ARCHITECT APPROVAL	ALL BATHROOMS

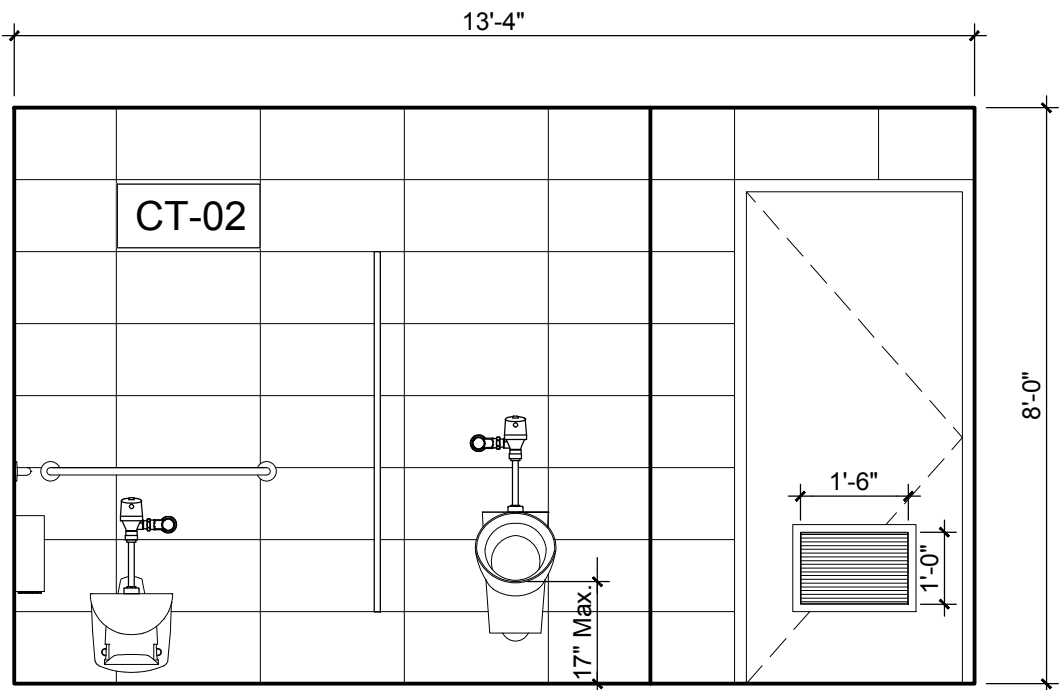


ELEVATION E1

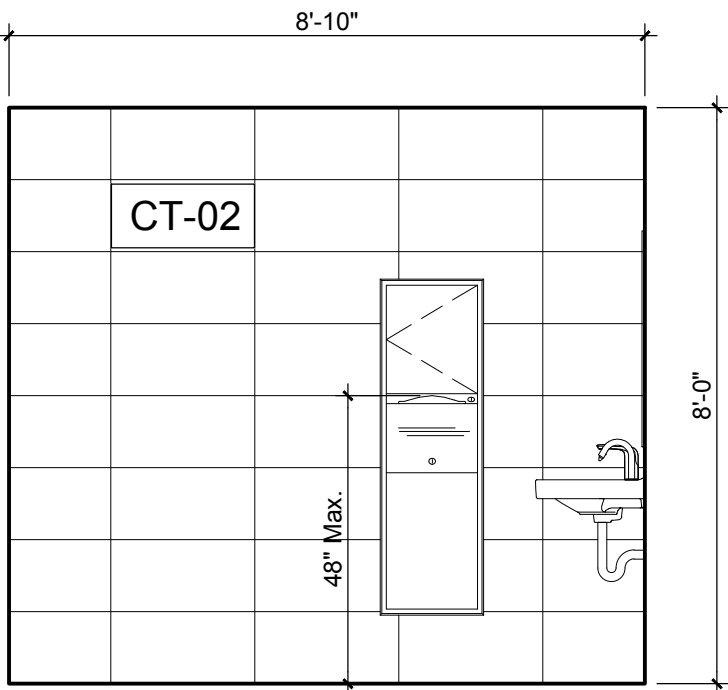


ELEVATION E2

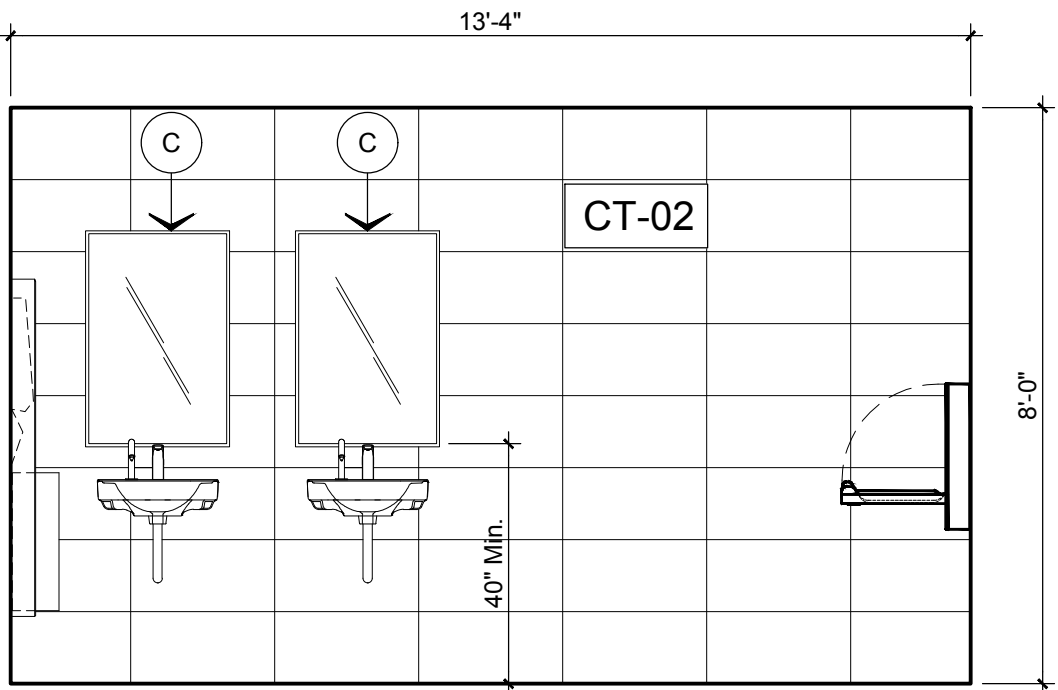


ELEVATION E3

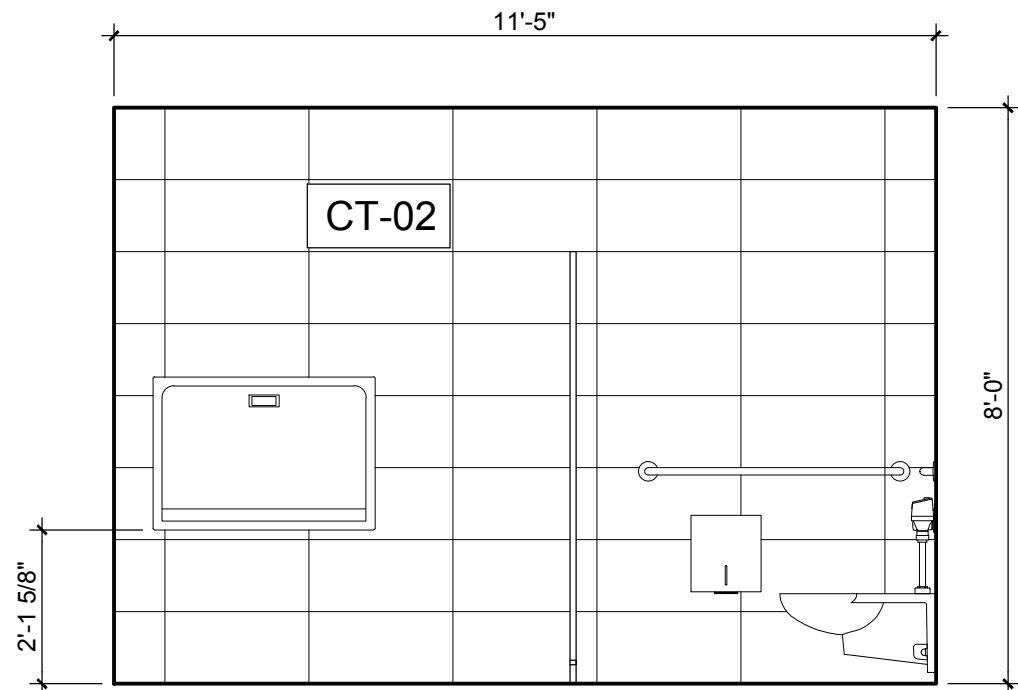


ELEVATION E4

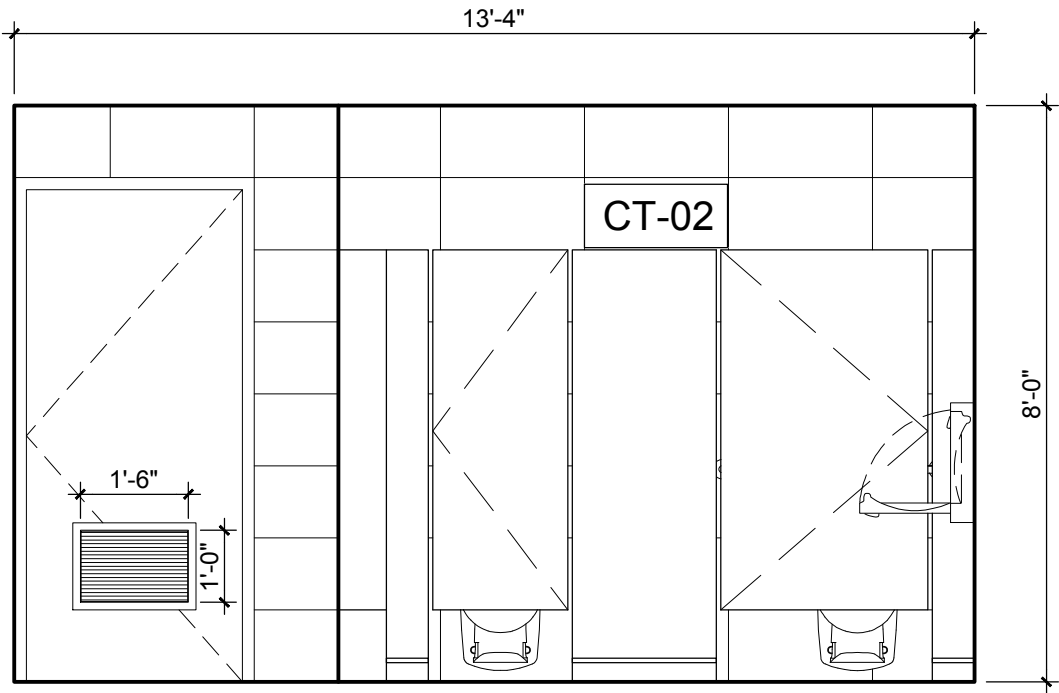


ELEVATION F1

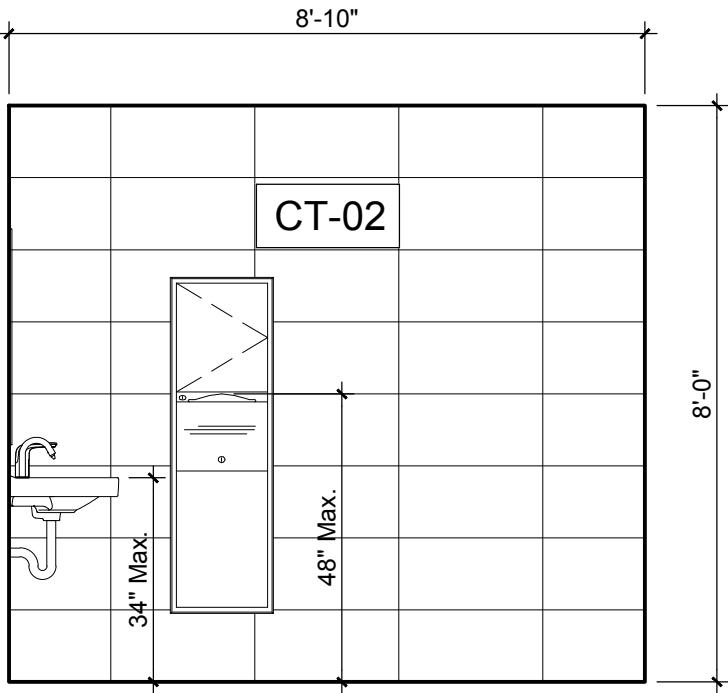


ELEVATION F2

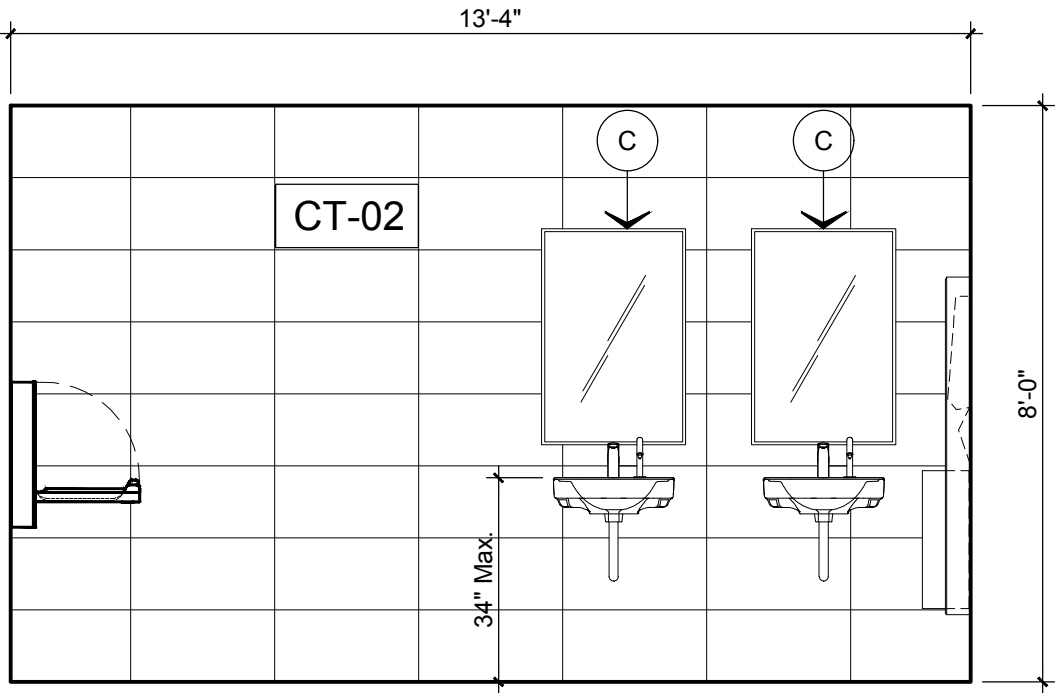

ELEVATION F3

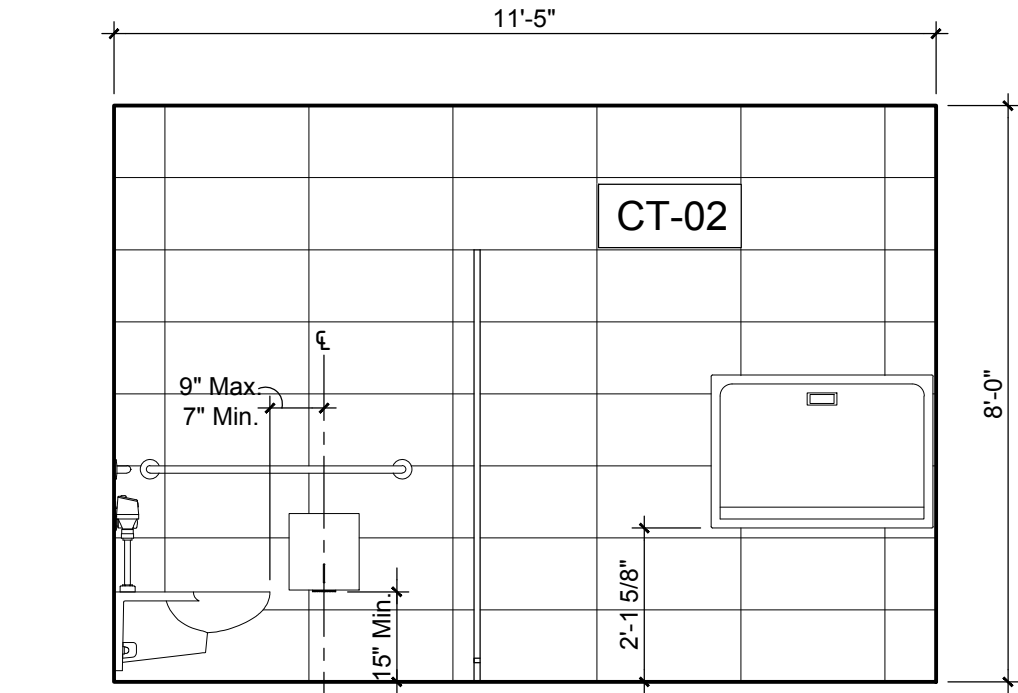

ELEVATION F4

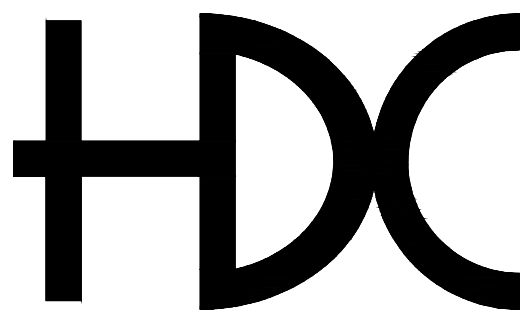

HORACIO DIAZ & ASSOCIATES PSC
CONSULTING ENGINEERS
6 URB. COSTA VERDE
HUMACAO, PUERTO RICO 00791-6036
TEL: (787) 568-1620
E-MAIL: horacio@hdcpr.com



PROPOSED
RESTROOM
ENLARGED FLOOR
PLANS AND
ELEVATIONS

TITLE SHEET | TITULO DE LA HOJA

HDC BID SET
NOT FOR CONSTRUCTION
APR 24, 2023

BO. TRUJILLO
BAJO, CARR.
PR-3 KM. 12.1
CAROLINA, PR

CENTRO
JUDICIAL DE
CAROLINA
PODER
JUDICIAL DE
PUERTO RICO

PROJECT NAME | NOMBRE DEL PROYECTO

THIS DRAWING AND ITS CONTENTS BELONGS TO
HORACIO DIAZ & ASSOCIATES.
THEY SHALL BE USED AS A REFERENCE DOCUMENT AND
WORKING INSTRUMENT ONLY BY AUTHORIZED PERSONNEL.
ANY TOTAL OR PARTIAL REPRODUCTION OR USE OF
THIS DOCUMENT IS STRICTLY PROHIBITED WITHOUT THE
APPROPRIATED WRITTEN CONSENT OF THIS FIRM AND
SHALL BE RETURNED TO THEIR OFFICE IF REQUIRED.


REVISIONS REVISIONES		
NO.	DESCRIPTION	DATE
01	REVISED FLOOR PLAN	APR 24, 2023

DRAWN BY | DIBUJADO POR: H. DIAZ
DESIGN BY | DISEÑADO POR: H. DIAZ
DATE | FECHA: APRIL 24, 2023
CHECK BY | COTEJADO POR: H. DIAZ
APPROVED BY | APROBADO POR: H. DIAZ
SCALE | ESCALA: AS SHOWN



PROJECT NO. | NÚM. PROYECTO: 2022 39
SHEET NO. | NÚM. DE HOJA: 12 OF 15
DRAWING NO. | NÚM. DE DIBUJO: AI-403

AI-403


DOOR TYPES:

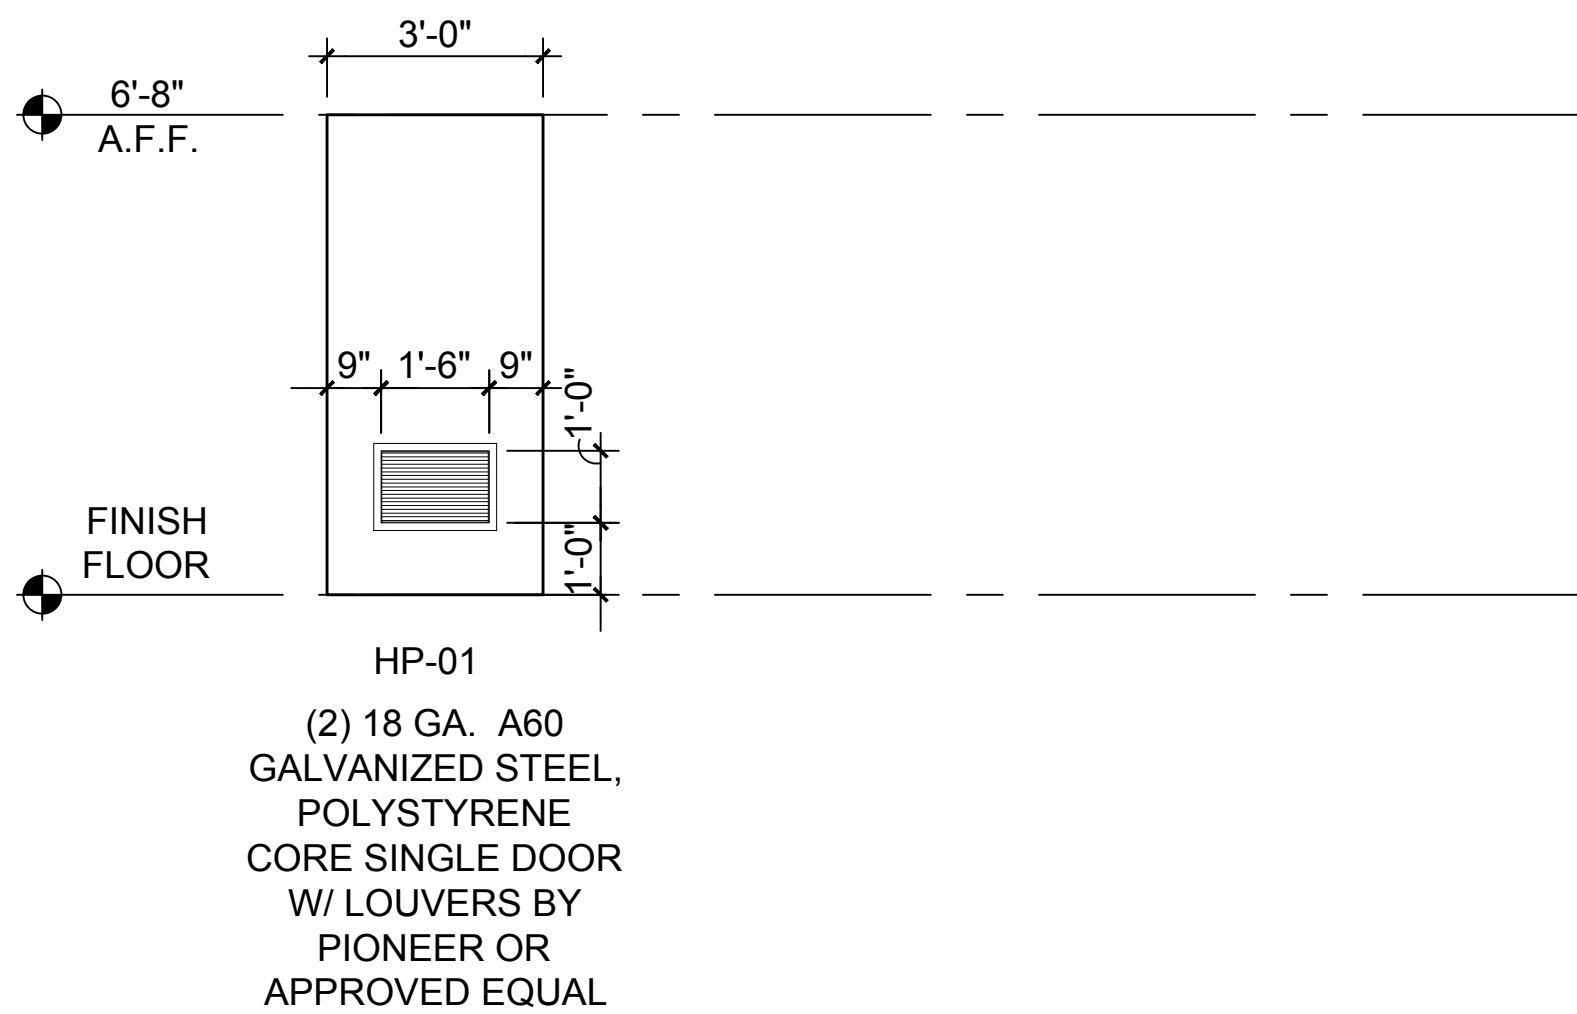


FRAME TYPES:

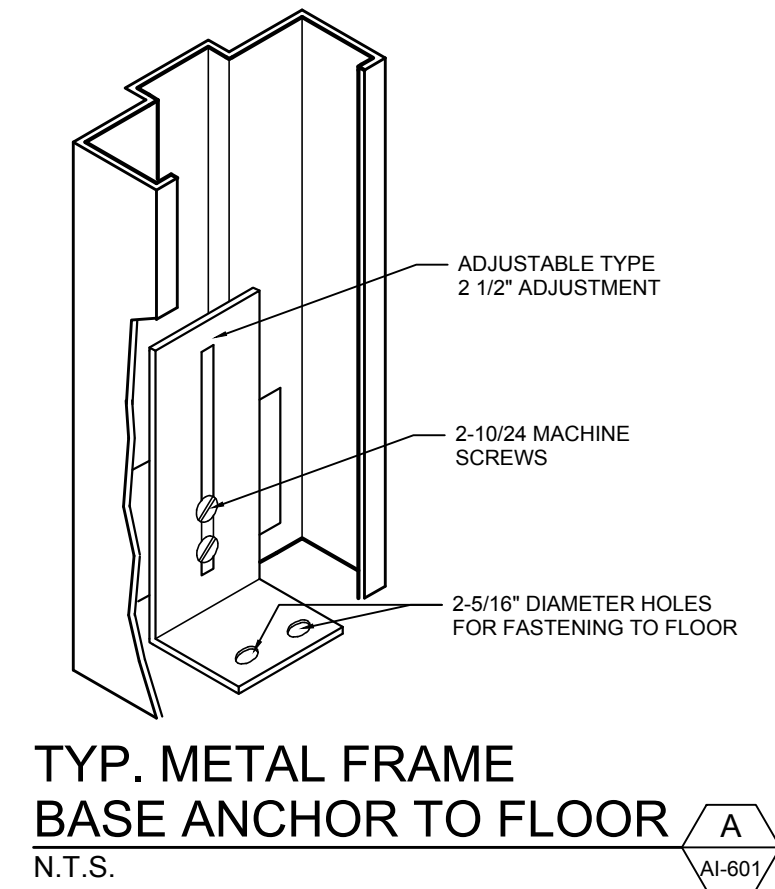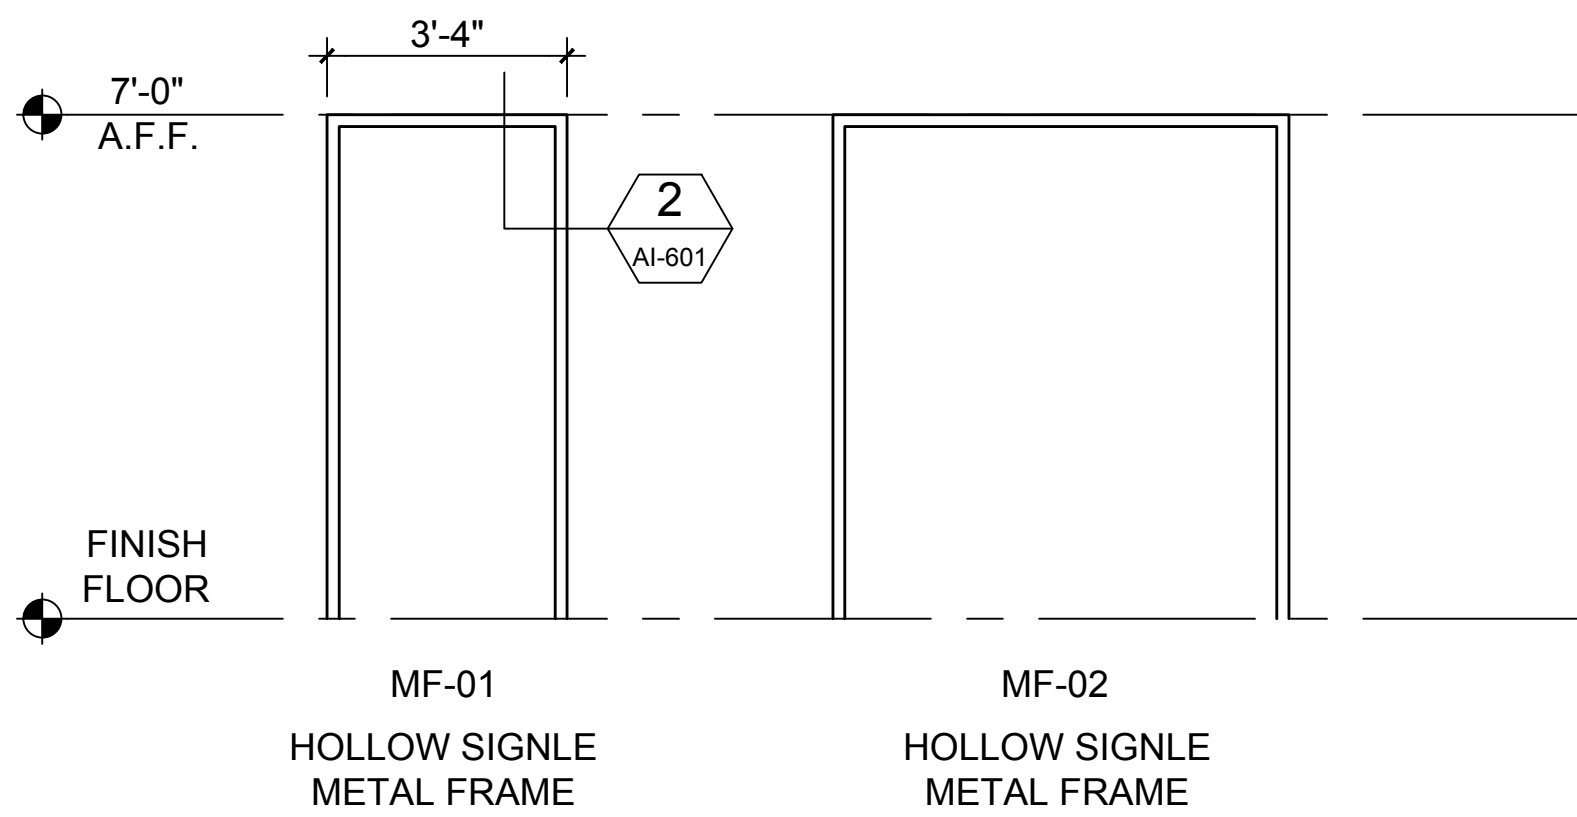

TYP. METAL FRAME
BASE ANCHOR TO FLOOR
N.T.S.

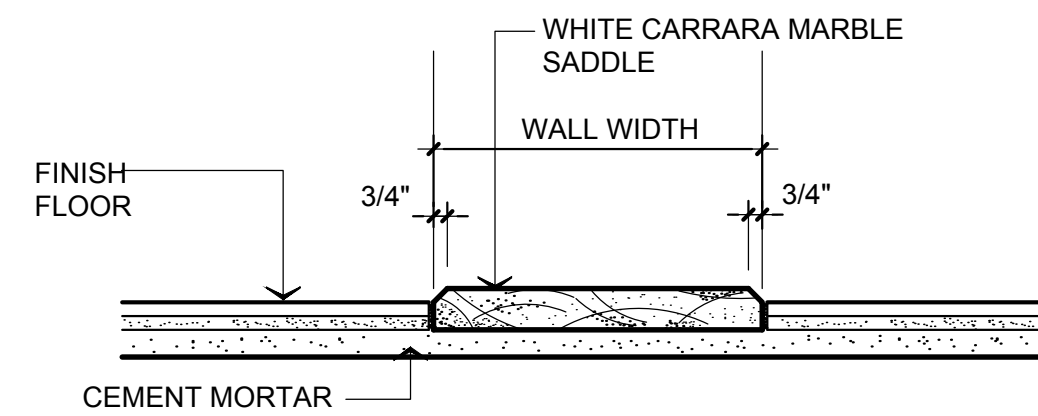


MARBLE SADDLE DET.
N.T.S.

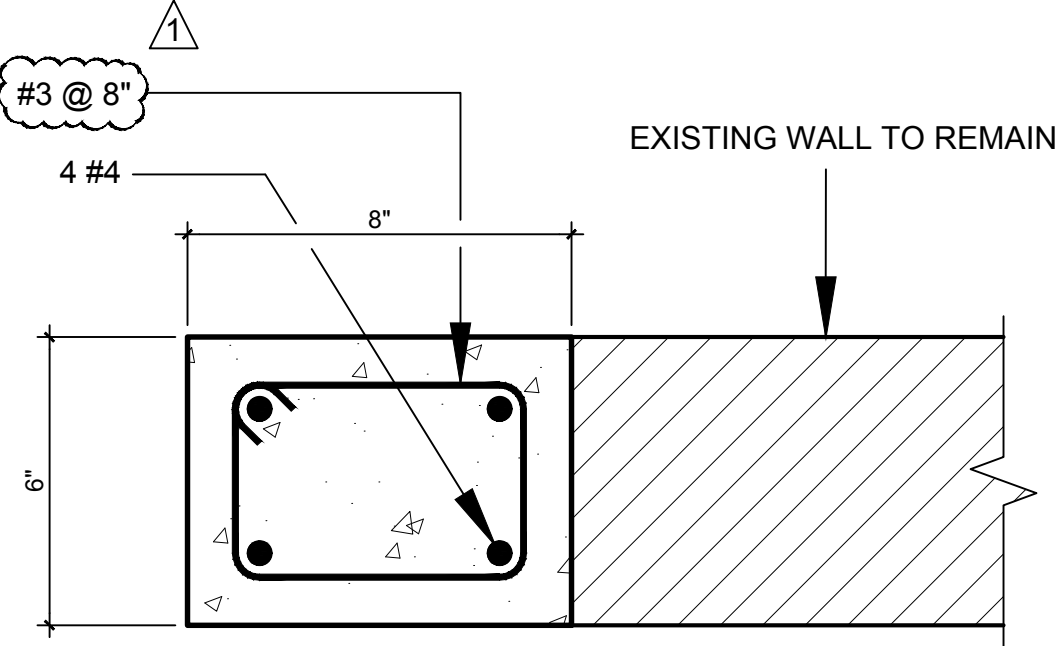


CONCRETE COLUMN C1
SCALE 3"=1'-0"

DOOR FRAME TYPES

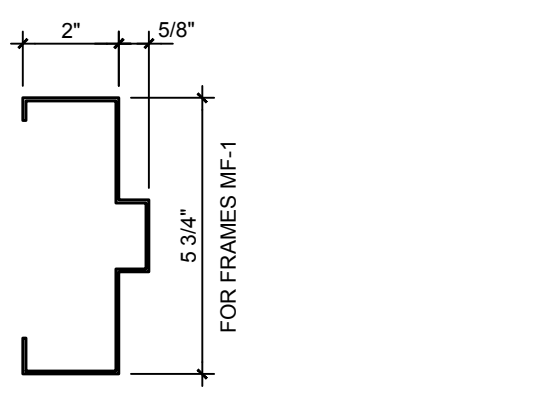

FOR CONCRETE OR
MASONRY WALLS
SCALE: 3"=1'-0"

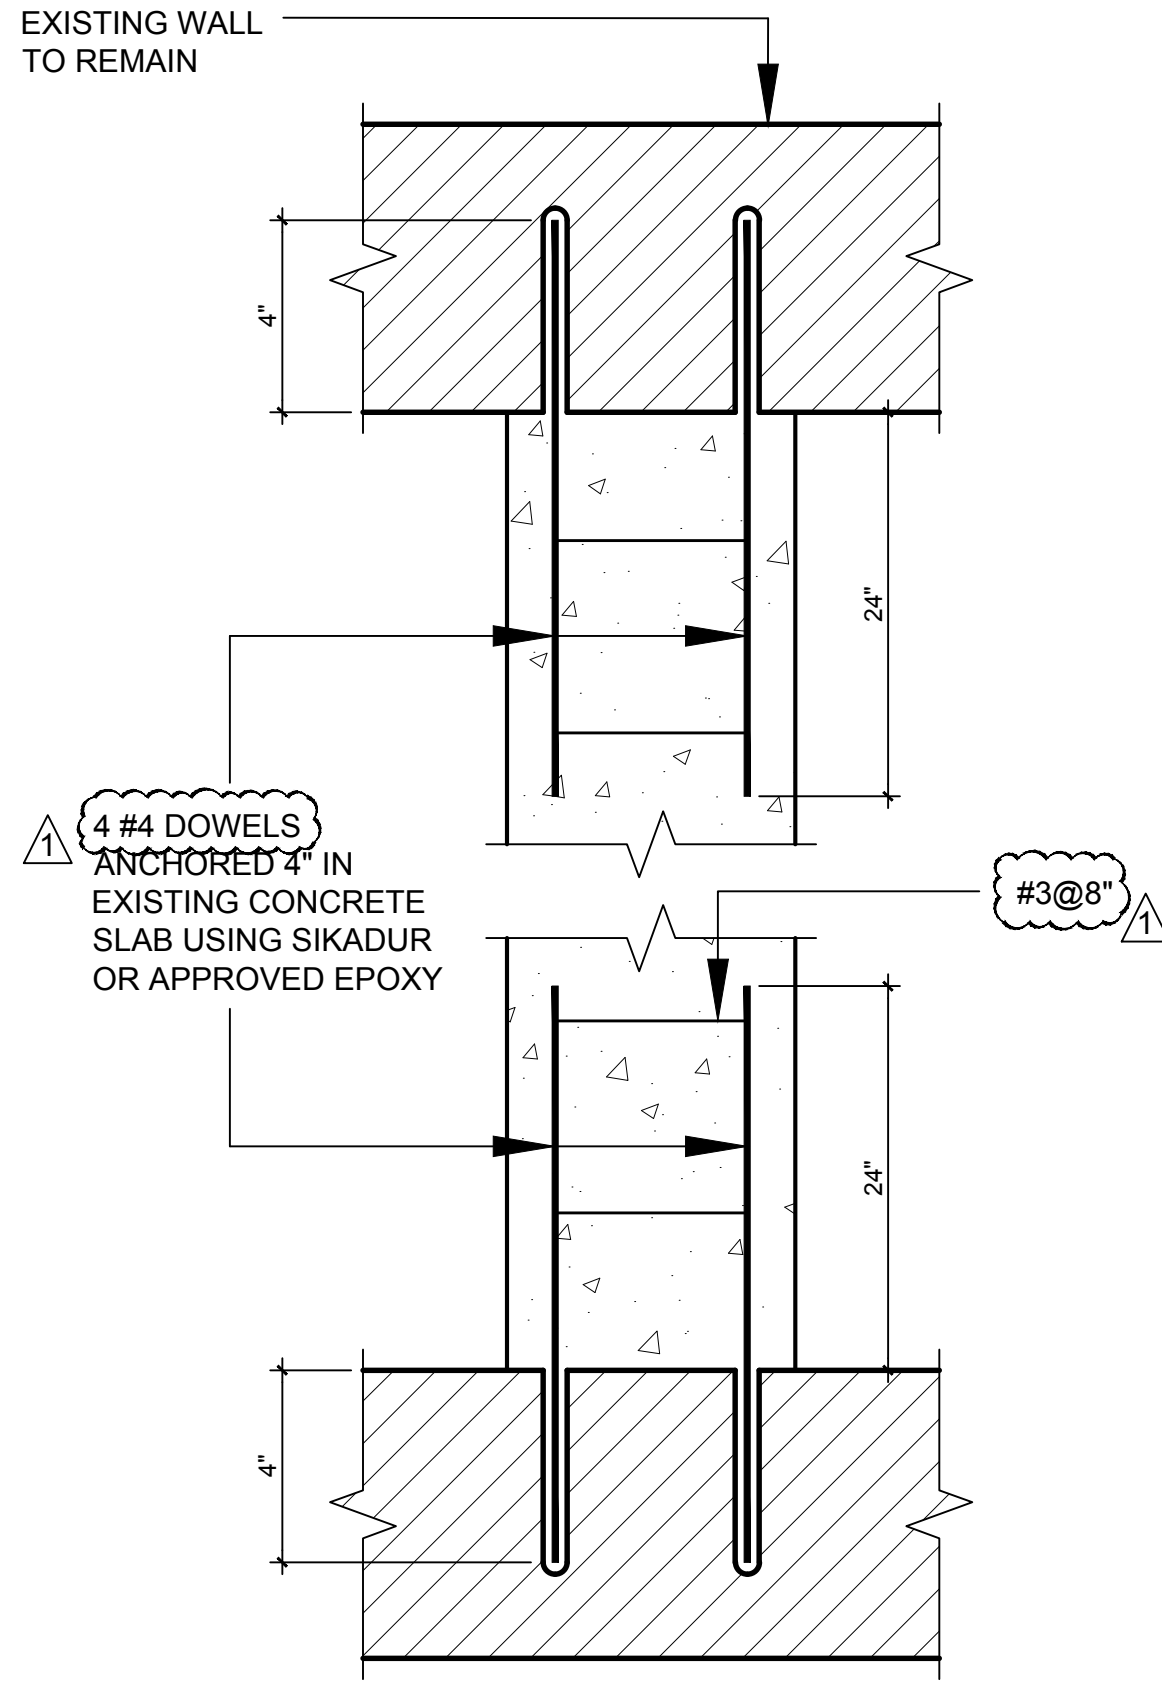


CONCRETE COLUMN C1
SCALE 3"=1'-0"

DOOR SCHEDULE:												
FIRST FLOOR	DOOR MKD. FLOOR LEVEL DOOR NUMBER BUILDING P102 2 HARDWARE GROUP					DOOR				FRAME		REMARKS
						LEAVES		SIZE EACH LEAF			TYPE OF DOOR	
	NO. OF LEAVES	ACTIVE LEAF	WIDTH	HEIGHT	THICKNESS							
	DOOR	ROOM										
101 102	BATHROOM # 1	1	RH, LH	3'-0"	6'-8"	1 3/4"	HP-01	GLOSS ENAMEL	MF-01	GLOSS ENAMEL	U.L. "B" (1-1/2 HOUR) FIRE LABEL	
103 104	BATHROOM # 2	1	LH, RH	3'-0"	6'-8"	1 3/4"	HP-01	GLOSS ENAMEL	MF-01	GLOSS ENAMEL	U.L. "B" (1-1/2 HOUR) FIRE LABEL	
105 106	BATHROOM # 3	1	LH, RH	3'-0"	6'-8"	1 3/4"	HP-01	GLOSS ENAMEL	MF-01	GLOSS ENAMEL	U.L. "B" (1-1/2 HOUR) FIRE LABEL	
SECOND FLOOR												
	201 202	BATHROOM # 1	1	RH, LH	3'-0"	6'-8"	1 3/4"	HP-01	GLOSS ENAMEL	MF-01	GLOSS ENAMEL	U.L. "B" (1-1/2 HOUR) FIRE LABEL
	203 204	BATHROOM # 2	1	LH, RH	3'-0"	6'-8"	1 3/4"	HP-01	GLOSS ENAMEL	MF-01	GLOSS ENAMEL	U.L. "B" (1-1/2 HOUR) FIRE LABEL
	205 206	BATHROOM # 3	1	LH, RH	3'-0"	6'-8"	1 3/4"	HP-01	GLOSS ENAMEL	MF-01	GLOSS ENAMEL	U.L. "B" (1-1/2 HOUR) FIRE LABEL
THIRD FLOOR												
	301 302	BATHROOM # 1	1	RH, LH	3'-0"	6'-8"	1 3/4"	HP-01	GLOSS ENAMEL	MF-01	GLOSS ENAMEL	U.L. "B" (1-1/2 HOUR) FIRE LABEL
	303 304	BATHROOM # 2	1	LH, RH	3'-0"	6'-8"	1 3/4"	HP-01	GLOSS ENAMEL	MF-01	GLOSS ENAMEL	U.L. "B" (1-1/2 HOUR) FIRE LABEL
	305 306	BATHROOM # 3	1	LH, RH	3'-0"	6'-8"	1 3/4"	HP-01	GLOSS ENAMEL	MF-01	GLOSS ENAMEL	U.L. "B" (1-1/2 HOUR) FIRE LABEL
FOURTH FLOOR												
	401 402	BATHROOM # 1	1	RH, LH	3'-0"	6'-8"	1 3/4"	HP-01	GLOSS ENAMEL	MF-01	GLOSS ENAMEL	U.L. "B" (1-1/2 HOUR) FIRE LABEL
	403 404	BATHROOM # 2	1	LH, RH	3'-0"	6'-8"	1 3/4"	HP-01	GLOSS ENAMEL	MF-01	GLOSS ENAMEL	U.L. "B" (1-1/2 HOUR) FIRE LABEL
	405 406	BATHROOM # 3	1	LH, RH	3'-0"	6'-8"	1 3/4"	HP-01	GLOSS ENAMEL	MF-01	GLOSS ENAMEL	U.L. "B" (1-1/2 HOUR) FIRE LABEL

HARDWARE SCHEDULE

H	SET	# 01			
3	EA.	HINGES	ECBB1100 NRP	HAGER	
1	EA.	LOCKSET	2570 CLASSROOM LOCK SERIES LEVER	HAGER	
1	EA.	CLOSER	300 SERIES PBF COV	CAL-ROYAL	
1	EA.	WALL STOP	255W	HAGER	
4	EA.	DOOR SILENCER	307D	HAGER	
1	EA.	LOUVER 18"x12"	800A1 INVERTED Y-BLADE	AIR LOUVERS	
1	EA.	KICK PLATE	190S	HAGER	

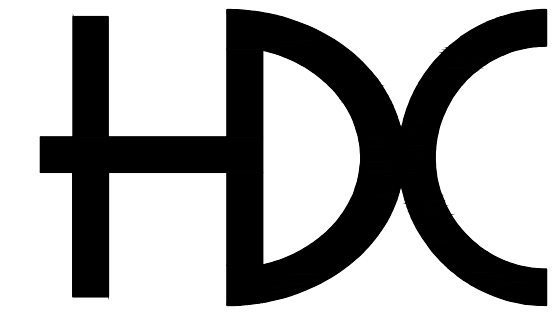

HORACIO DIAZ & ASSOCIATES PSC
CONSULTING ENGINEERS

6 URB. COSTA VERDE
HUMACAO, PUERTO RICO 00791-6036
TEL: (787) 568-1620
E-MAIL: horacio@hdcpr.com



STAMP | SELLO

DOOR SCHEDULE & DETAILS

TITLE SHEET | TITULO DE LA HOJA



BO. TRUJILLO
BAJO, CARR.
PR-3 KM. 12.1
CAROLINA, PR

CENTRO
JUDICIAL DE
CAROLINA
PODER
JUDICIAL DE
PUERTO RICO

PROJECT NAME | NOMBRE DEL PROYECTO

THIS DRAWING AND ITS CONTENTS BELONGS TO
HORACIO DIAZ & ASSOCIATES.
THEY SHALL BE USED AS A REFERENCE DOCUMENT AND
WORKING INSTRUMENT ONLY BY AUTHORIZED PERSONNEL.
ANY TOTAL OR PARTIAL REPRODUCTION OR USE OF
THIS DOCUMENT IS STRICTLY PROHIBITED WITHOUT THE
APPROPRIATED WRITTEN CONSENT OF THIS FIRM AND
SHALL BE RETURNED TO THEIR OFFICE IF REQUIRED.

REVISIONS | REVISIONES


NO.	DESCRIPTION	DATE
01	REVISED REBAR	APR 24, 2023

DRAWN BY | DIBUJADO POR: H. DIAZ
DESIGN BY | DISEÑADO POR: H. DIAZ
DATE | FECHA: APRIL 24, 2023
CHECK BY | COTEJADO POR: H. DIAZ
APPROVED BY | APROBADO POR: H. DIAZ
SCALE | ESCALA: AS SHOWN

PROJECT NO. | NÚM. PROYECTO: 2022 39
SHEET NO. | NÚM. DE HOJA: 13 OF 15
DRAWING NO. | NÚM. DE DIBUJO:

AI-601

PLUMBING EQUIPMENT SCHEDULE						
MKD	DESCRIPTION	STYLE	MODEL NUMBER	MANUFACTURER	MOUNTING HEIGHT ABOVE FINISHED FLOOR	LOCATION
PLUMBING FIXTURES						
1	LAVATORY	DECORUM 20" x 18-1/4" WALL-HUNG LAVATORY WITH EVERCLEAN	9024011EC.020	AMERICAN STANDARD	34" A.F.F. MAX. FOR ADA	MEN'S AND WOMEN'S RESTROOM
	TRUEBRO	WHITE P TRAP AND TWO VALVE COVERS	82193	GRAINGER		
	FAUCET	NEXTGEN SELECTRONIC INTEGRATED TOUCHLESS LAVATORY FAUCET	7.75511e+06	AMERICAN STANDARD		
2	URINAL	DECORUM TOP SPUD URINAL	6042.001EC.020	AMERICAN STANDARD	24" AFF TO TOP OF RIM 17" AFF TO TOP OF RIM FOR ADA	MEN'S RESTROOM
	BATTERY POWERED SENSOR FLUSH VALVE	ULTIMA SELECTRONIC EXPOSED URINAL FLUSH VALVE	6.24501e+06	AMERICAN STANDARD	TOP SPUD	
3	COMMERCIAL WALL HUNG TOILET	AFWALL MILLENNIUM FLOWISE ELONGATED FLUSHOMETER TOILET	3.3511e+06	AMERICAN STANDARD	WALL MOUNTED	MEN'S AND WOMEN'S RESTROOM
	BATTERY POWERED SENSOR FLUSH VALVE	Ultima® Selectronic® Exposed Toilet Flush Valve, Diaphragm Type, Battery, 1.28 gpf/4.8 Lpf	6.24712e+06			
	TOILET SEAT	ELONGATED HEAVY DUTY BOWL OPEN FRONT SEAT LESS COVER	5.9011e+06	AMERICAN STANDARD	17" MIN. - 19" MAX MEASURED TO THE TOP OF THE SEAT	

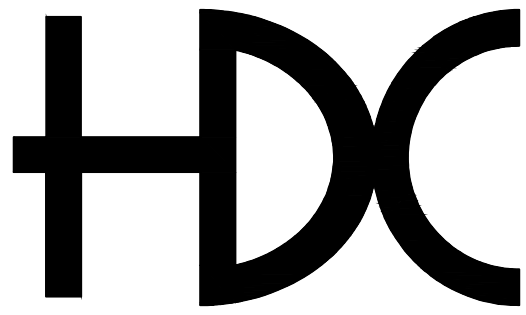

HORACIO DIAZ & ASSOCIATES PSC
CONSULTING ENGINEERS

6 URB. COSTA VERDE
HUMACAO, PUERTO RICO 00791-6036
TEL: (787) 568-1620
E-MAIL: horacio@hdcpr.com



STAMP | SELLO

PLUMBING FIXTURE
SCHEDULE

TITLE SHEET | TITULO DE LA HOJA



BID SET
NOT FOR CONSTRUCTION
APR 24, 2023

BO. TRUJILLO
BAJO, CARR.
PR-3 KM. 12.1
CAROLINA, PR

CENTRO
JUDICIAL DE
CAROLINA
PODER
JUDICIAL DE
PUERTO RICO


PROJECT NAME | NOMBRE DEL PROYECTO

THIS DRAWING AND ITS CONTENTS BELONGS TO
HORACIO DIAZ & ASSOCIATES.
THEY SHALL BE USED AS A REFERENCE DOCUMENT AND
WORKING INSTRUMENT ONLY BY AUTHORIZED PERSONNEL.
ANY TOTAL OR PARTIAL REPRODUCTION OR USE OF
THIS DOCUMENT IS STRICTLY PROHIBITED WITHOUT THE
APPROPRIATED WRITTEN CONSENT OF THIS FIRM AND
SHALL BE RETURNED TO THEIR OFFICE IF REQUIRED.

REVISIONS REVISIONES		
NO.	DESCRIPTION	DATE


DRAWN BY DIBUJADO POR H. DIAZ	CHECK BY COTEJADO POR H. DIAZ
DESIGN BY DISEÑADO POR H. DIAZ	APPROVED BY APROBADO POR H. DIAZ
DATE FECHA APRIL 24, 2023	SCALE ESCALA AS SHOWN

PROJECT NO. NÚM. PROYECTO	
2022 39	
SHEET NO. NÚM. DE HOJA	
14 OF 15	
DRAWING NO. NÚM. DE DIBUJO	

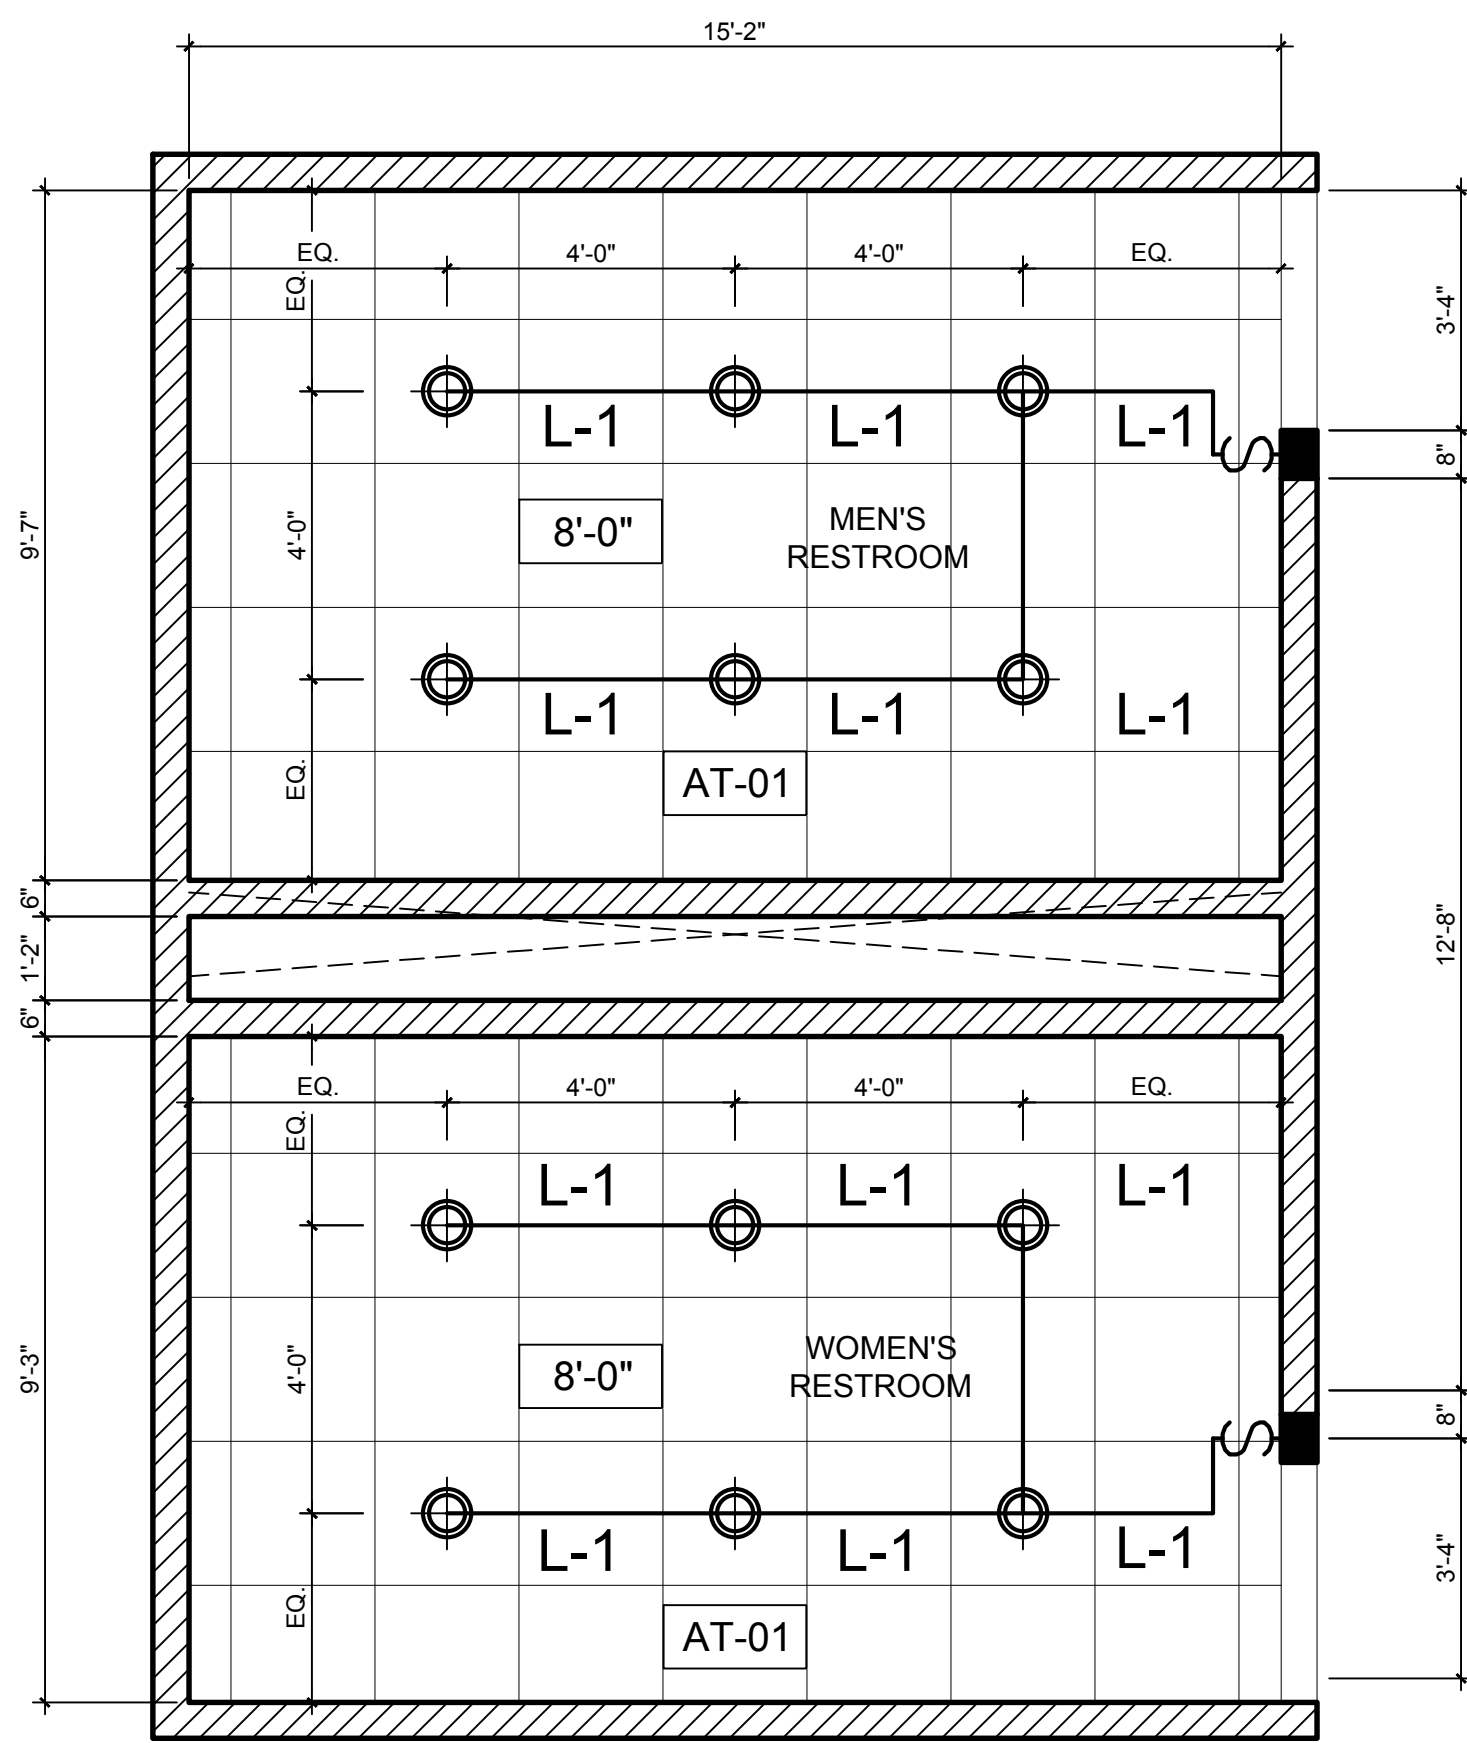


RESTROOM 1 - 1ST, 2ND, 3RD & 4TH
FLOOR REFLECTED CEILING PLAN

SCALE: 3/8"=1'-0"

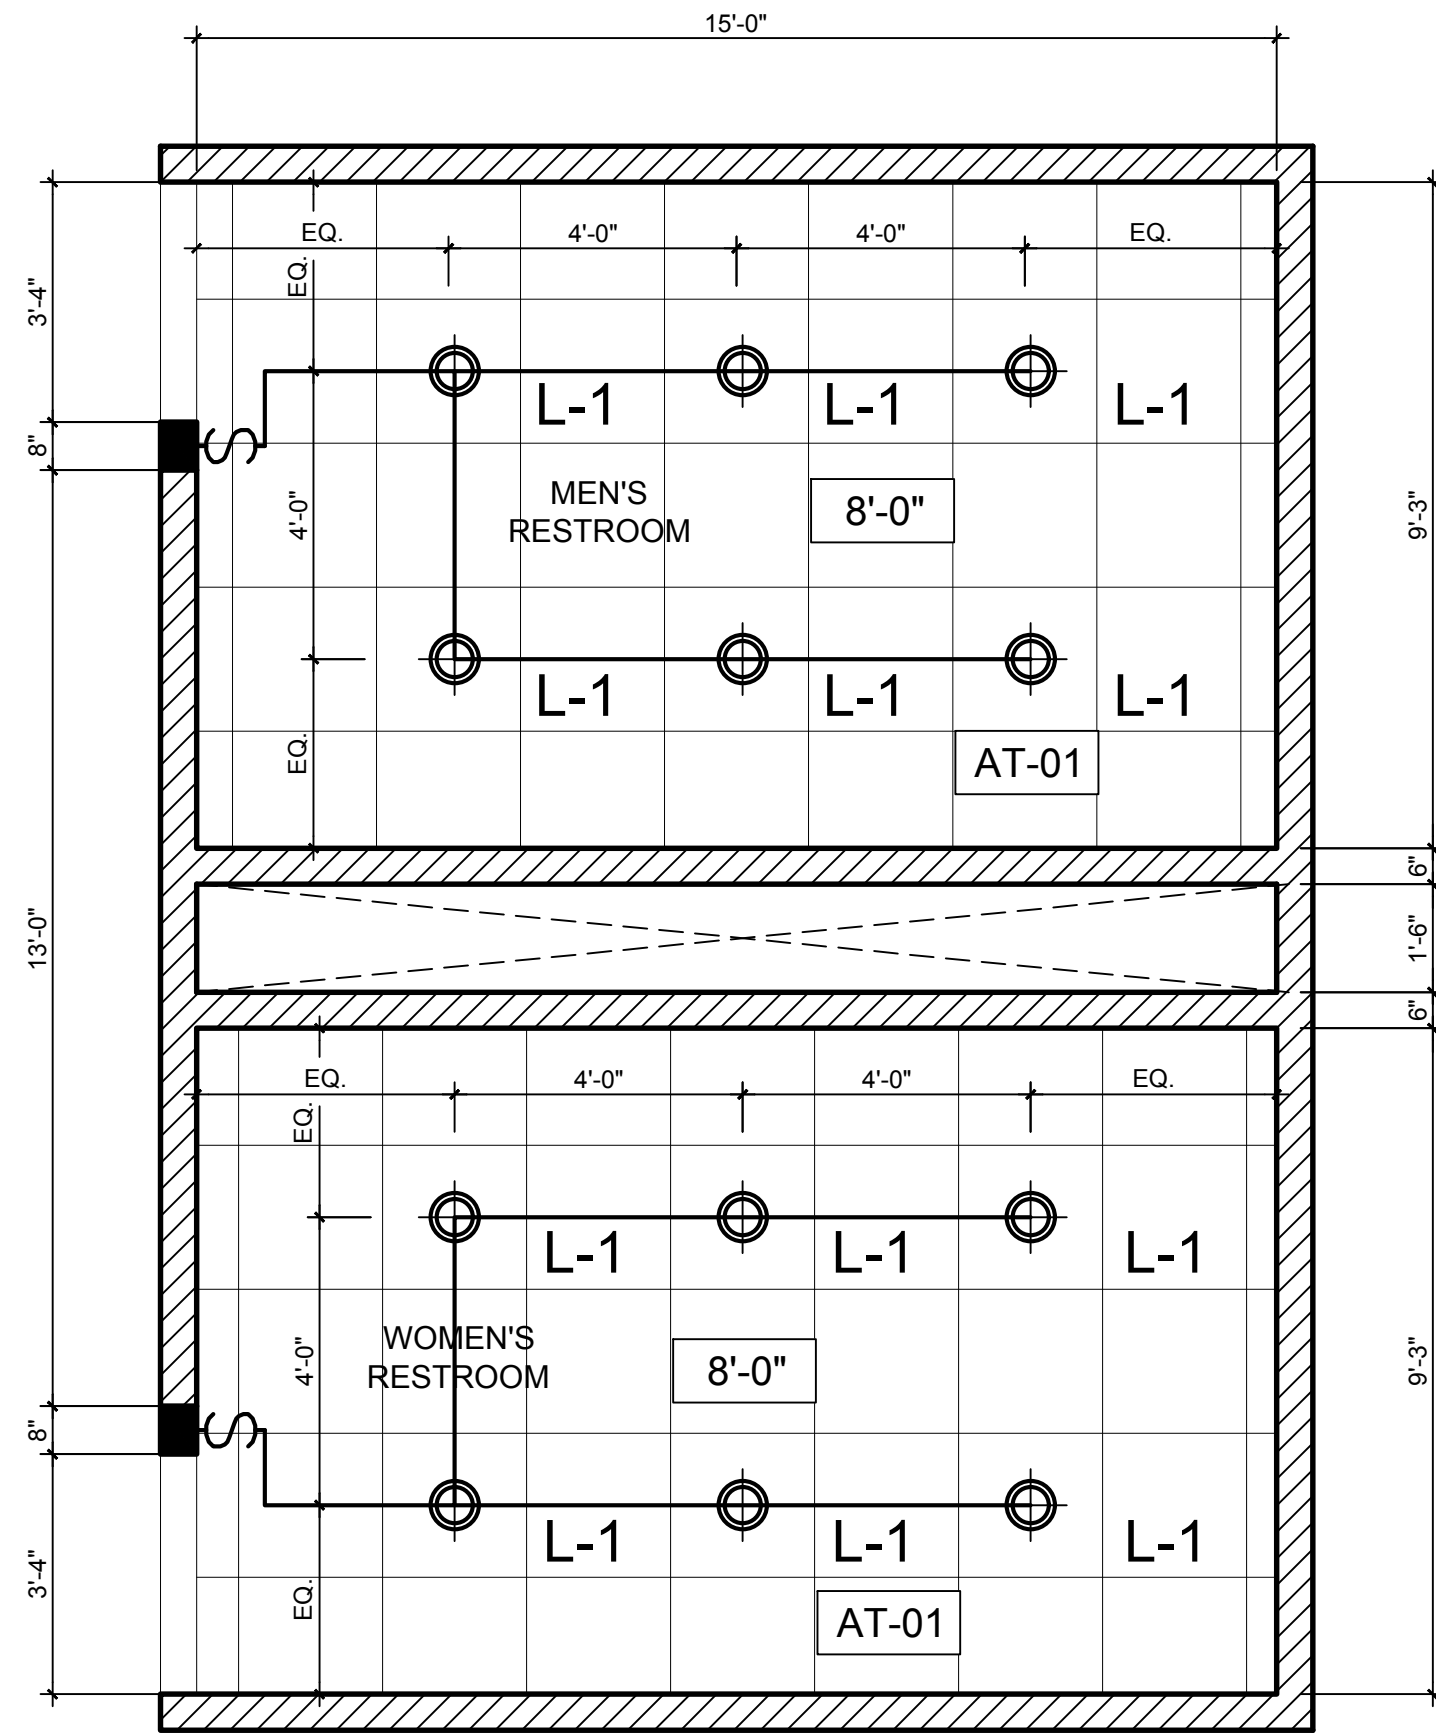

RESTROOM 2 - 1ST, 2ND, 3RD & 4TH
FLOOR REFLECTED CEILING PLAN

SCALE: 3/8"=1'-0"

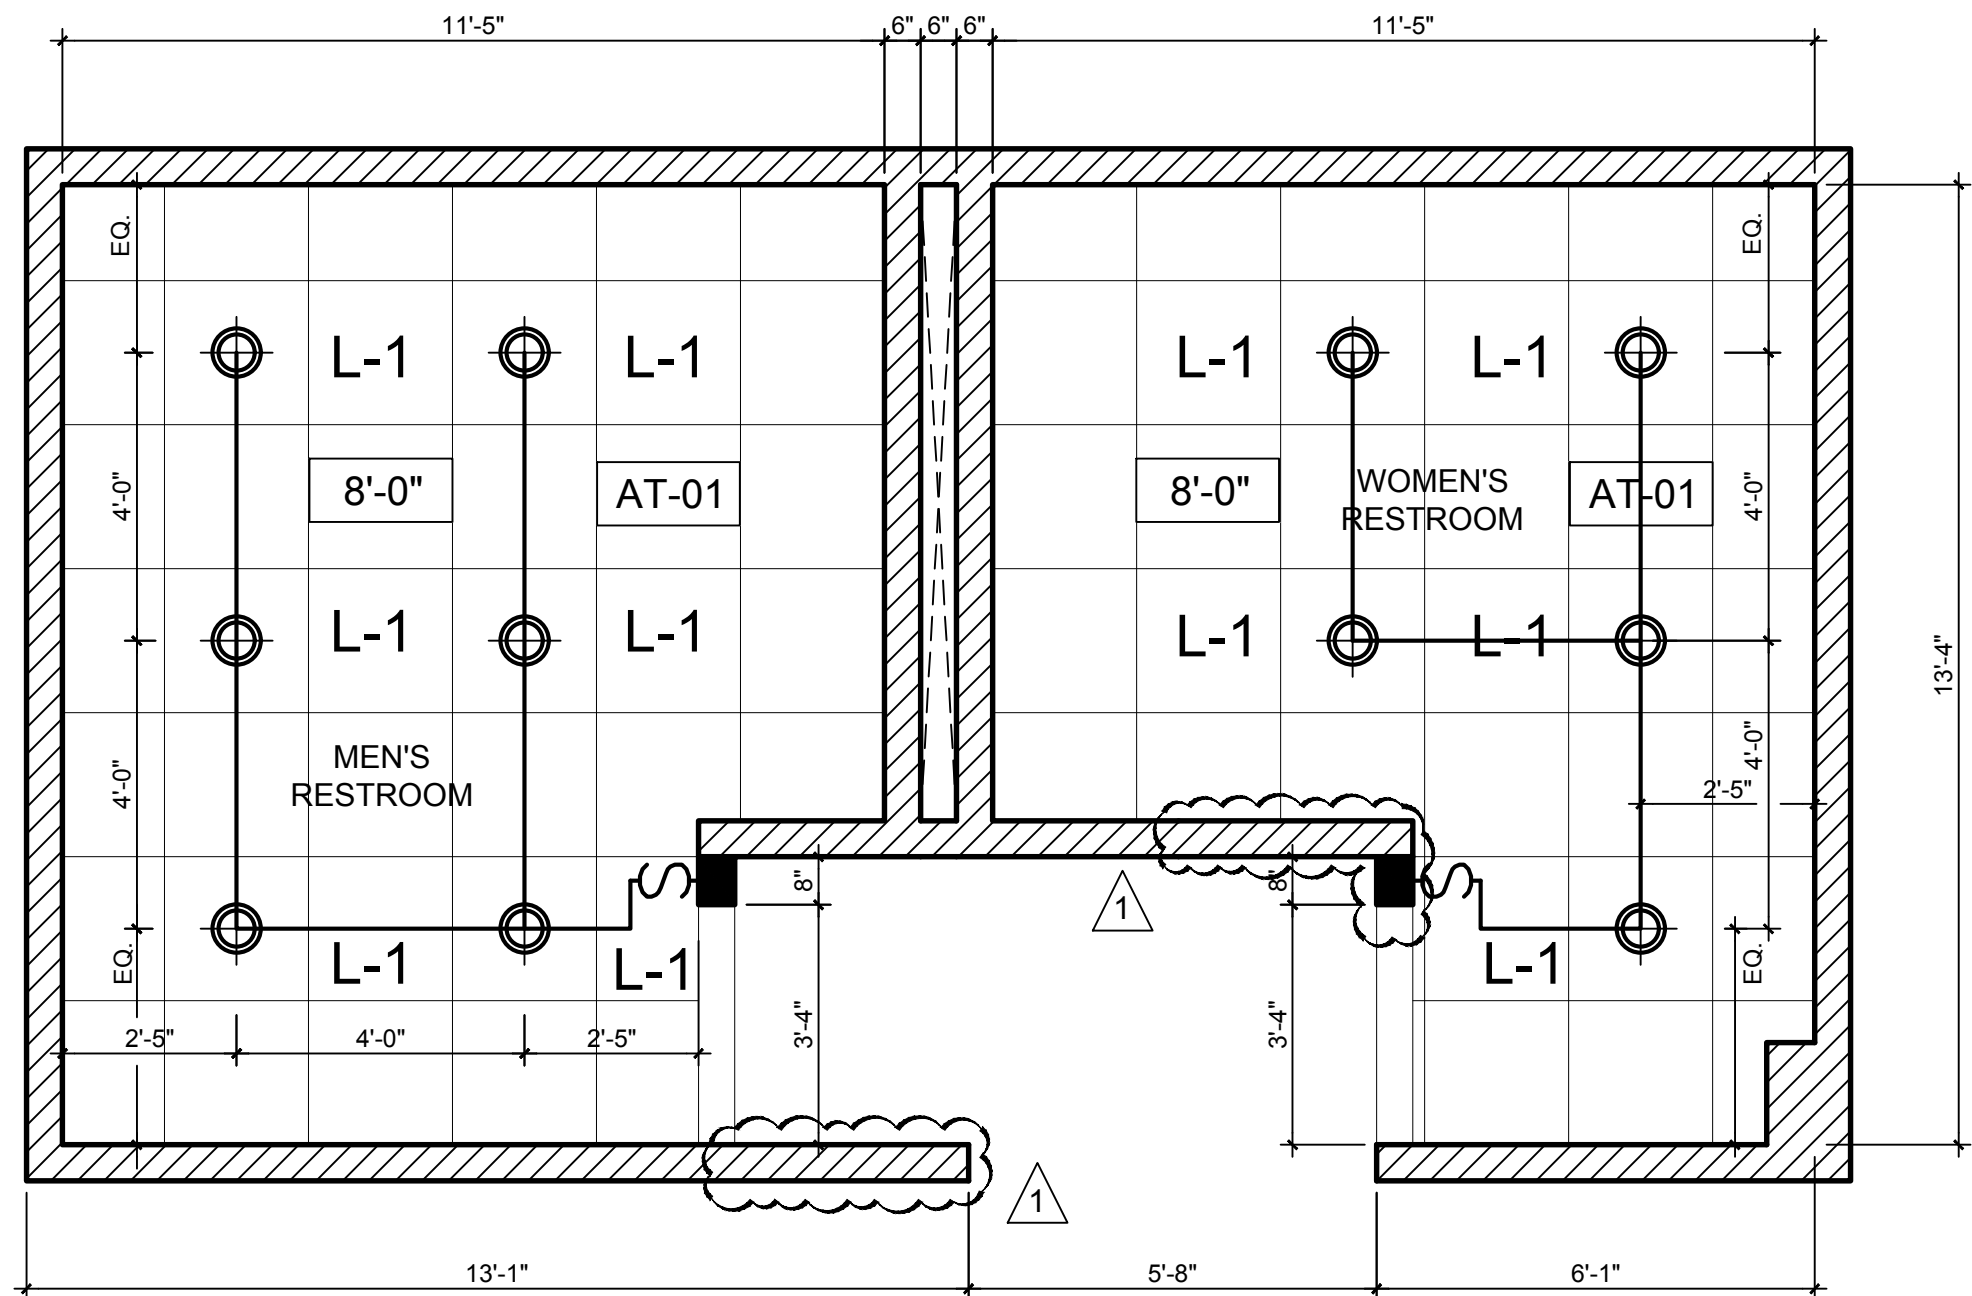


RESTROOM 3 - BASEMENT, 1ST, 2ND, &
3RD FLOOR REFLECTED CEILING PLAN

SCALE: 3/8"=1'-0"

LEGEND

- L-1 NEW LIGHTING FIXTURE LITHONIA LDN4 40 20 L04 AR LSS 120 E21
- NEW 2'X2' ACOUSTICAL CEILING AND SUSPENSION SYSTEM
- 8'-0" INDICATES CEILING HEIGHT ABOVE FINISHED FLOOR A.F.F.
- INDICATES EXISTING WALL TO REMAIN
- AT-01 INDICATES ACOUSTIC TILE TYPE
- NEW SWITCH HEAVY DUTY QUIET SWITCH WALL TYPE 20A, 120V SINGLE POLE INSTALLED WITH STAINLESS STEEL 302 PLATE
- NEW CONDUIT INSTALLED EXPOSED INN HUNG CEILING CONSISTING OF 3C#12 THHN IN 3/4" CONDUIT.

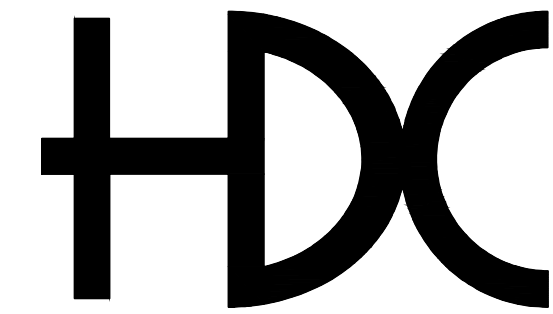

HORACIO DIAZ & ASSOCIATES PSC
CONSULTING ENGINEERS

6 URB. COSTA VERDE
HUMACAO, PUERTO RICO 00791-6036
TEL: (787) 568-1620
E-MAIL: horacio@hdcpr.com



STAMP | SELLO

LIGHTING PLAN

TITLE SHEET | TITULO DE LA HOJA

BID SET
NOT FOR CONSTRUCTION
APR 24, 2023

BO. TRUJILLO
BAJO, CARR.
PR-3 KM. 12.1
CAROLINA, PR

CENTRO
JUDICIAL DE
CAROLINA
PODER
JUDICIAL DE
PUERTO RICO

PROJECT NAME | NOMBRE DEL PROYECTO

THIS DRAWING AND ITS CONTENTS BELONGS TO
HORACIO DIAZ & ASSOCIATES.
THEY SHALL BE USED AS A REFERENCE DOCUMENT AND
WORKING INSTRUMENT ONLY BY AUTHORIZED PERSONNEL.
ANY TOTAL OR PARTIAL REPRODUCTION OR USE OF
THIS DOCUMENT IS STRICTLY PROHIBITED WITHOUT THE
APPROPRIATED WRITTEN CONSENT OF THIS FIRM AND
SHALL BE RETURNED TO THEIR OFFICE IF REQUIRED.

REVISIONS REVISIONES		
NO.	DESCRIPTION	DATE
01	REVISED FIXTURE TYPE & FLOOR PLAN	APR 24, 2023

DRAWN BY | DIBUJADO POR H. DIAZ
DESIGN BY | DISEÑADO POR H. DIAZ
DATE | FECHA APRIL 24, 2023
CHECK BY | COTEJADO POR H. DIAZ
APPROVED BY | APROBADO POR H. DIAZ
SCALE | ESCALA AS SHOWN

PROJECT NO. | NÚM. PROYECTO
2022 39
SHEET NO. | NÚM. DE HOJA
15 OF 15
DRAWING NO. | NÚM. DE DIBUJO