



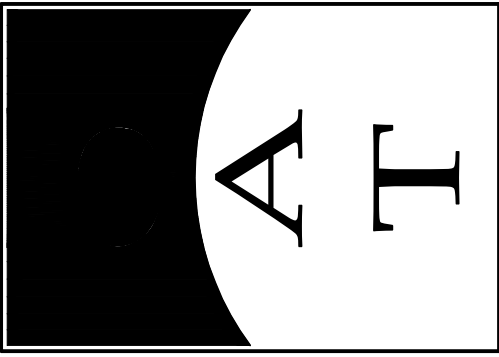

R E V I S I O N S			
NO.	DESCRIPTION	DATE	BY

TRIBUNAL GENERAL DE JUSTICIA			
OFICINA DE ADMINISTRACION DE LOS TRIBUNALES			
DIRECTORIA DE ADMINISTRACION			
OFICINA DE ADMINISTRACION Y CONSERVACION DE LOCALES			
APPROVED BY:	ENCARGADO DEL AREA	APPROVED DATE:	PROJECT APPROVED DATE:

PROJECT NAME:			
NUEVA AREA ALGUACIL			
PROJECT LOCATION:			
TRIBUNAL SUPREMO			
DRAWING DESCRIPTIONS:			
ELECTRICAL FLOOR PLAN			
SHEET NO.		PROJECT NO.	
F-01		PROJECT DATE:	
OF:		PRINTING DATE:	
NO.		PLOT DATE:	
		DRAWING BY:	
		MR. OR MSR.	
		FILE NAME:	
		DRAWING SCALE:	
		DWG. SCALE:	

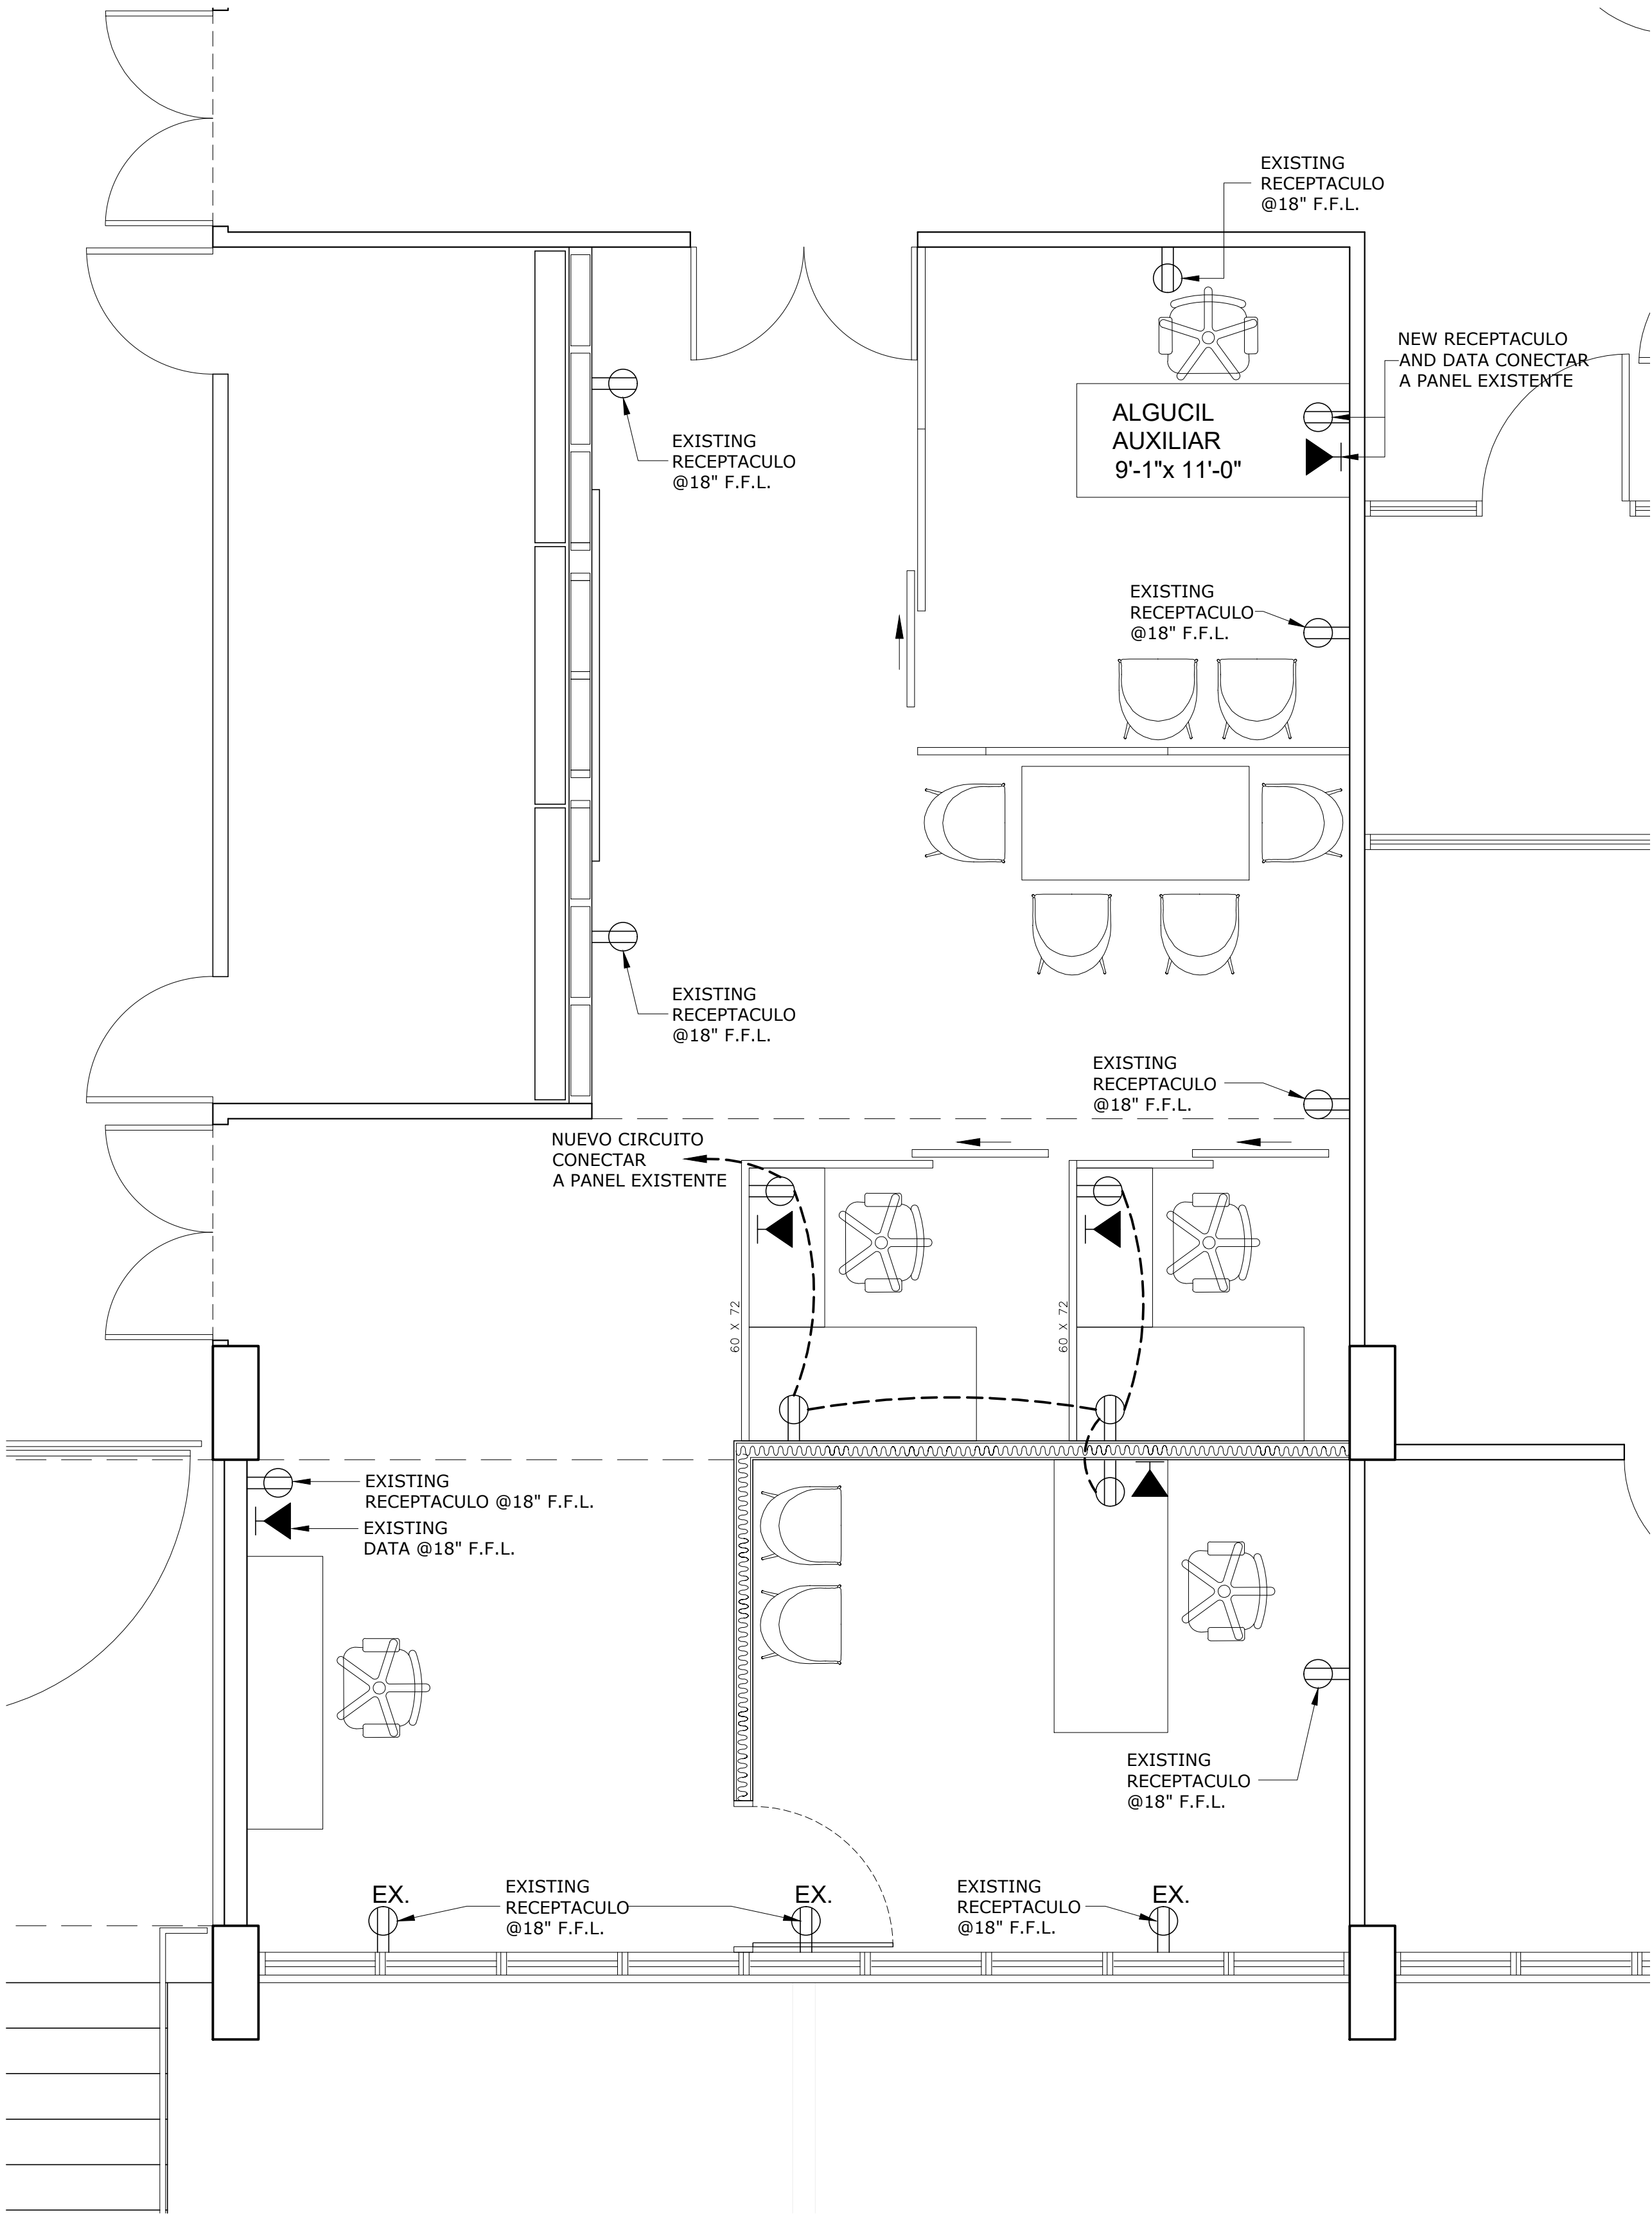

ELECTRICAL
SECOND FLOOR PLAN (edificio principal)

SCALE: 3/8"=1'-0"

NOTES:

1. SHALL BE INSTALL NEW 120V CIRCUITS FROM EXISTING DISTRIBUTION PANEL , WITH 20AMP BREAKER PER CIRCUIT.
2. ALL RECEPTACLE AND COVER SHALL BE WHITE COLOR, 20AMP GFCI.
3. ALL NEW CIRCUITS SHALL BE IDENTIFIED IN THE ELECTRICAL PANEL LEGEND.
4. UNDER ANY CIRCUMSTANCE SHOULD BE REMOVED OR CONNECT AN ENERGIZED ELECTRICAL SYSTEM. ALL SOURCE OF POWER SHALL BE TURNED OFF AND LOCK OUT DURING WORKING TIME FRAME.
5. SHALL BE USE EMT TUBING, MINIMUM SIZE 3/4"Ø.
6. SHALL BE INSTALL AN 80KA, 120 /240V VOLT SURGE PROTECTION DEVICE TO THE EXISTING ELECTRIC PANEL, USING A 30AMP, 120 /240V TWO-POLE CIRCUIT BREAKER. SIMILAR OR EQUAL TO SQUARE D MODEL: HEPD80. ALL RELATED PARTS SHALL BE PROVIDED AND INSTALLED BY CONTRACTOR, AS MANUFACTURE INSTALLATION GUIDE.
7. CONTRACTOR SHALL BE USE CABLE THHN, STRANDED, #12 AWG FOR 20AMP CIRCUITS. AND SHALL BE USE CABLE THHN, STRANDED, #10 AWG FOR 30AMP CIRCUITS.