



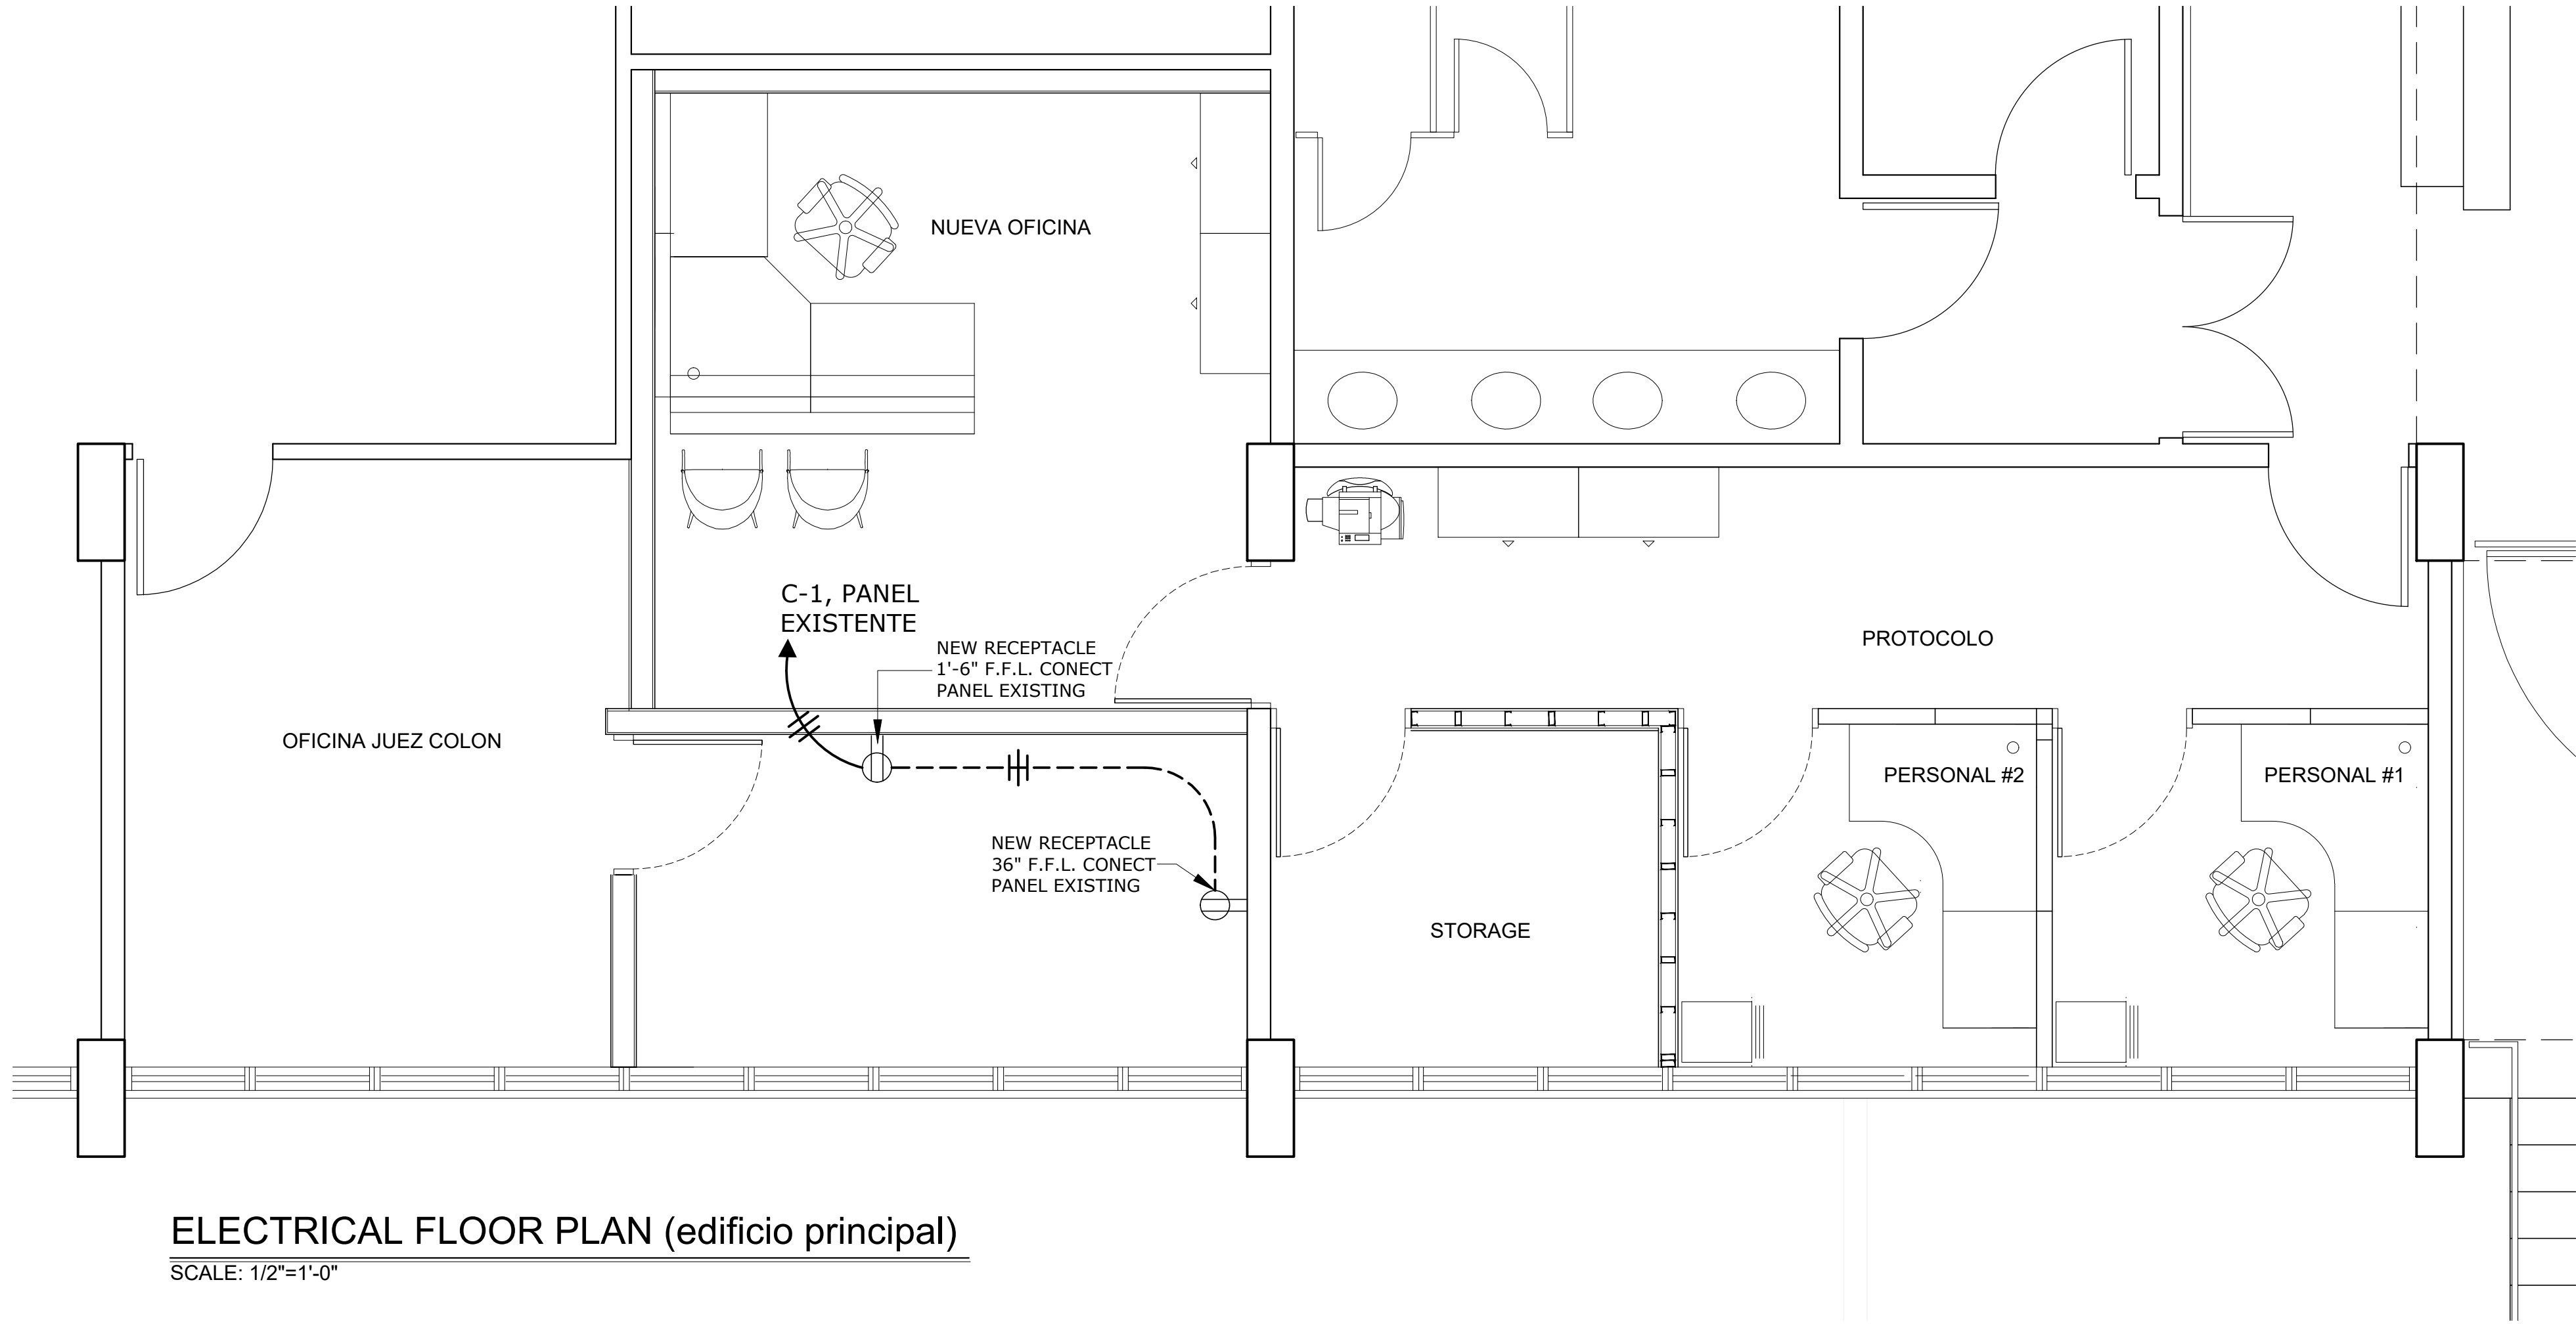

ELECTRICAL FLOOR PLAN (edificio principal)
SCALE: 1/2"=1'-0"

NOTES:

1. SHALL BE INSTALL NEW 120V CIRCUITS FROM EXISTING DISTRIBUTION PANEL , WITH 20AMP BREAKER PER CIRCUIT.
2. ALL RECEPTACLE AND COVER SHALL BE WHITE COLOR, 20AMP GFCI.
3. ALL NEW CIRCUITS SHALL BE IDENTIFIED IN THE ELECTRICAL PANEL LEGEND.
4. UNDER ANY CIRCUMSTANCE SHOULD BE REMOVED OR CONNECT AN ENERGIZED ELECTRICAL SYSTEM. ALL SOURCE OF POWER SHALL BE TURNED OFF AND LOCK OUT DURING WORKING TIME FRAME.
5. SHALL BE USE EMT TUBING, MINIMUM SIZE 3/4"Ø.
6. SHALL BE INSTALL AN 80KA, 120 /240V VOLT SURGE PROTECTION DEVICE TO THE EXISTING ELECTRIC PANEL, USING A 30AMP, 120 /240V TWO-POLE CIRCUIT BREAKER. SIMILAR OR EQUAL TO SQUARE D MODEL: HEPD80. ALL RELATED PARTS SHALL BE PROVIDED AND INSTALLED BY CONTRACTOR, AS MANUFACTURE INSTALLATION GUIDE.
7. CONTRACTOR SHALL BE USE CABLE THHN, STRANDED, #12 AWG FOR 20AMP CIRCUITS. AND SHALL BE USE CABLE THHN, STRANDED, #10 AWG FOR 30AMP CIRCUITS.

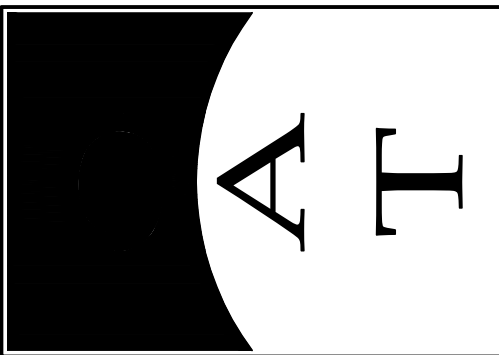

R E V I S I O N S			
NO.	DESCRIPTION	DATE	BY

TRIBUNAL GENERAL DE JUSTICIA
OFICINA DE ADMINISTRACION DE LOS TRIBUNALES
DIRECTORIA DE ADMINISTRACION
OFICINA DE ADMINISTRACION Y CONSERVACION DE LOCALES

APPROVED BY: _____

APPROVED SIGN: _____ APPROVED DATE: _____

PROJECT NAME: DIGITALIZACION PLANOS RAMA JUDICIAL(Actualizacion 5-10-10)

PROJECT LOCATION: TRIBUNAL SUPREMO

DRAWING DESCRIPTIONS: PLANTA ELECTRICA

SHEET NO. OF	GERENTE DE PROYECTO:	PROJECT DATE: 21-ENERO-2025
	CHECKED BY:	PRINTING DATE: 21-ENERO-2025
	DRAWING BY: P.MORALES	DRAWING SCALE: 1/8"=1'-0"
	FILE NAME: 1601-A-SECOND.dwg	

1-01