




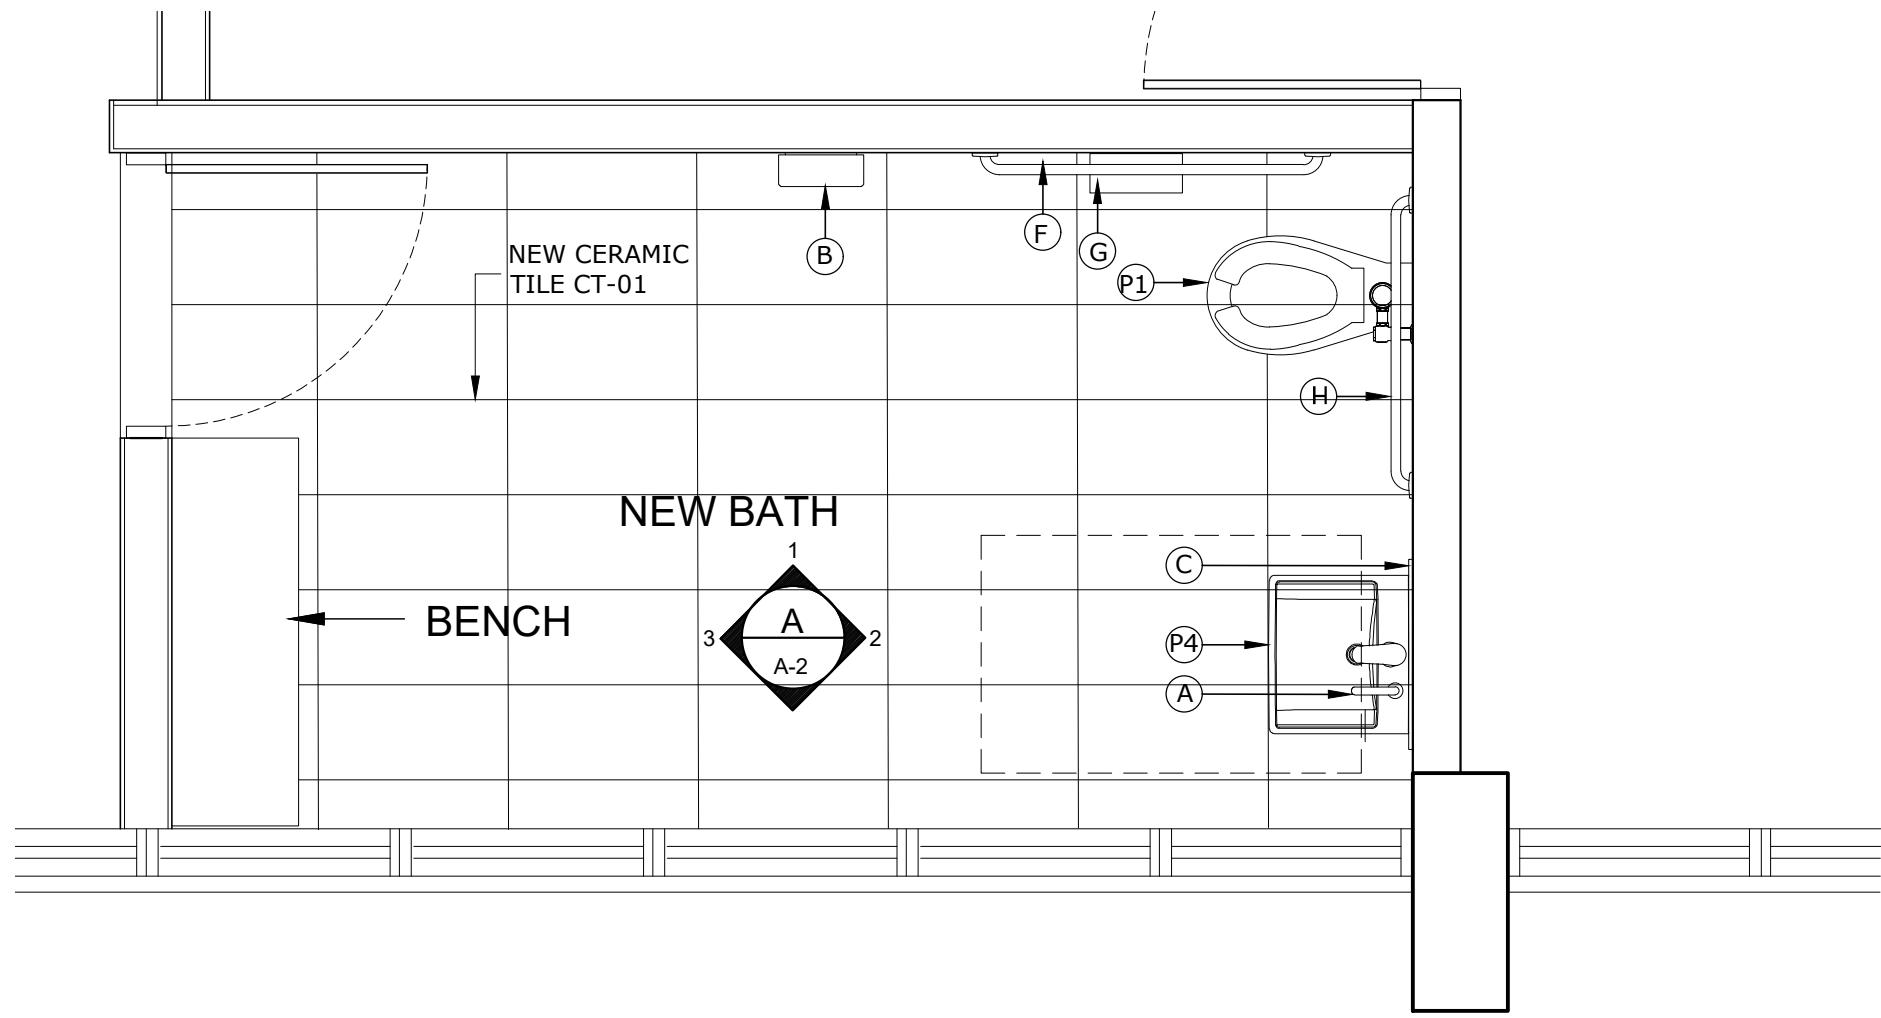


NEW BATH OFFICE SR. JUEZ COLON
SECOND FLOOR PLAN (edificio principal)
SCALE: 1/2"=1'-0"

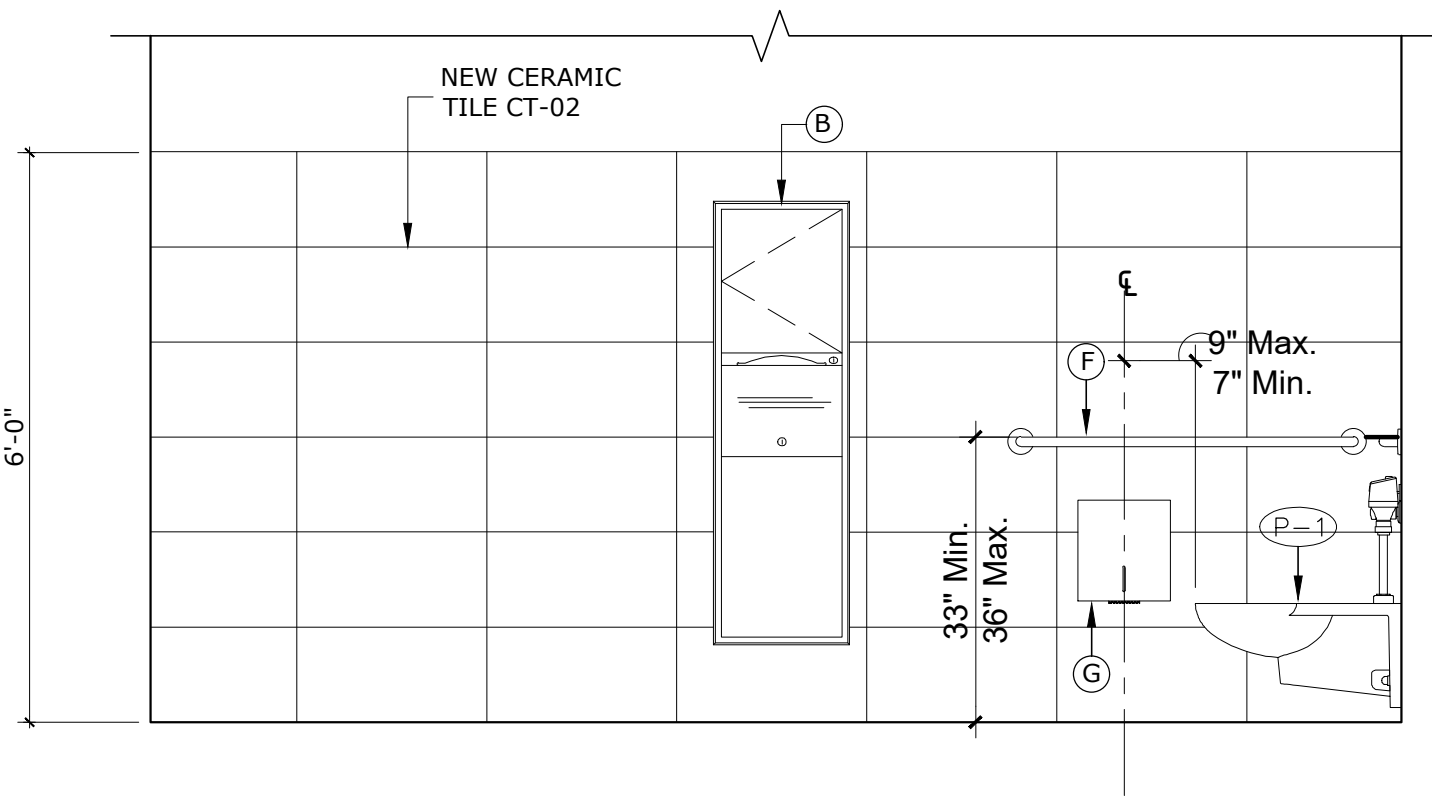


ELEVATION 1
SCALE: 3/8"=1'-0"

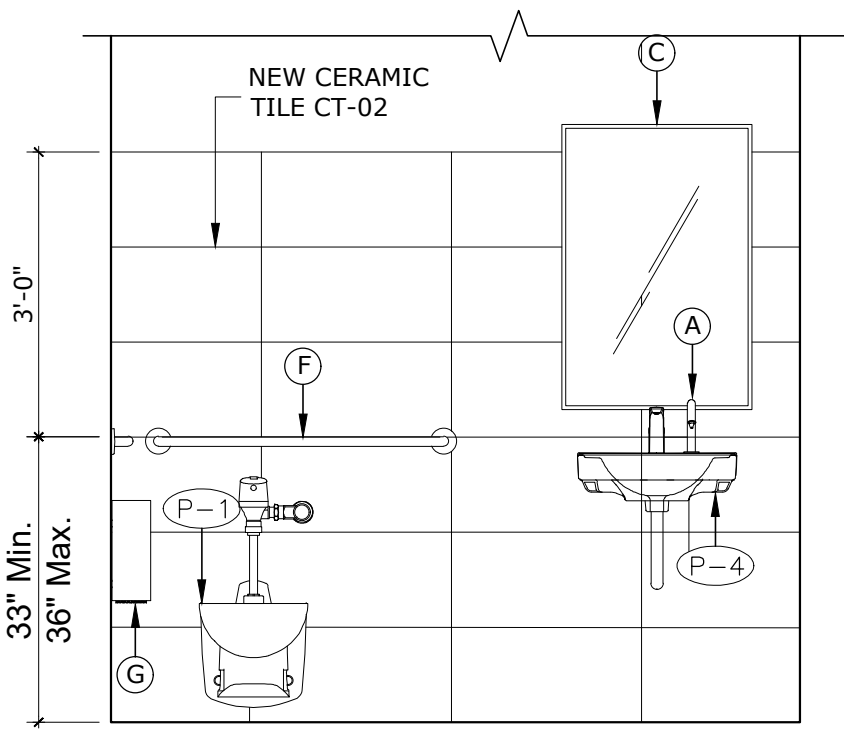

ELEVATION 2
SCALE: 3/8"=1'-0"

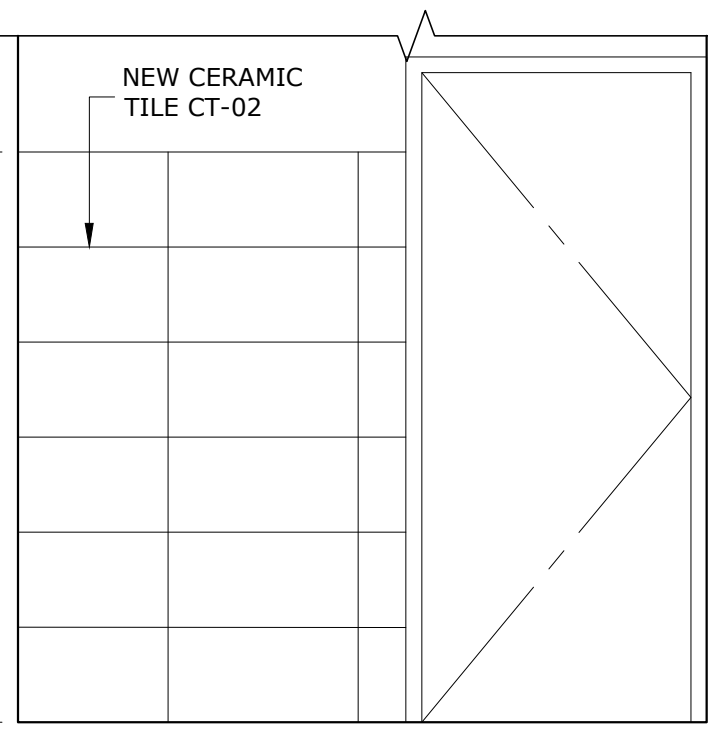



ELEVATION 3
SCALE: 3/8"=1'-0"

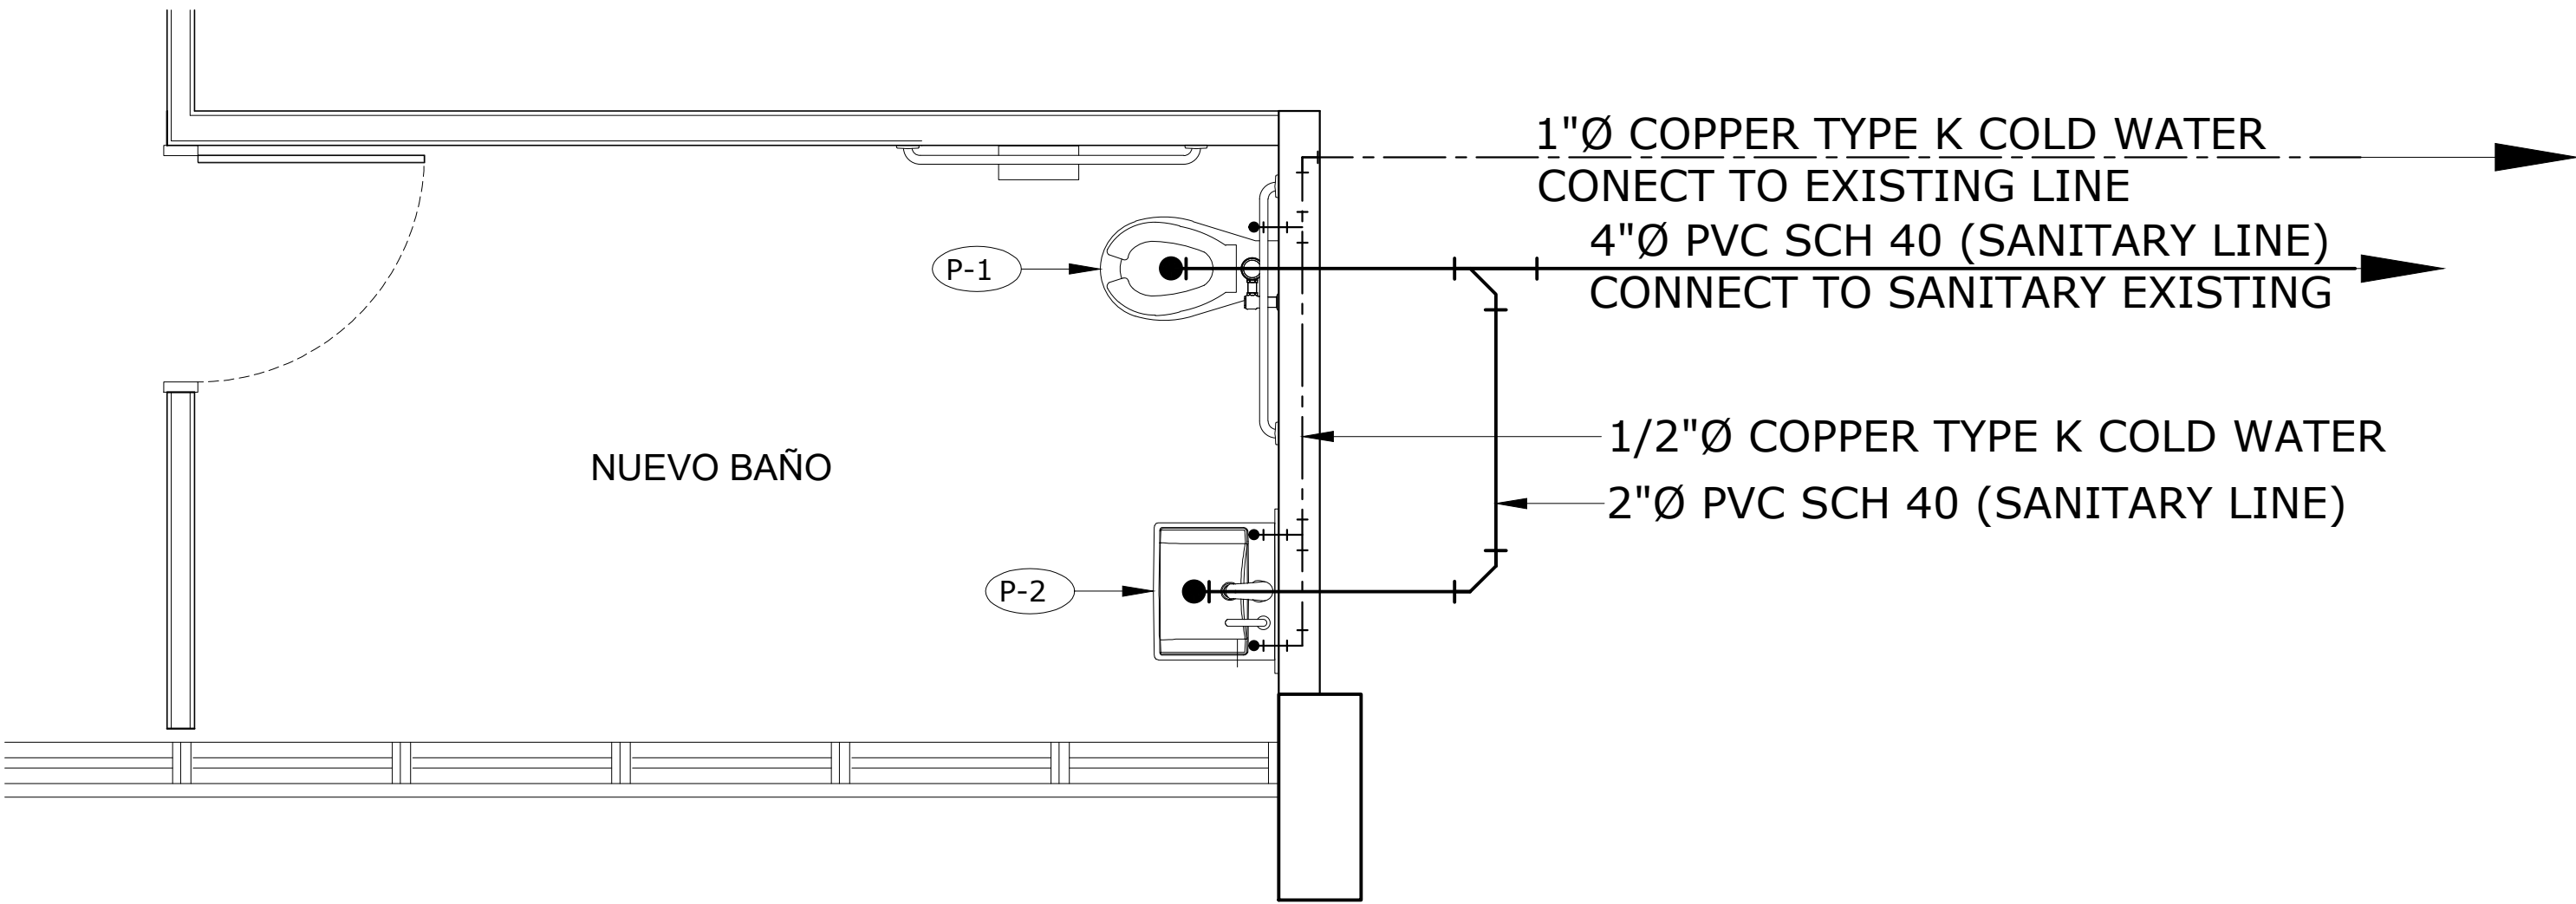

PLUMBING FLOOR PLAN (new bath)
SECOND FLOOR PLAN (edificio principal)
SCALE: 1/2"=1'-0"

BATHROOM ACCESSORIES							
MKD.	DESCRIPTION	STYLE	MODEL NUMBER	MOUNTING HEIGHT	MFR.	REMARKS	LOCATION
A	FOAM SOAP DISPENSER	TOUCHLESS SENSOR- OPERATED	7770100.002	-	AMERICAN STANDARD	POLISHED CHROME FINISH	ALL BATHROOMS
B	PAPER TOWEL DISPENSER & WASTE RECEPTACLE	SURFACE MOUNTED CONVERTIBLE	B-3949	SURFACE MOUNTED SEE ELEV.	BOBRICK	SATIN-FINISH STAINLESS STEEL	ALL BATHROOMS
C	MIRROR	STAINLESS STEEL CHANNEL FRAME	B-165	40" MAX. TO REFLECTIVE SURFACE	BOBRICK	STAINLESS STEEL WITH BRIGHT-POLISHED FINISH	ALL BATHROOMS
D	BABY CHANGING STATION	SURFACE MOUNTED STAINLESS STEEL	9013-9	SEE ELEVATION	AMERICAN SPECIALTIES, INC	STAINLESS STEEL	ALL BATHROOMS
E	COAT HOOK	HEAVY-DUTY CLOTHES HOOK	B-2116	48" MAX. A.F.F.	BOBRICK	38" TO 40" MAX A.F.F. TO TOP OF BASE	ALL TOILET COMPARTMENT DOORS
F	42" GRAB BAR	STRAIGHT GRAB BAR	B-5806X42	36" MAX. GRIPPING SURFACE	BOBRICK	33" MIN. - 36" MAX. A.F.F. TO TOP GRIPPING SURFACE	ACCESSIBLE TOILET COMPARTMENT
G	TOILET ROLL HOLDER	SURFACE MOUNTED SINGLE JUMBO-TOILET ROLL HOLDER	B-9890	15" MIN. OPERABLE PART A.F.F.	BOBRICK	STAINLESS STEEL, SATIN FINISH	ALL TOILET COMPARTMENTS
H	36" GRAB BAR	STRAIGHT GRAB BAR	B-5806X36	36" MAX. GRIPPING SURFACE A.F.F.	BOBRICK	33" MIN. - 36" MAX. A.F.F. TO TOP GRIPPING SURFACE	ACCESSIBLE TOILET COMPARTMENT
I	TOILET PARTITION	SOLID PLASTIC HDPE	SERIES 400	MIN. 17" - MAX 19" TO TOP OF THE SEAT	BRADLEY	SUBMIT COLOR PALETTE FOR ARCHITECT APPROVAL	ALL BATHROOMS

MK'D	EQUIPMENT	MODEL & DESCRIPTION
P-1	HANDICAPED TOILETS	CADET 18"H EL 3.5 ELONGATED FLUSH VALVE TOILET. COLOR: WHITE OLSONITE #95 SEAT, FLUSH VALVE: SLOAN ROYAL #115-3
P-4	LAVATORIES	AQUALYN COUNTERTOP LAVATORY MODEL:0475.020, COLOR: WHITE. REQUIRED FAUCET:GOOSENECK7831.000 BY HERITAGE, FINISH: POLISHED CHROME AMARILIS SERIES HANDLES CROSS TYPE #352V.

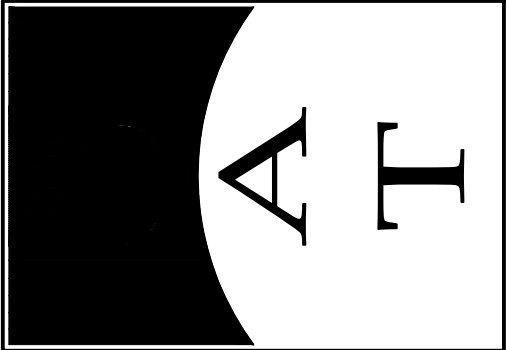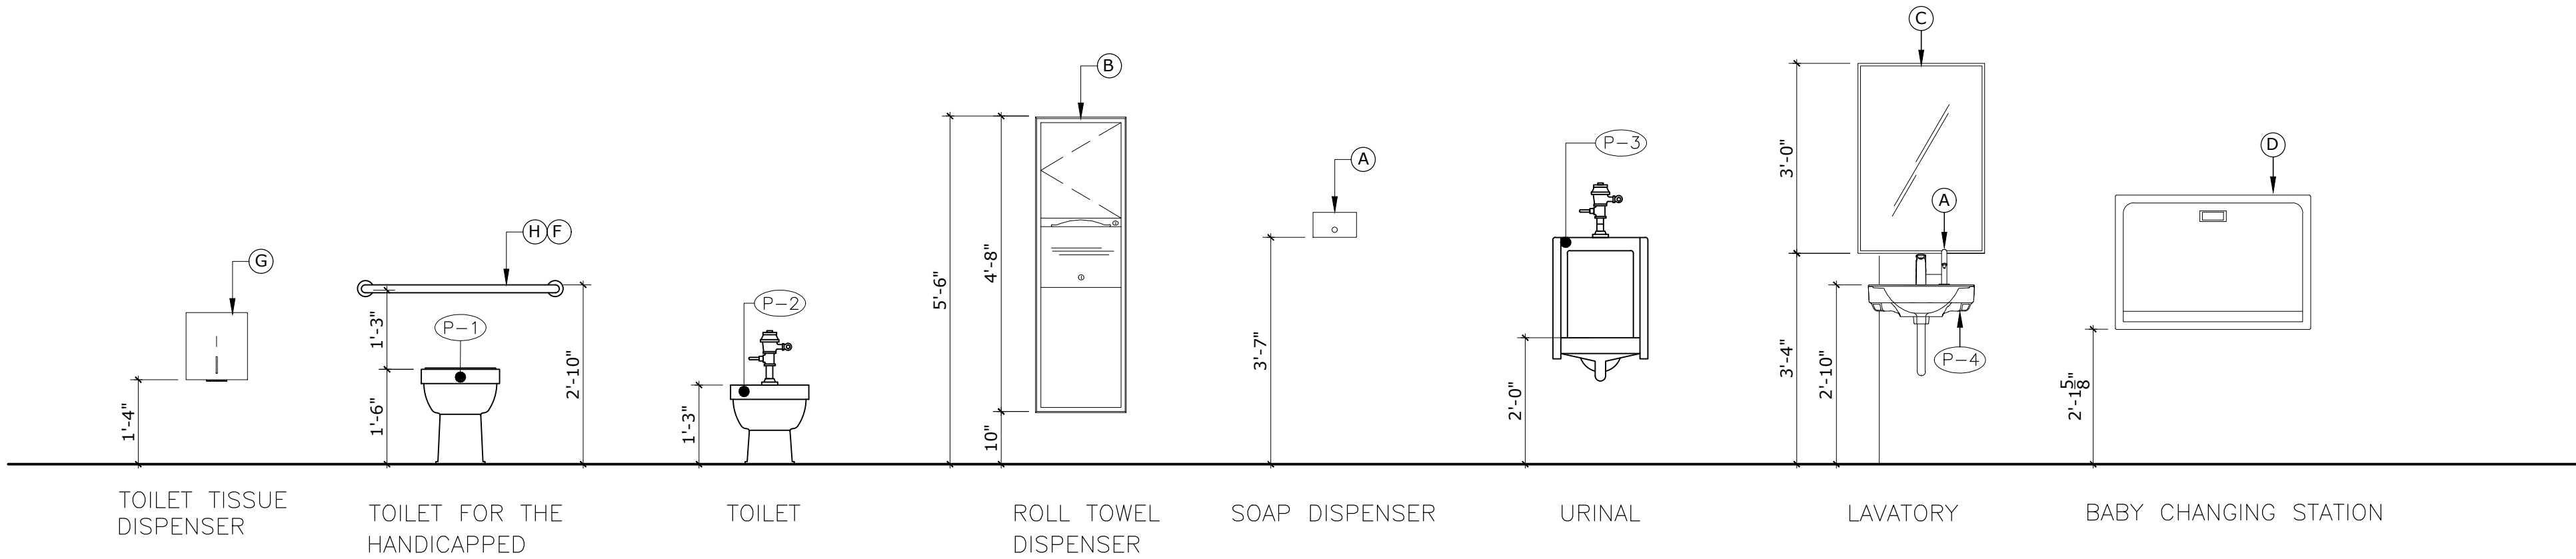

R E V I S I O N S			
NO.	DESCRIPTION	DATE	BY

TRIBUNAL GENERAL DE JUSTICIA OFICINA DE ADMINISTRACION DE LOS TRIBUNALES DIRECTORIA DE ADMINISTRACION OFICINA DE ADMINISTRACION Y CONSERVACION DE LOCALES	APPROVED BY: _____ APPROVED SIGN: _____ APPROVED DATE: _____
--	--

PROJECT NAME: DIGITALIZACION PLANOS RAMA JUDICIAL(Actualizacion 5-10-10)	PROJECT LOCATION: TRIBUNAL SUPREMO	PROJECT DATE: 21-ENERO-2025	CHECKED BY: SUPER EN ADMINISTRACION	PROJECT DATE: 21-ENERO-2025	DRAWING SCALE: 1/8"=1'-0"
PROJECT NO: NEW BATH SR JUEZ COLON	PROJECT NO: NEW BATH SR JUEZ COLON	PROJECT NO: NEW BATH SR JUEZ COLON	PROJECT NO: NEW BATH SR JUEZ COLON	PROJECT NO: NEW BATH SR JUEZ COLON	PROJECT NO: NEW BATH SR JUEZ COLON
PROJECT NO: NEW BATH SR JUEZ COLON	PROJECT NO: NEW BATH SR JUEZ COLON	PROJECT NO: NEW BATH SR JUEZ COLON	PROJECT NO: NEW BATH SR JUEZ COLON	PROJECT NO: NEW BATH SR JUEZ COLON	PROJECT NO: NEW BATH SR JUEZ COLON
PROJECT NO: NEW BATH SR JUEZ COLON	PROJECT NO: NEW BATH SR JUEZ COLON	PROJECT NO: NEW BATH SR JUEZ COLON	PROJECT NO: NEW BATH SR JUEZ COLON	PROJECT NO: NEW BATH SR JUEZ COLON	PROJECT NO: NEW BATH SR JUEZ COLON
PROJECT NO: NEW BATH SR JUEZ COLON	PROJECT NO: NEW BATH SR JUEZ COLON	PROJECT NO: NEW BATH SR JUEZ COLON	PROJECT NO: NEW BATH SR JUEZ COLON	PROJECT NO: NEW BATH SR JUEZ COLON	PROJECT NO: NEW BATH SR JUEZ COLON