



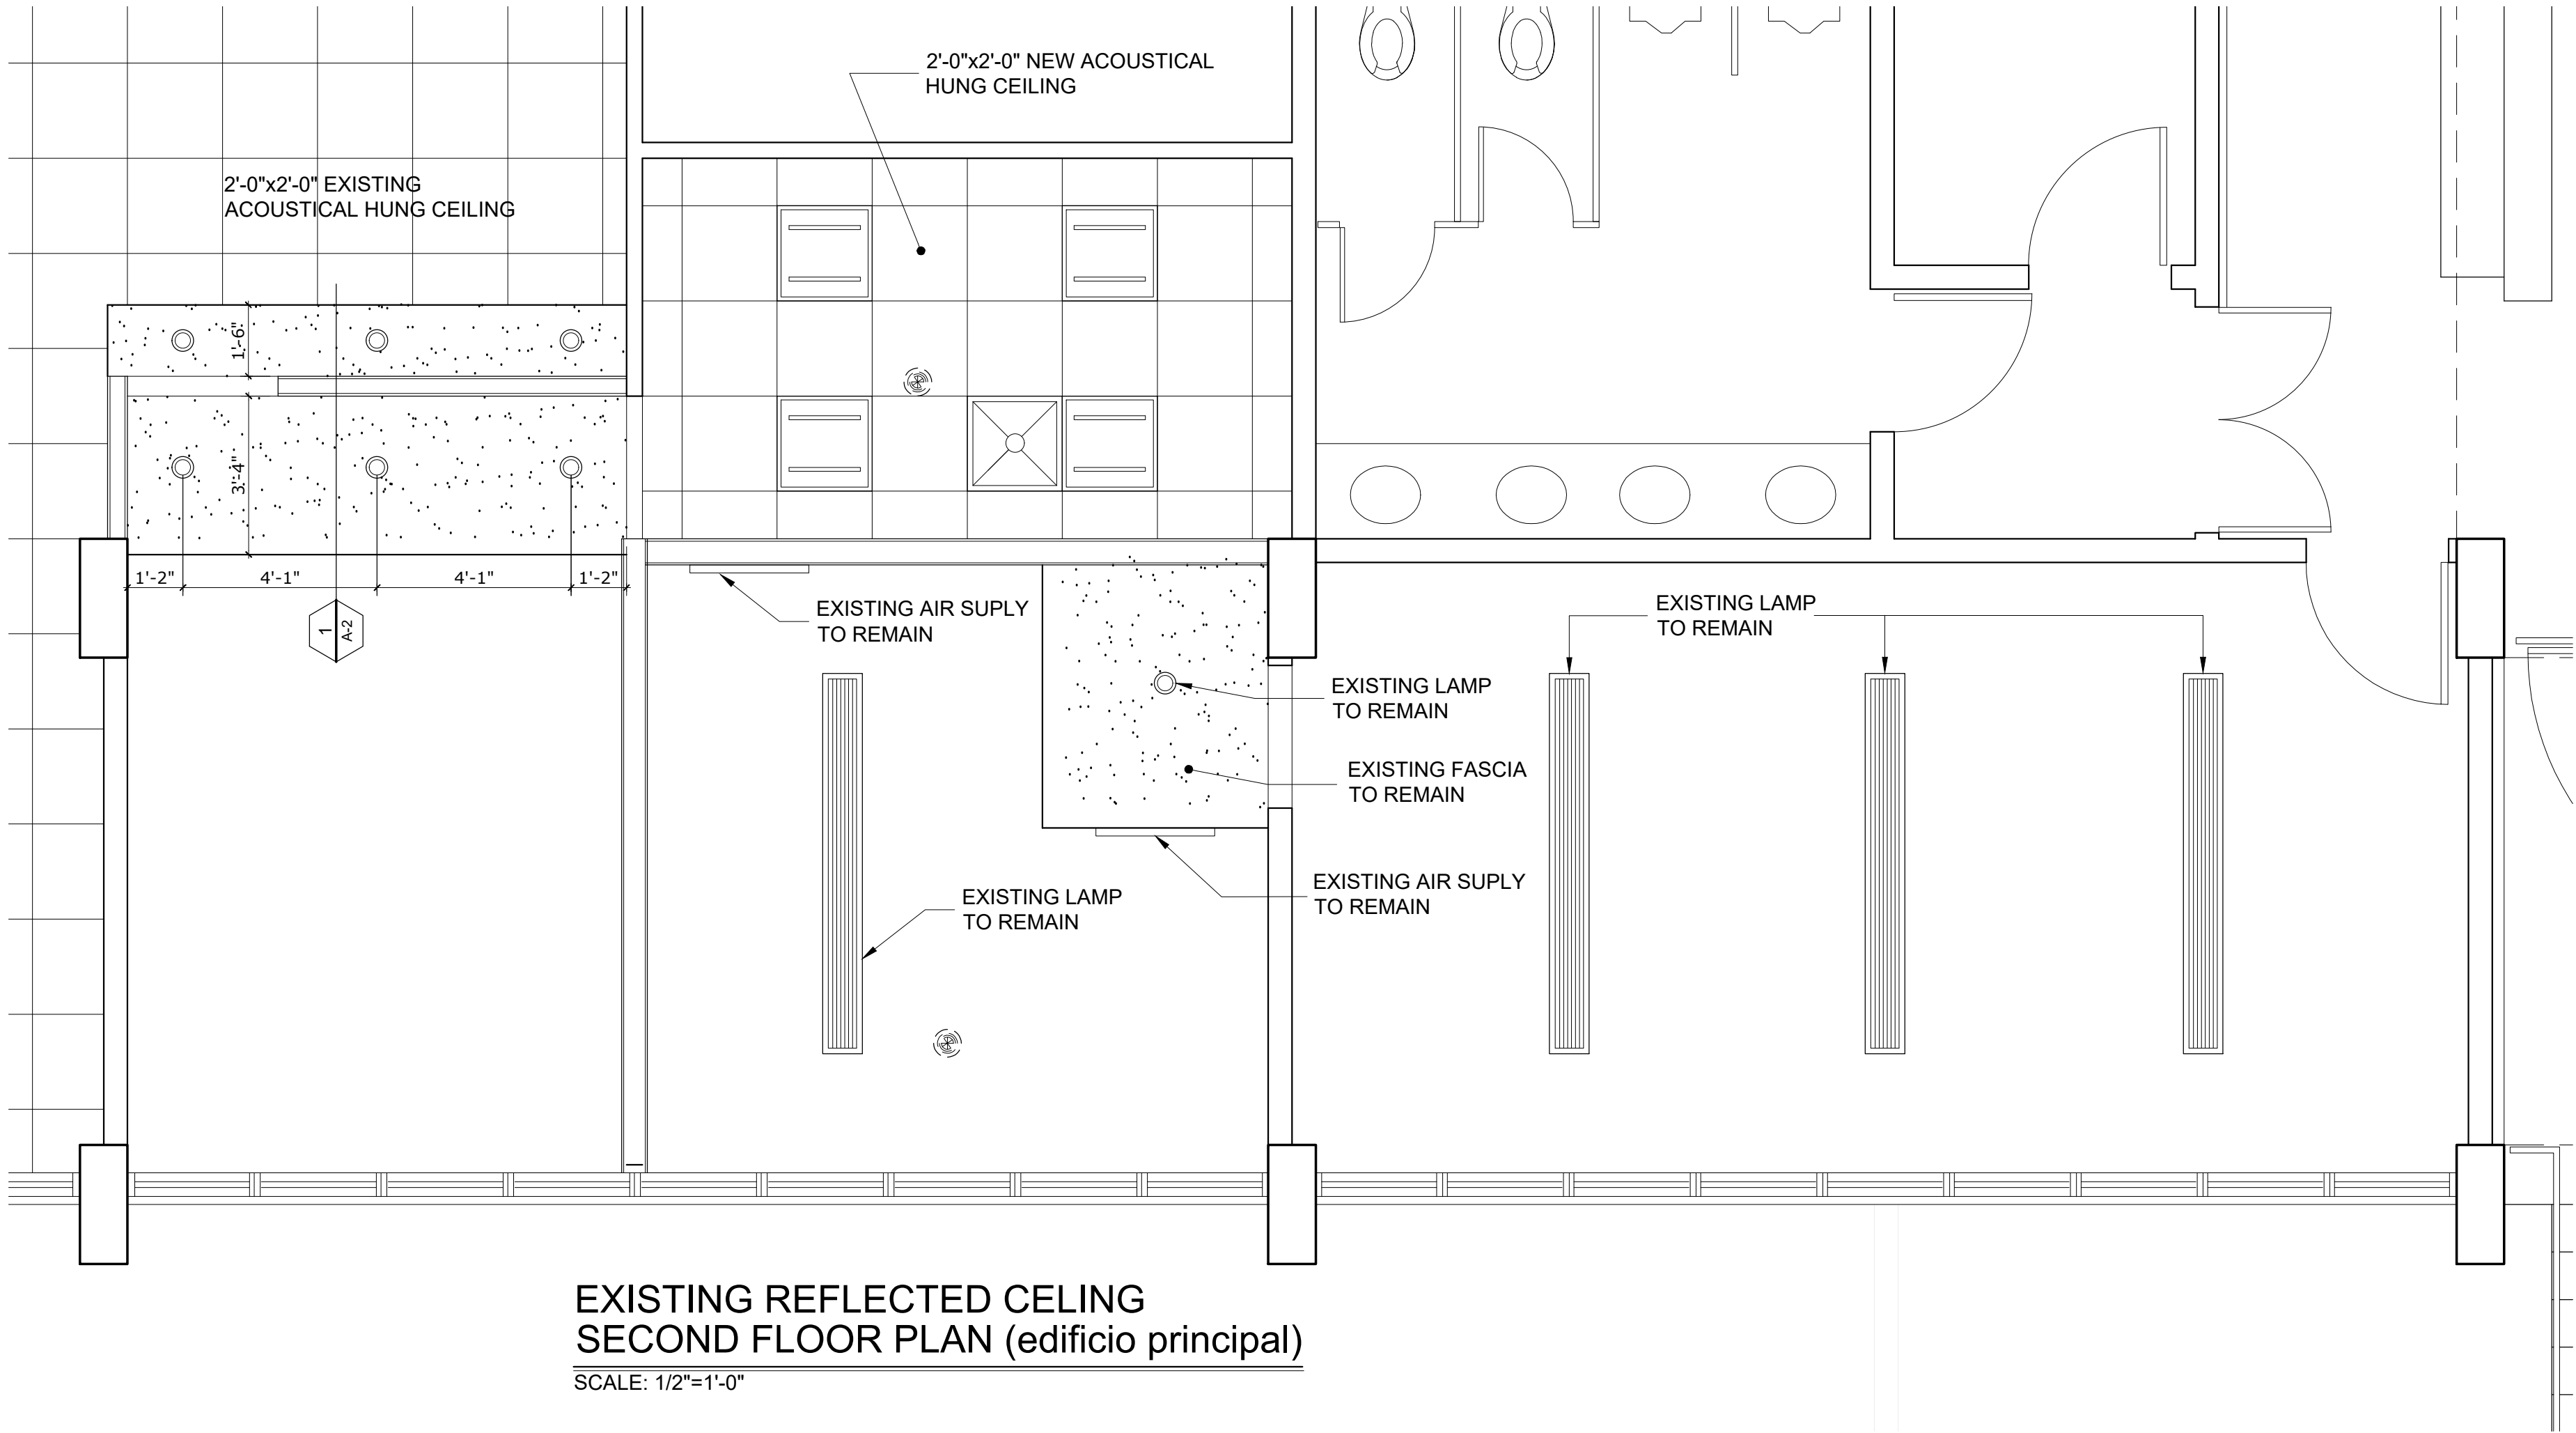

EXISTING REFLECTED CELING
SECOND FLOOR PLAN (edificio principal)
SCALE: 1/2"=1'-0"

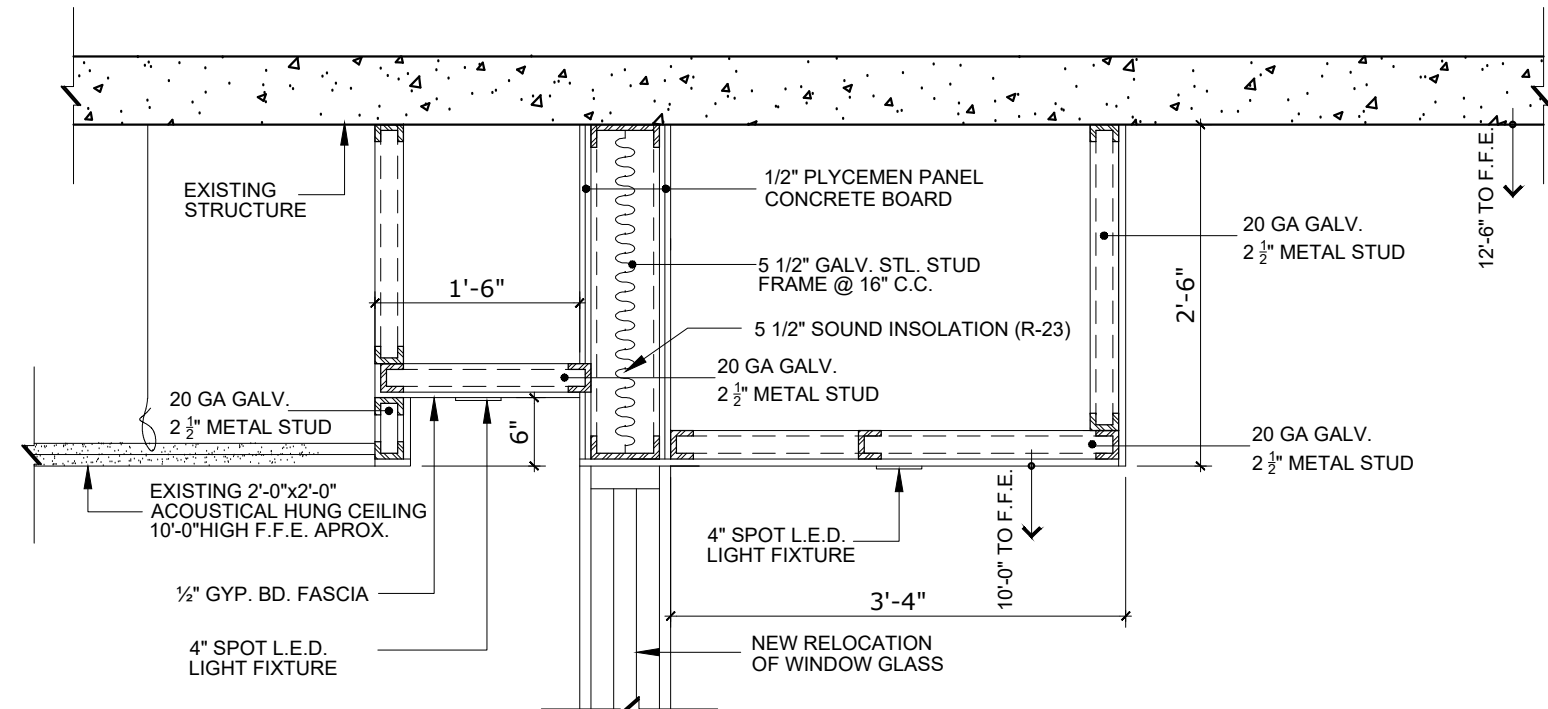

DETAIL
SCALE: 3/4"=1'-0"

LEGEND:

- 2'-0"x2'-0" NEW ACOUSTICAL HUNG CEILING
- NEW WHITE FLAT PANEL LED LIGHT, 3200 MINIMUM LUMENS, 4000K LIGHT TEMPERATURE, TO BE INSTALLED.
- EXISTING A/C 2'x2' SUPPLY.
- EXISTING SMOKE DETECTOR TO REMAIN
- NEW EXIT LIGHT COMBO LED
- EXISTING RETURN AIR GRILLE TO REMAIN
- FIRE ALARM TO BE REM,AIN
- EXISTING CEILING SPOTLIGHT TO REMAIN

AT

R E V I S I O N S		BY
NO.	DESCRIPTION	DATE

TRIBUNAL GENERAL DE JUSTICIA
OFICINA DE ADMINISTRACION DE LOS TRIBUNALES
DIRECTORIA DE ADMINISTRACION
OFICINA DE ADMINISTRACION Y CONSERVACION DE LOCALES

APPROVED BY: _____ APPROVED DATE: _____

PROJECT NAME: DIGITALIZACION PLANOS RAMA JUDICIAL(Actualizacion 5-10-10)

PROJECT LOCATION: TRIBUNAL SUPREMO

DRAWING DESCRIPTIONS: REFLECTED CELING

GERENTE DE PROYECTO: _____

PROYECTO DATE: 21-ENERO-2025

DRAWING BY: P.MORALES

DRAWING SCALE: 1/8"=1'-0"

OF: A-02

SHEET NO. 1